

**Disclaimer:**  
 Drawings are only meant only to illustrate ideas and are not to be used for construction. All structural elements shown in the design must be evaluated and stamped by a certified technical director before construction. The designer does not assume any liability for structural integrity in the designs. The company selected to build the designs will assume all liability to its structural integrity and related consumer, crew and performer safety.

*Brandon M. Newton*  
 Scenic Designer Signature

Venue: **Actor's Playhouse**

Stage: **Mainstage Theatre**

Director: **David Arisco**

Technical Director: **Gene Seyffer**

Show Title: **BRIGHT STAR**

Sheet Title: **A1S1 - Limbo**

Date: **02 Mar 2023**


Scale: **1/4" = 1'-0"**

Designer: **Brandon M. Newton**

Drawn By: **Brandon M. Newton**

Sheet Number: **GP-1**

of: **0**

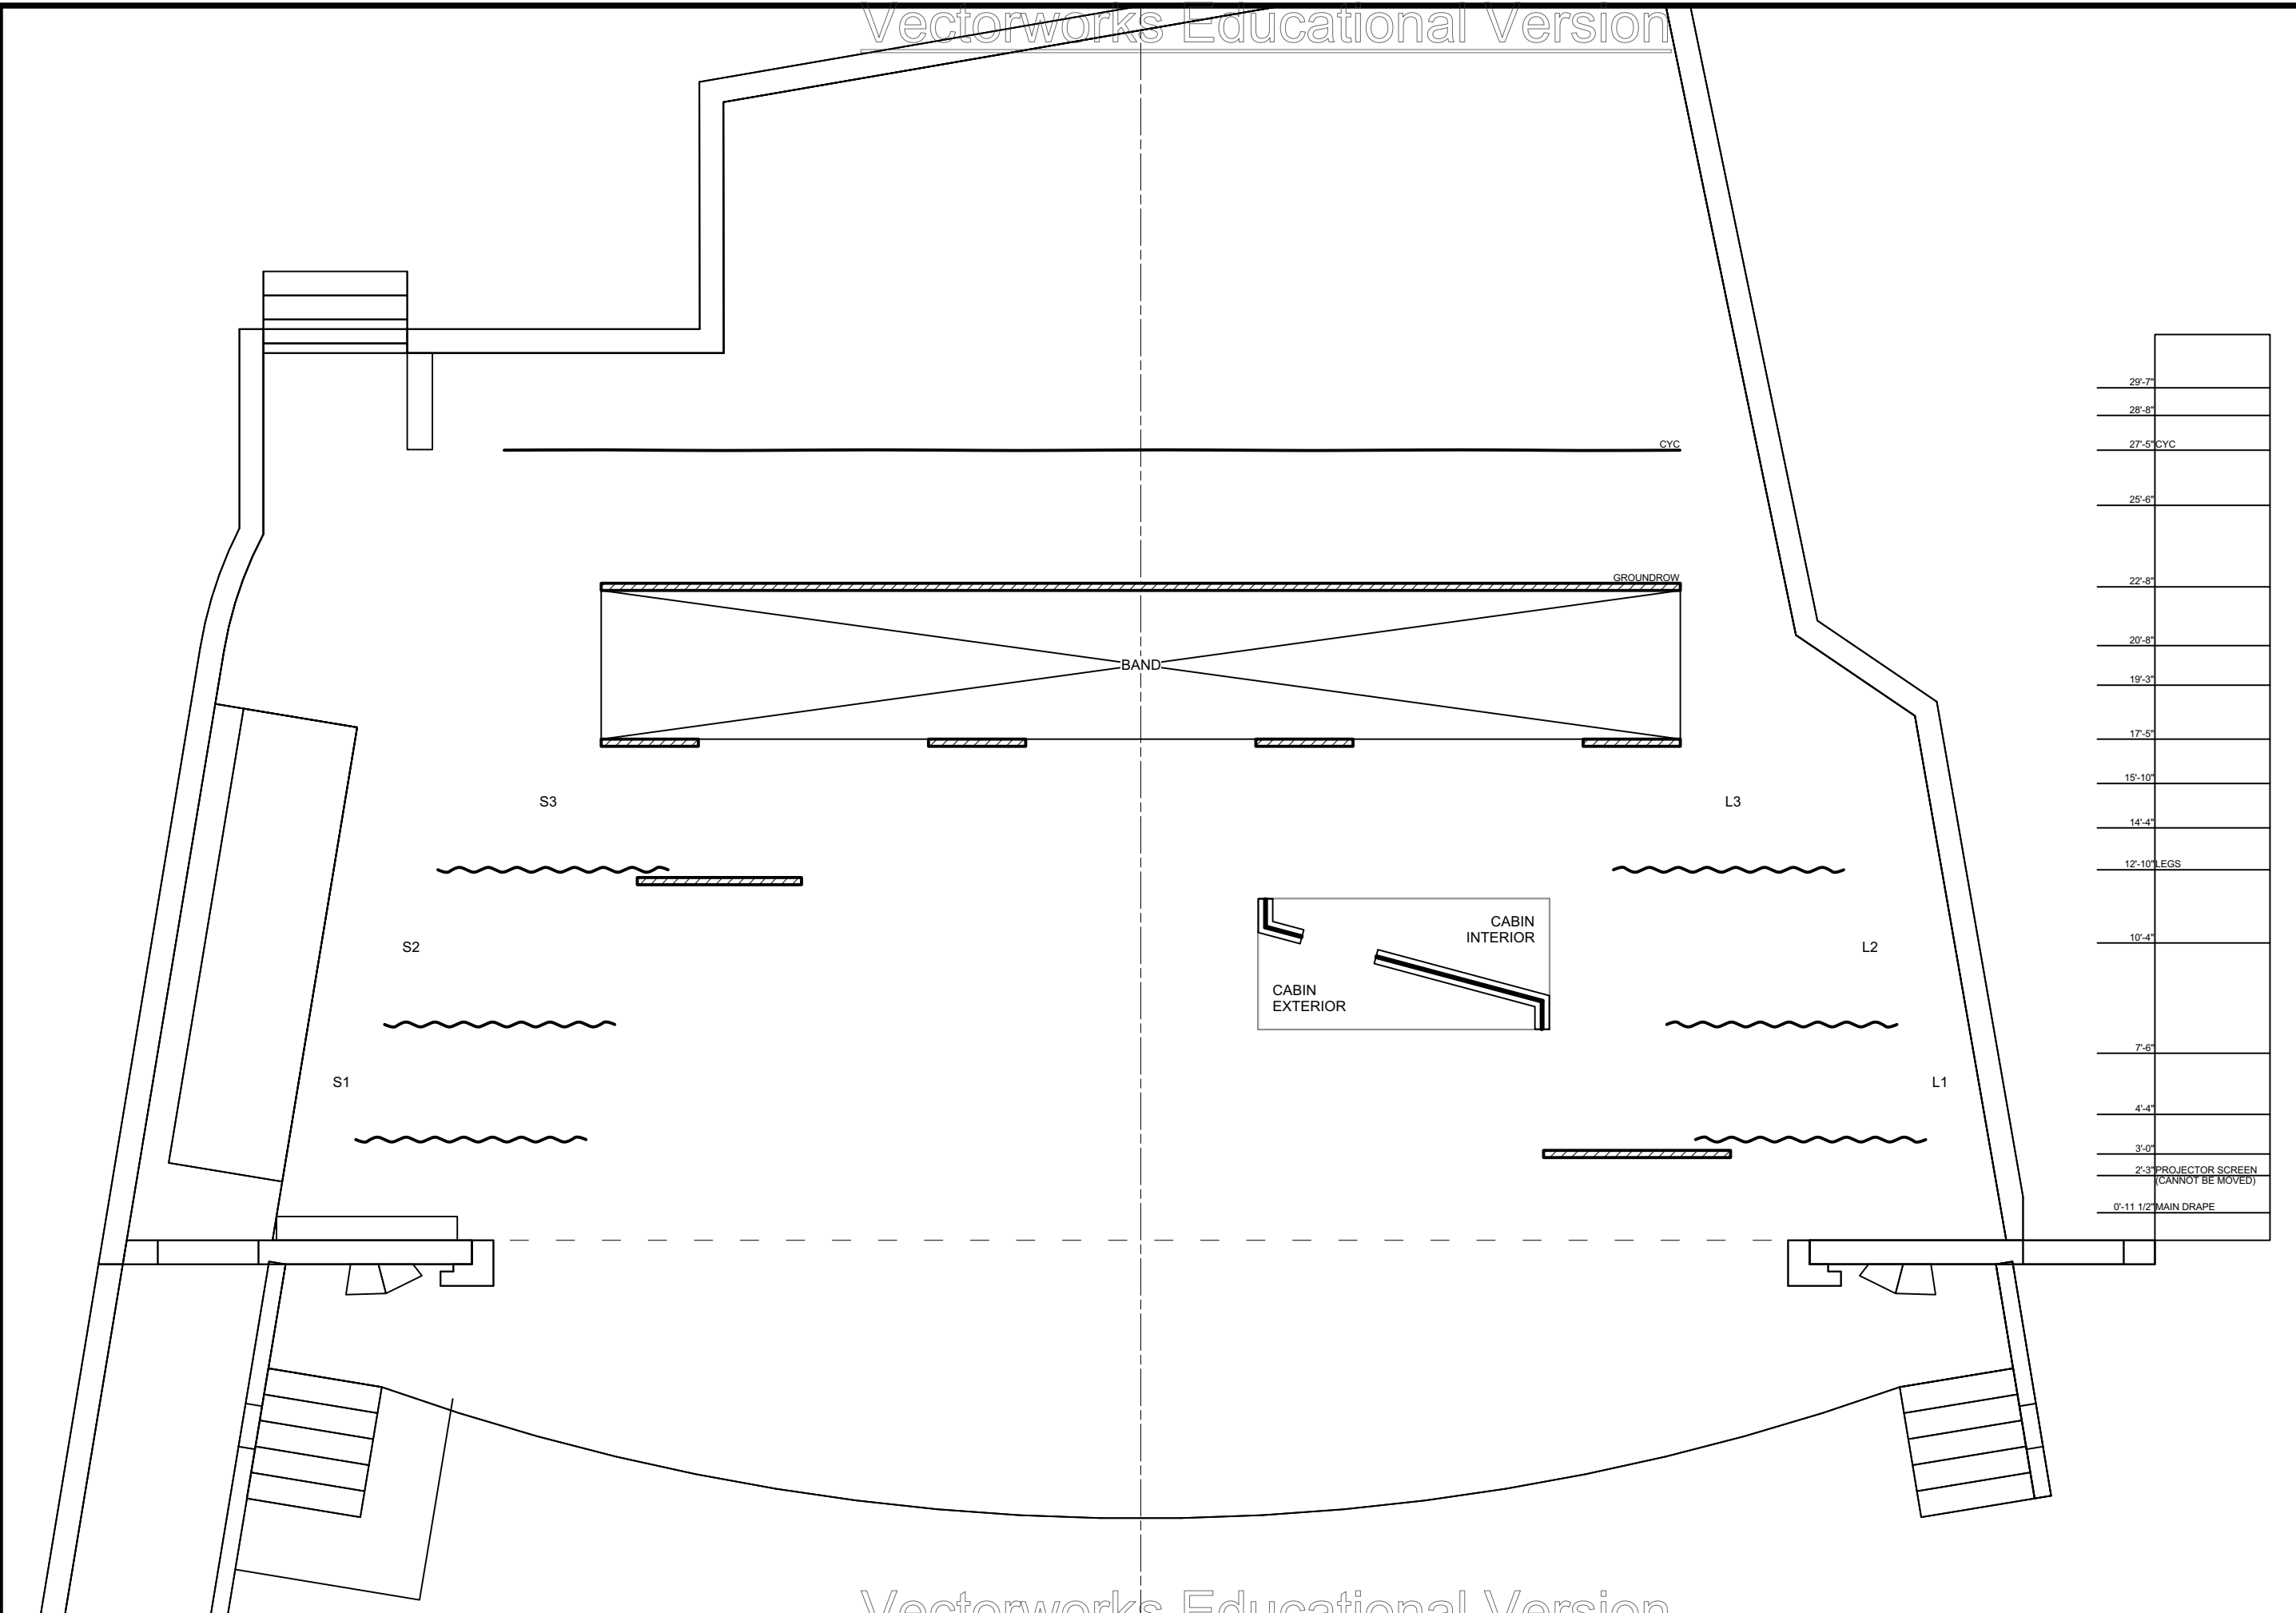

**Disclaimer:**  
 Drawings are only meant only to illustrate ideas and are not to be used for construction. All structural elements shown in the design must be evaluated and stamped by a certified technical director before construction. The designer does not assume any liability for structural integrity in the designs. The company selected to build the designs will assume all liability to its structural integrity and related consumer, crew and performer safety.

*Brandon M. Newton*  
 Scenic Designer Signature

Venue: **Actor's Playhouse**

Stage: **Mainstage Theatre**

Director: **David Arisco**

Technical Director: **Gene Seyffer**

Show Title: **BRIGHT STAR**

Sheet Title: **A1S2 - Billy's Home (1945)**

Date: **02 Mar 2023**


Designer: **Brandon M. Newton**

Scale: **1/4" = 1'-0"**

Drawn By: **Brandon M. Newton**

Sheet Number: **GP-2**

of: **0**

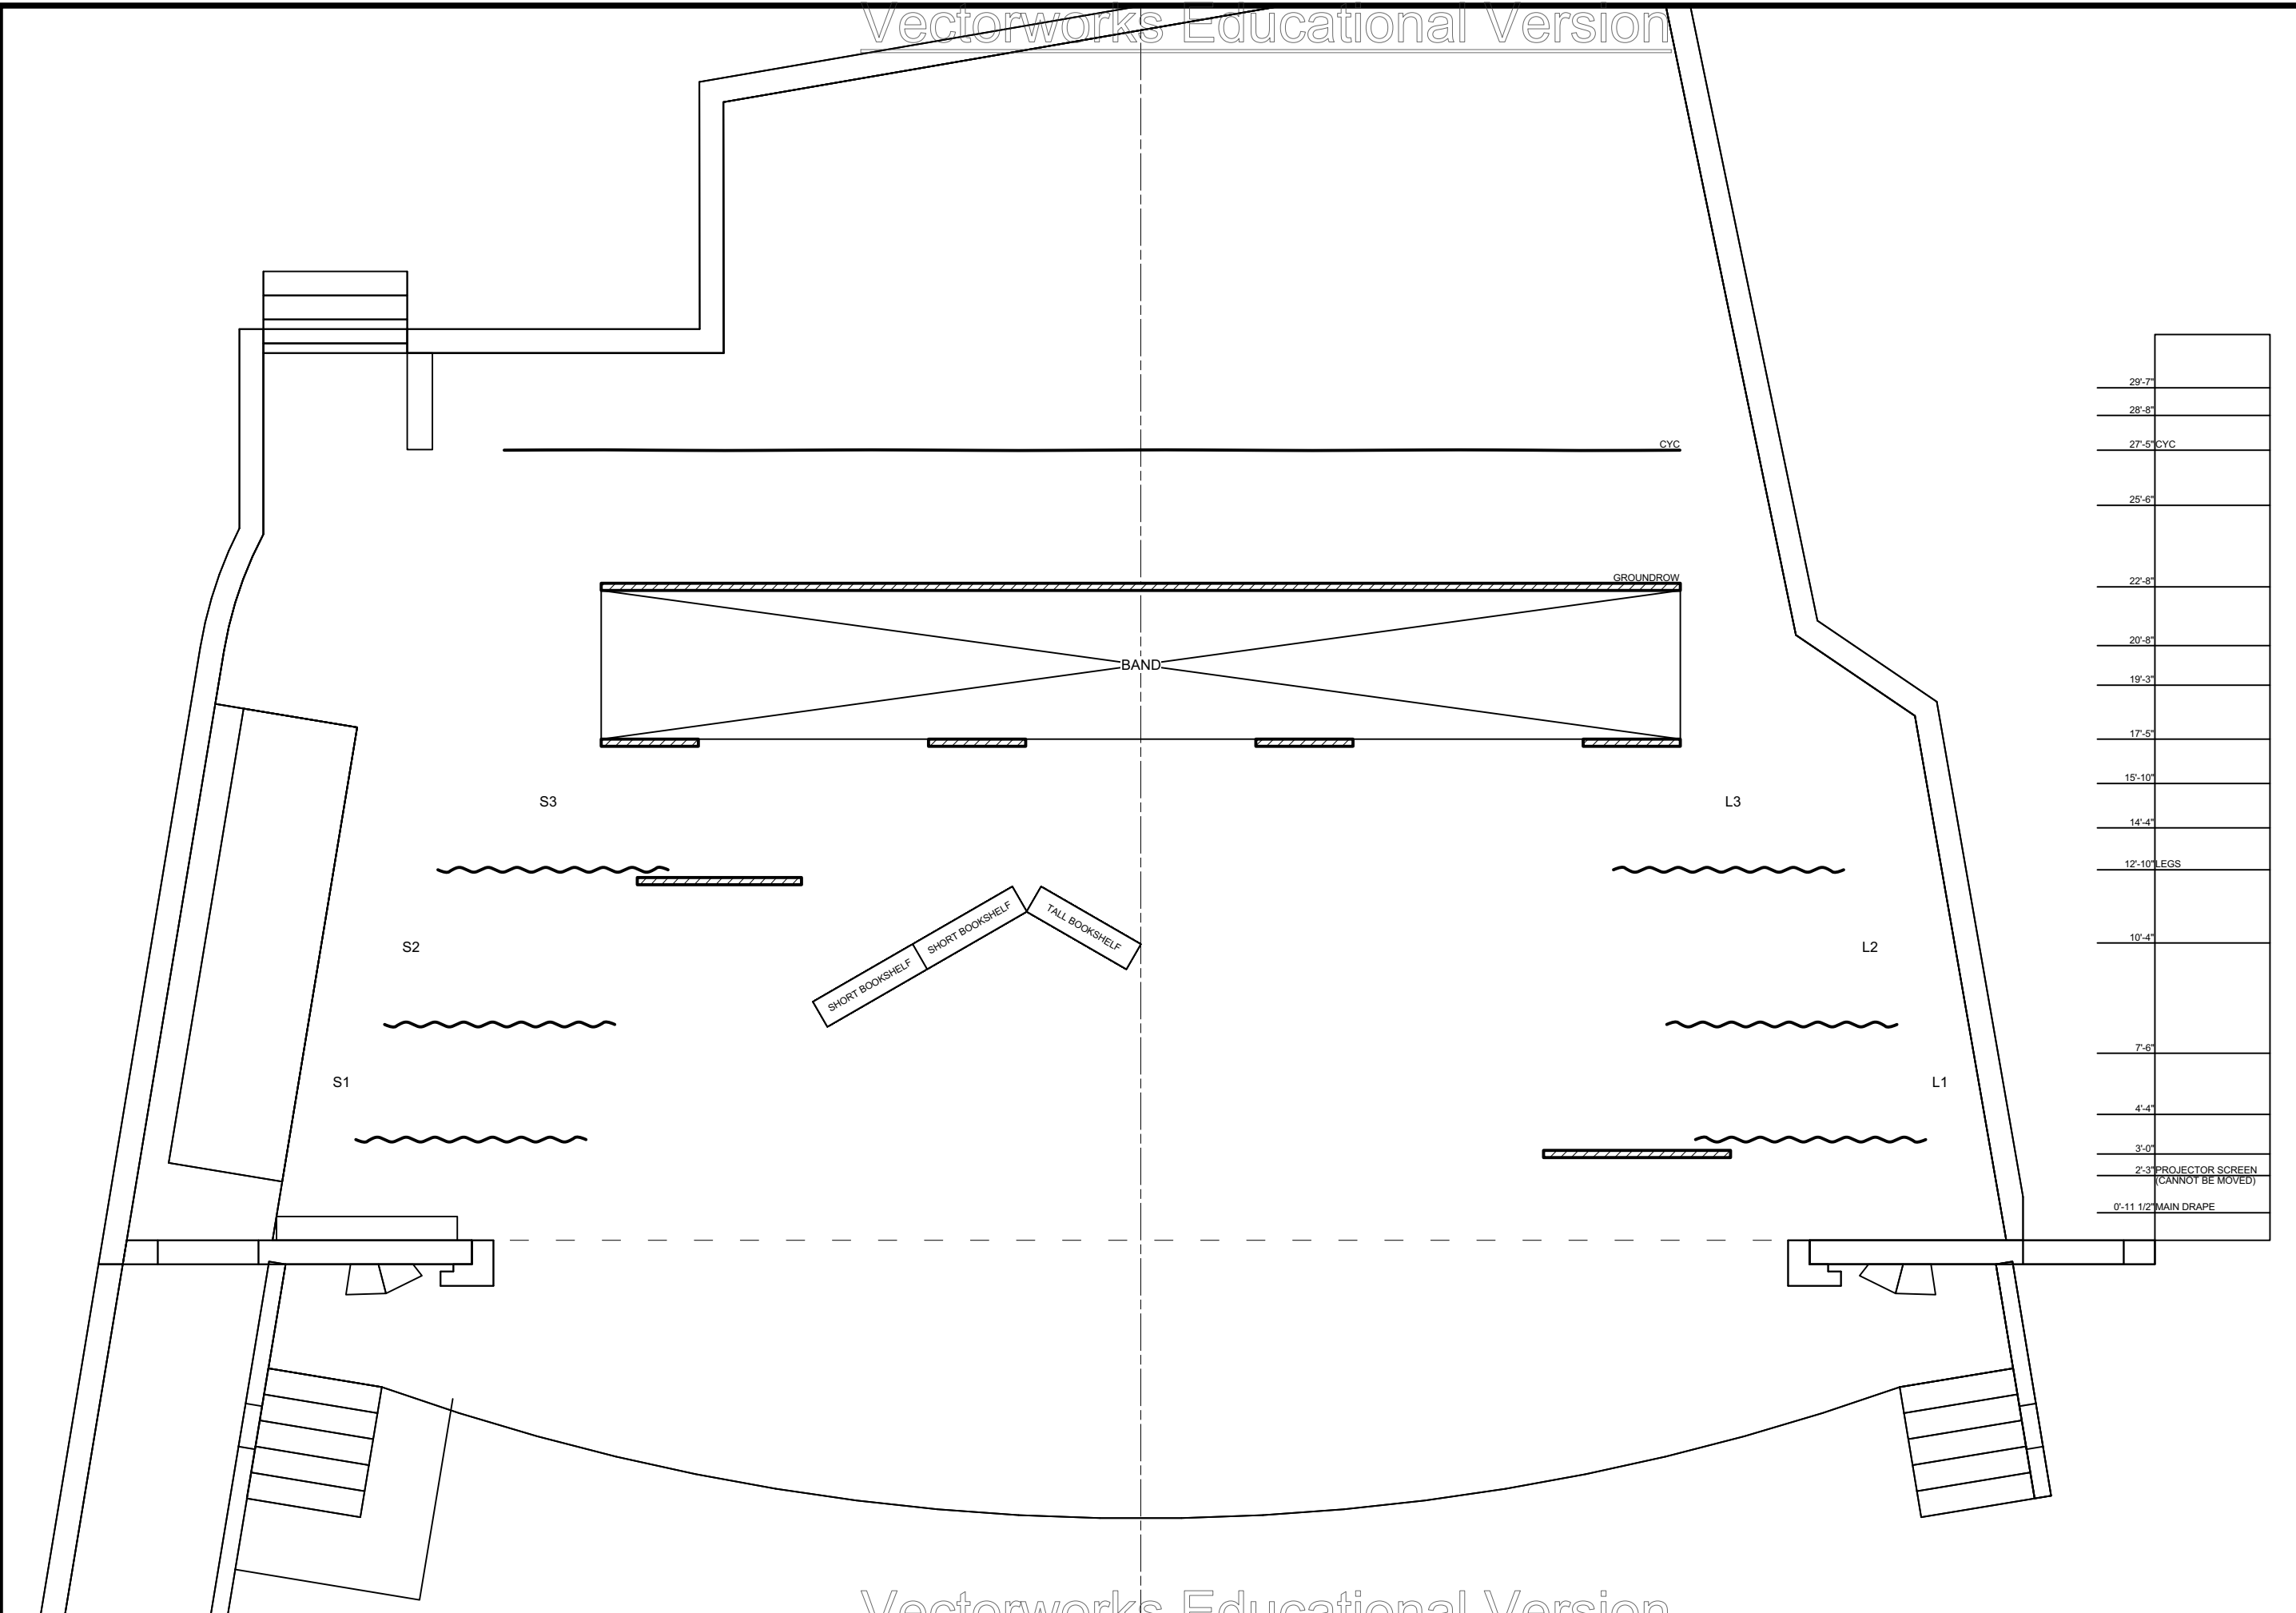


29'-7"	
28'-8"	
27'-5" CYC	
25'-6"	
22'-8"	
20'-8"	
19'-3"	
17'-5"	
15'-10"	
14'-4"	
12'-10" LEGS	
10'-4"	
7'-6"	
4'-4"	
3'-0"	
2'-3" PROJECTOR SCREEN (CANNOT BE MOVED)	
0'-11 1/2" MAIN DRAPE	

**Disclaimer:**  
 Drawings are only meant only to illustrate ideas and are not to be used as a basis for construction. All structural elements shown in the design must be evaluated and stamped by a certified technical director before construction. The designer does not assume any liability for structural integrity in the designs. The company selected to build the designs will assume all liability to its structural integrity and related consumer, crew and performer safety.

*Brandon M. Newton*  
 Scenic Designer Signature

Sheet Title: <b>A1S3 - Margo's Bookshop (1945)</b>	Scale: <b>1/4" = 1'-0"</b>	Drawn By: <b>Brandon M. Newton</b>
Date: <b>02 Mar 2023</b>		Designer: <b>Brandon M. Newton</b>
Venue: <b>Actor's Playhouse</b>		Technical Director: <b>Gene Seyffer</b>
Show Title: <b>BRIGHT STAR</b>		Director: <b>David Arisco</b>
Sheet Number: <b>GP-3</b>		of: <b>0</b>

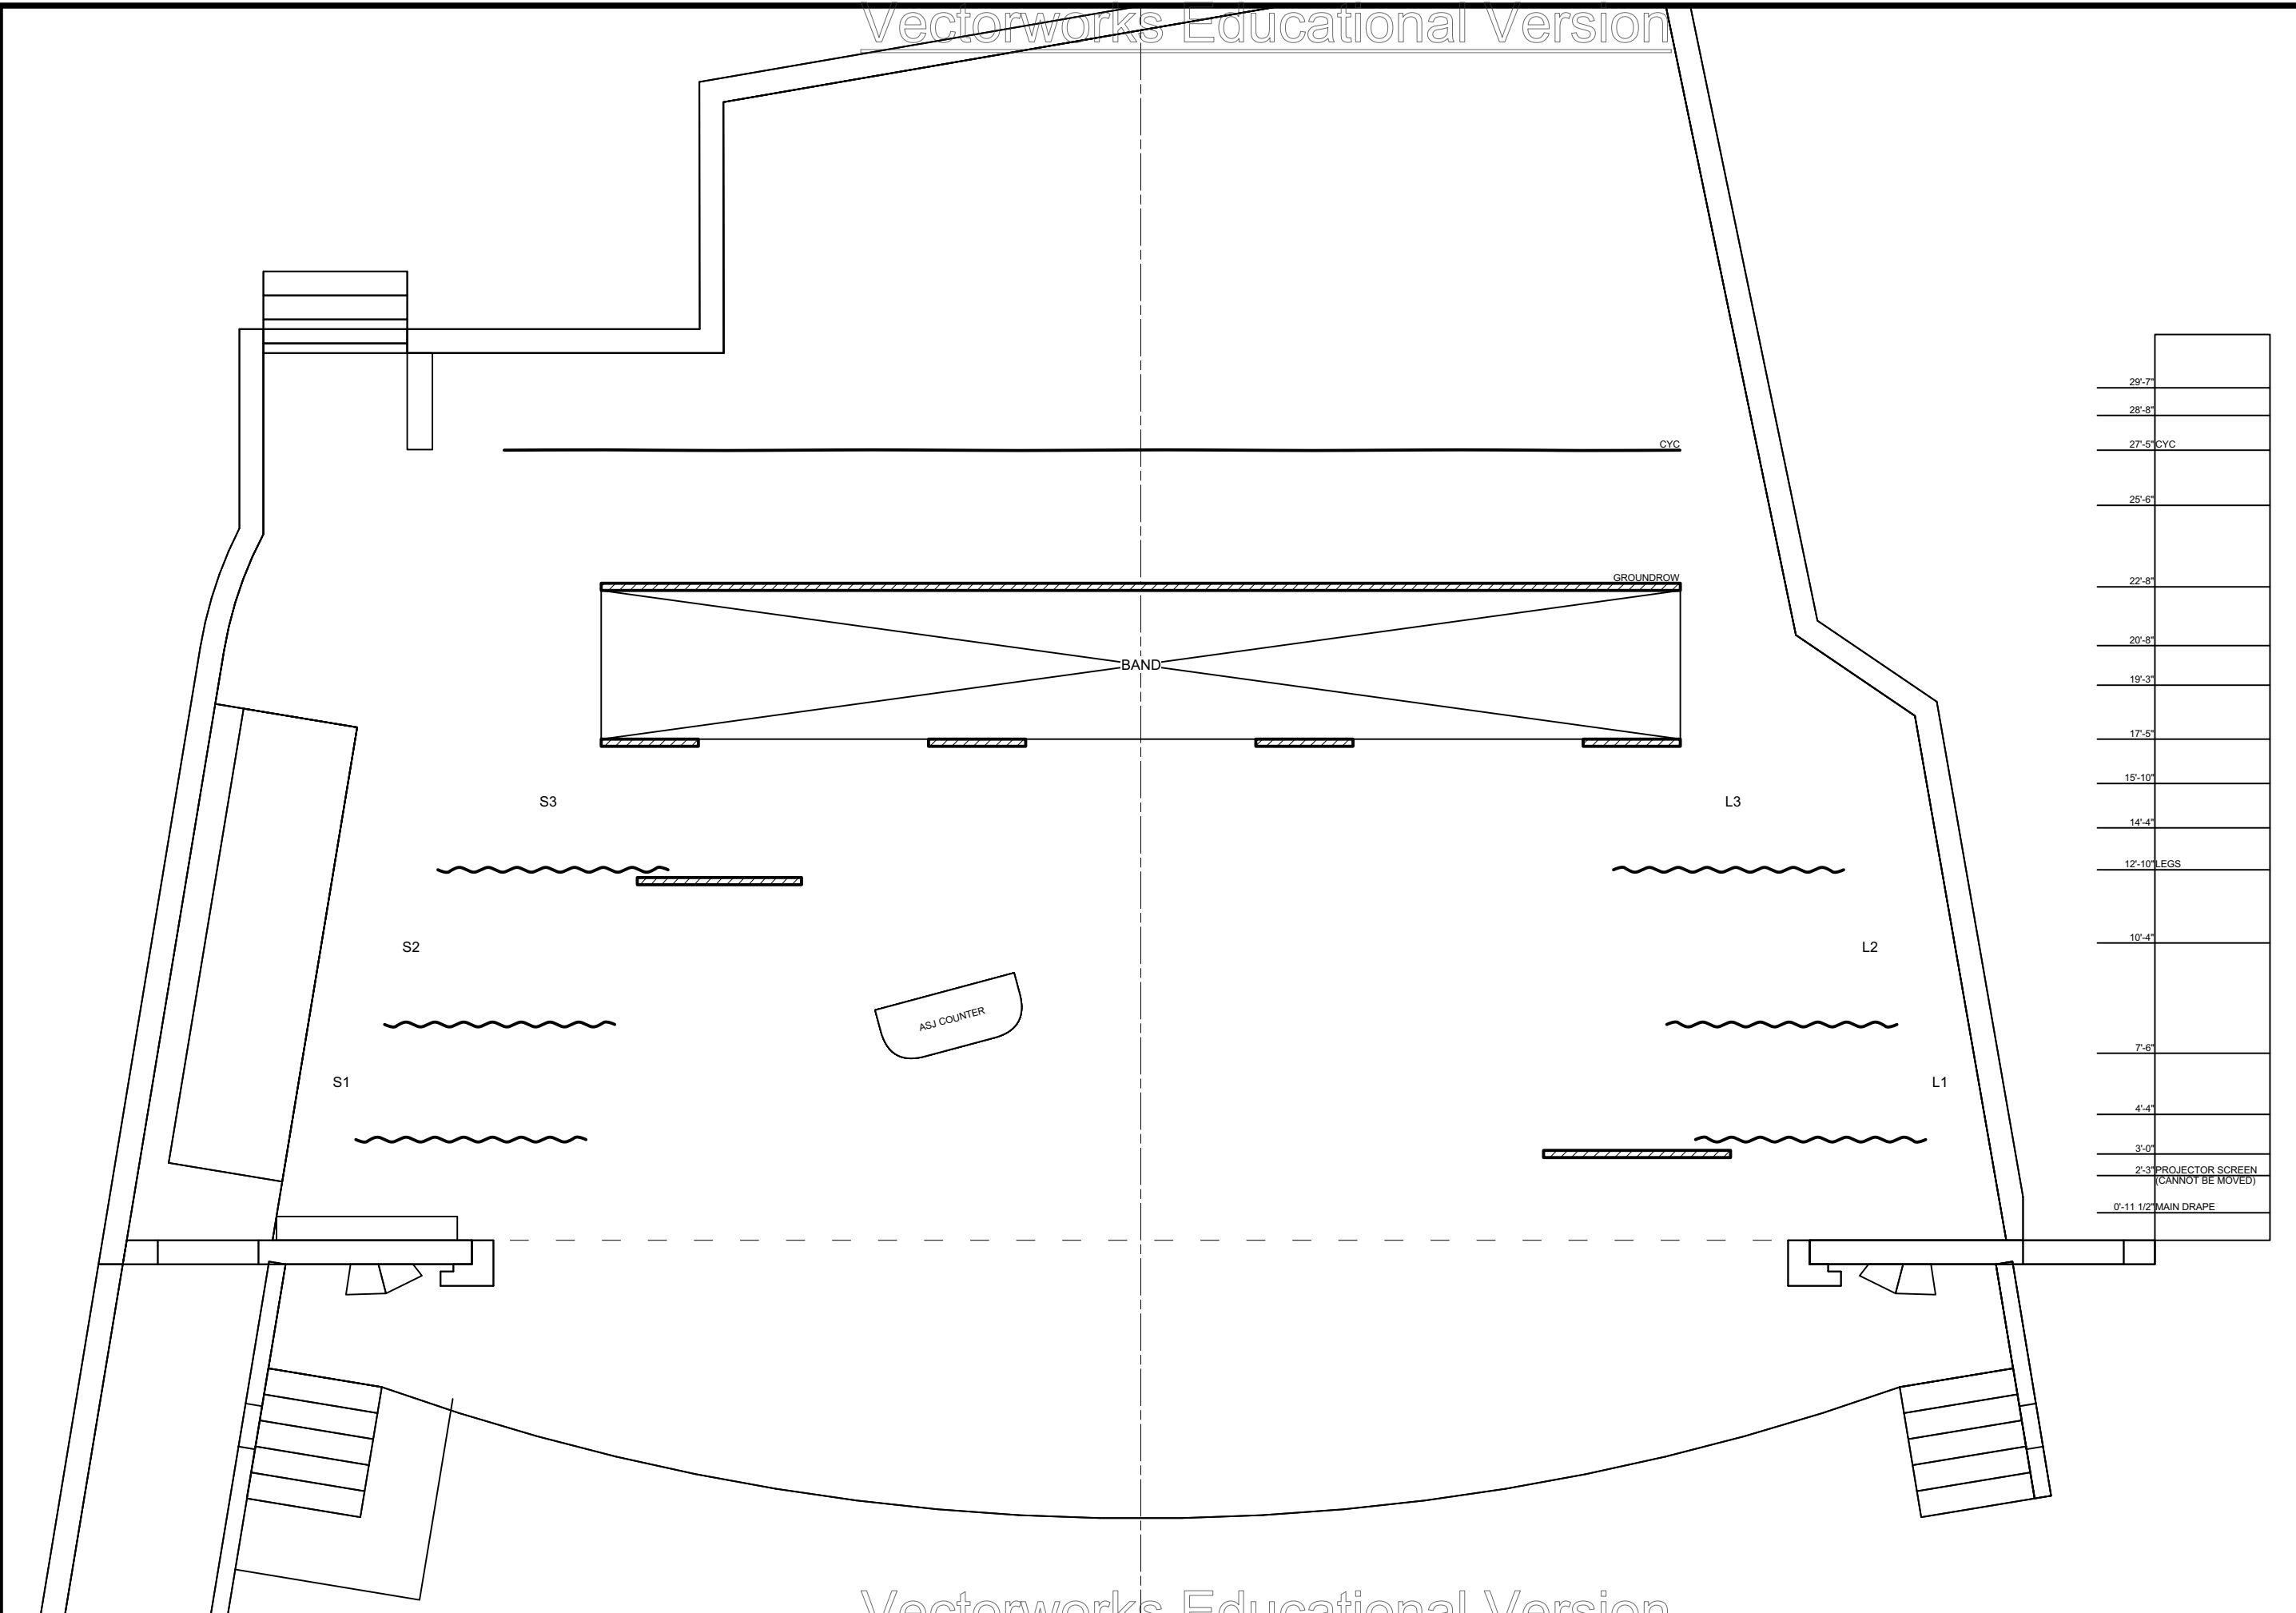


29'-7"	
28'-8"	
27'-5" CYC	
25'-6"	
22'-8"	
20'-8"	
19'-3"	
17'-5"	
15'-10"	
14'-4"	
12'-10" LEGS	
10'-4"	
7'-6"	
4'-4"	
3'-0"	
2'-3" PROJECTOR SCREEN (CANNOT BE MOVED)	
0'-11 1/2" MAIN DRAPE	

**Disclaimer:**  
 Drawings are only meant only to illustrate ideas and are not to be used for construction. All structural elements shown in the design must be evaluated and stamped by a certified technical director before construction. The designer does not assume any liability for structural integrity in the designs. The company selected to build the designs will assume all liability to its structural integrity and related consumer, crew and performer safety.

*Brandon M. Newton*  
 Scenic Designer Signature

Sheet Title: <b>A1S4 - Asheville Southern Journal (1945)</b>	Scale: <b>1/4" = 1'-0"</b>	Drawn By: <b>Brandon M. Newton</b>
Date: <b>02 Mar 2023</b>		Designer: <b>Brandon M. Newton</b>
Venue: <b>Actor's Playhouse</b>		Technical Director: <b>Gene Seyffer</b>
Show Title: <b>BRIGHT STAR</b>		Director: <b>David Arisco</b>
Stage: <b>Mainstage Theatre</b>		

Sheet Number:  
**GP-4** of: **0**

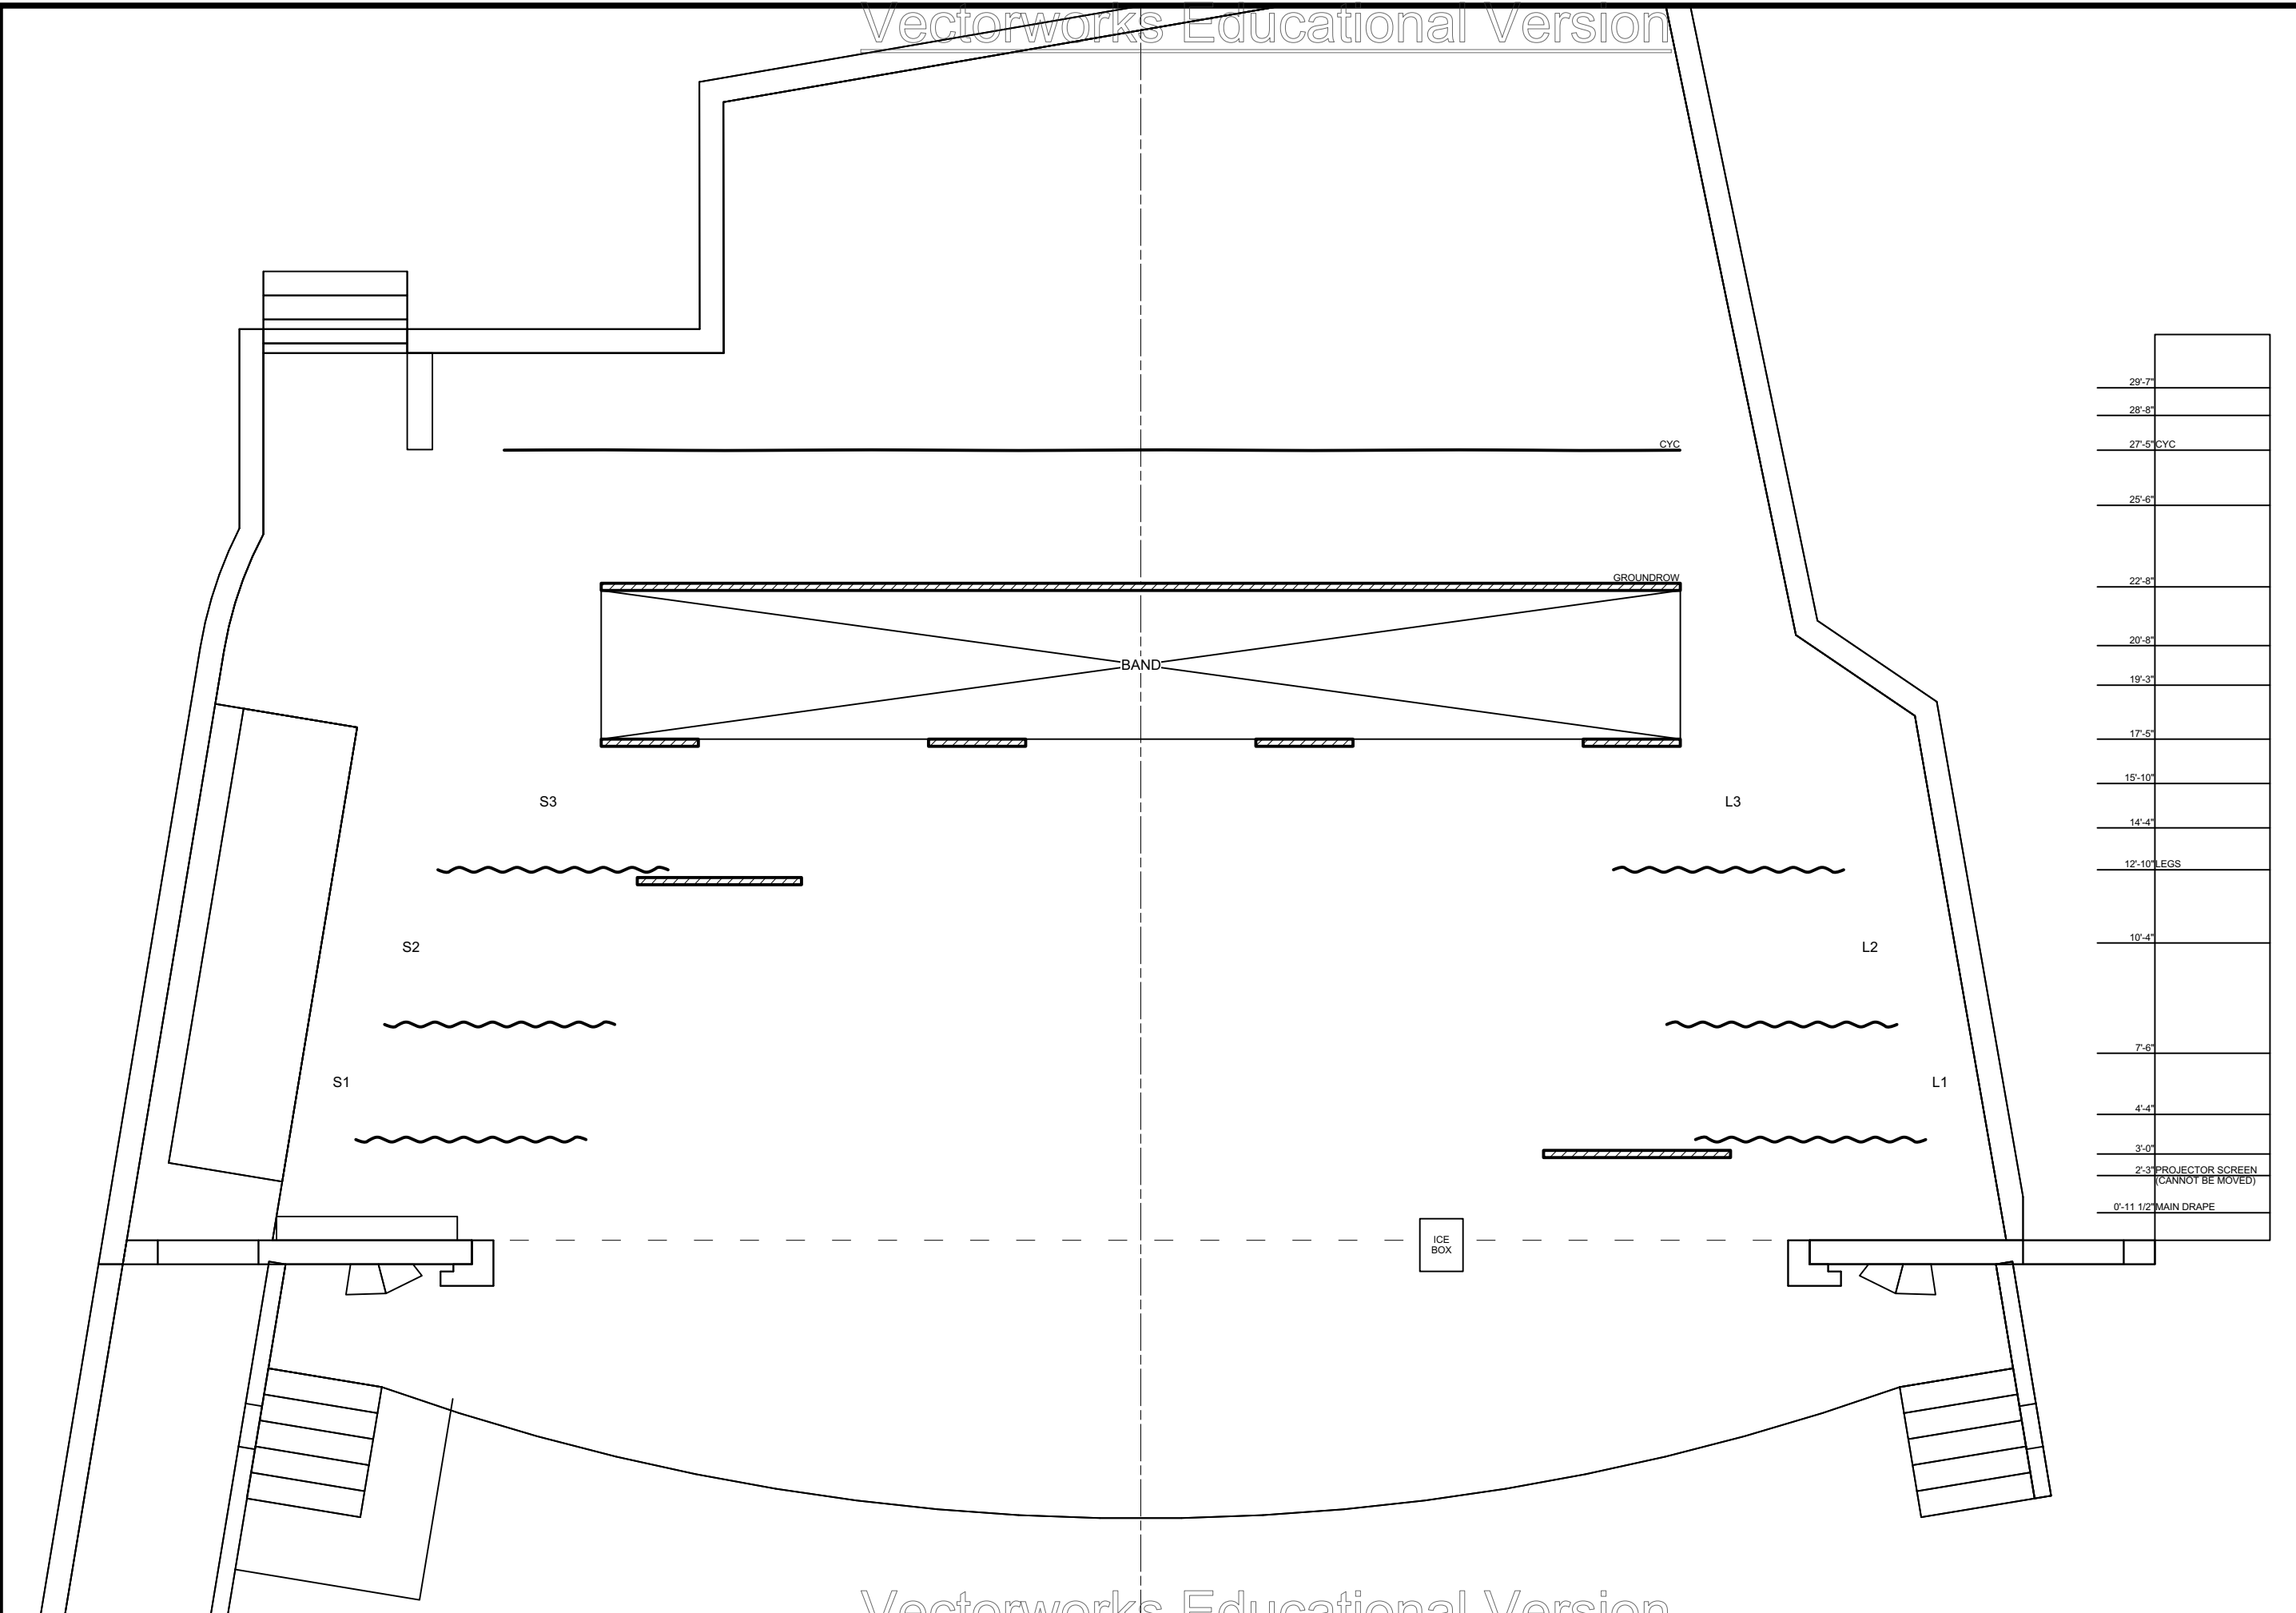

**Disclaimer:**  
 Drawings are only meant only to illustrate ideas and are not to be used as a basis for construction. The designer does not assume any liability for structural integrity in the designs. The company selected to build the designs will assume all liability to its structural integrity and related consumer, crew and performer safety.

*Brandon M. Newton*  
 Scenic Designer Signature

Venue: **Actor's Playhouse**

Stage: **Mainstage Theatre**

Director: **David Arisco**

Technical Director: **Gene Seyffer**

Show Title: **BRIGHT STAR**

Sheet Title: **A1S5 - Zebulon House Exterior (1923)**


Date: **02 Mar 2023**

Scale: **1/4" = 1'-0"**

Designer: **Brandon M. Newton**

Drawn By: **Brandon M. Newton**

Sheet Number: **GP-5** of: **0**

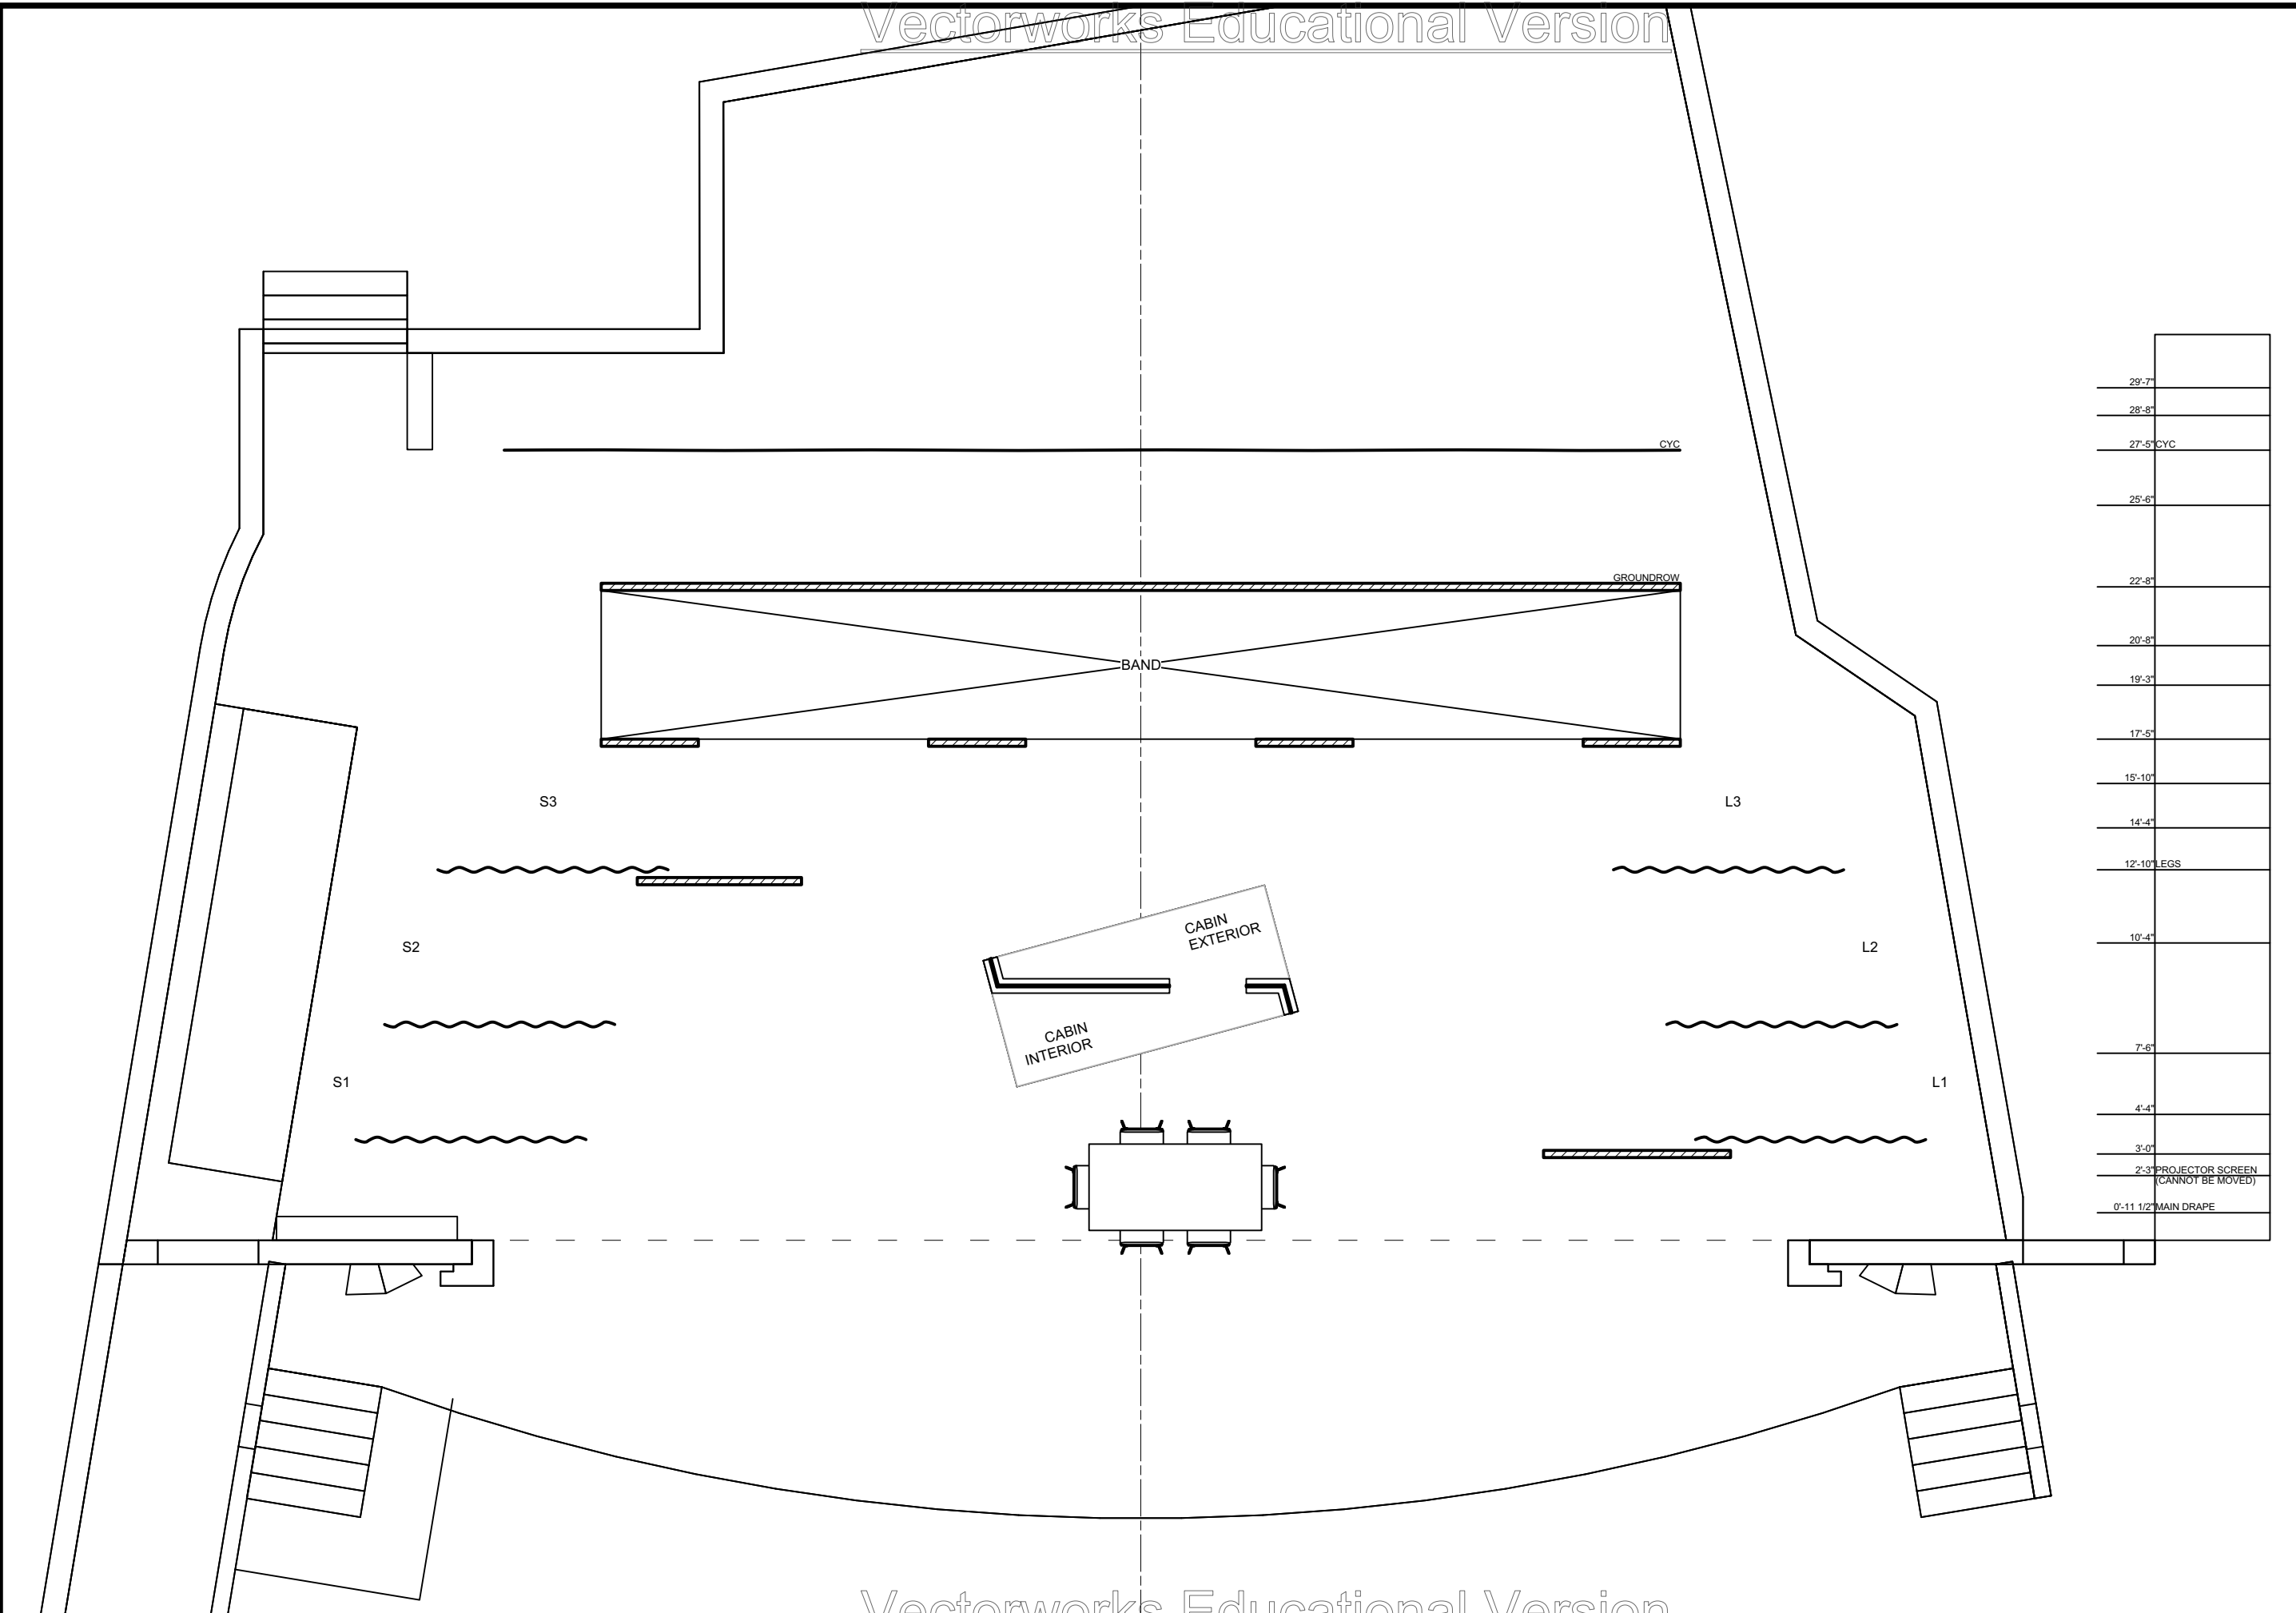

**Disclaimer:**  
 Drawings are only meant only to illustrate ideas and are not to be used for construction. All structural elements shown in the design must be evaluated and stamped by a certified technical director before construction. The designer does not assume any liability for structural integrity in the designs. The company selected to build the designs will assume all liability to its structural integrity and related consumer, crew and performer safety.

*Brandon M. Newton*  
 Scenic Designer Signature

Venue: **Actor's Playhouse**

Stage: **Mainstage Theatre**

Director: **David Arisco**

Technical Director: **Gene Seyffer**

Show Title: **BRIGHT STAR**

Sheet Title: **A1S6 - Murphy Home (1923)**

Date: **02 Mar 2023**


Scale: **1/4" = 1'-0"**

Designer: **Brandon M. Newton**

Drawn By: **Brandon M. Newton**

Sheet Number: **GP-6**

of: **0**

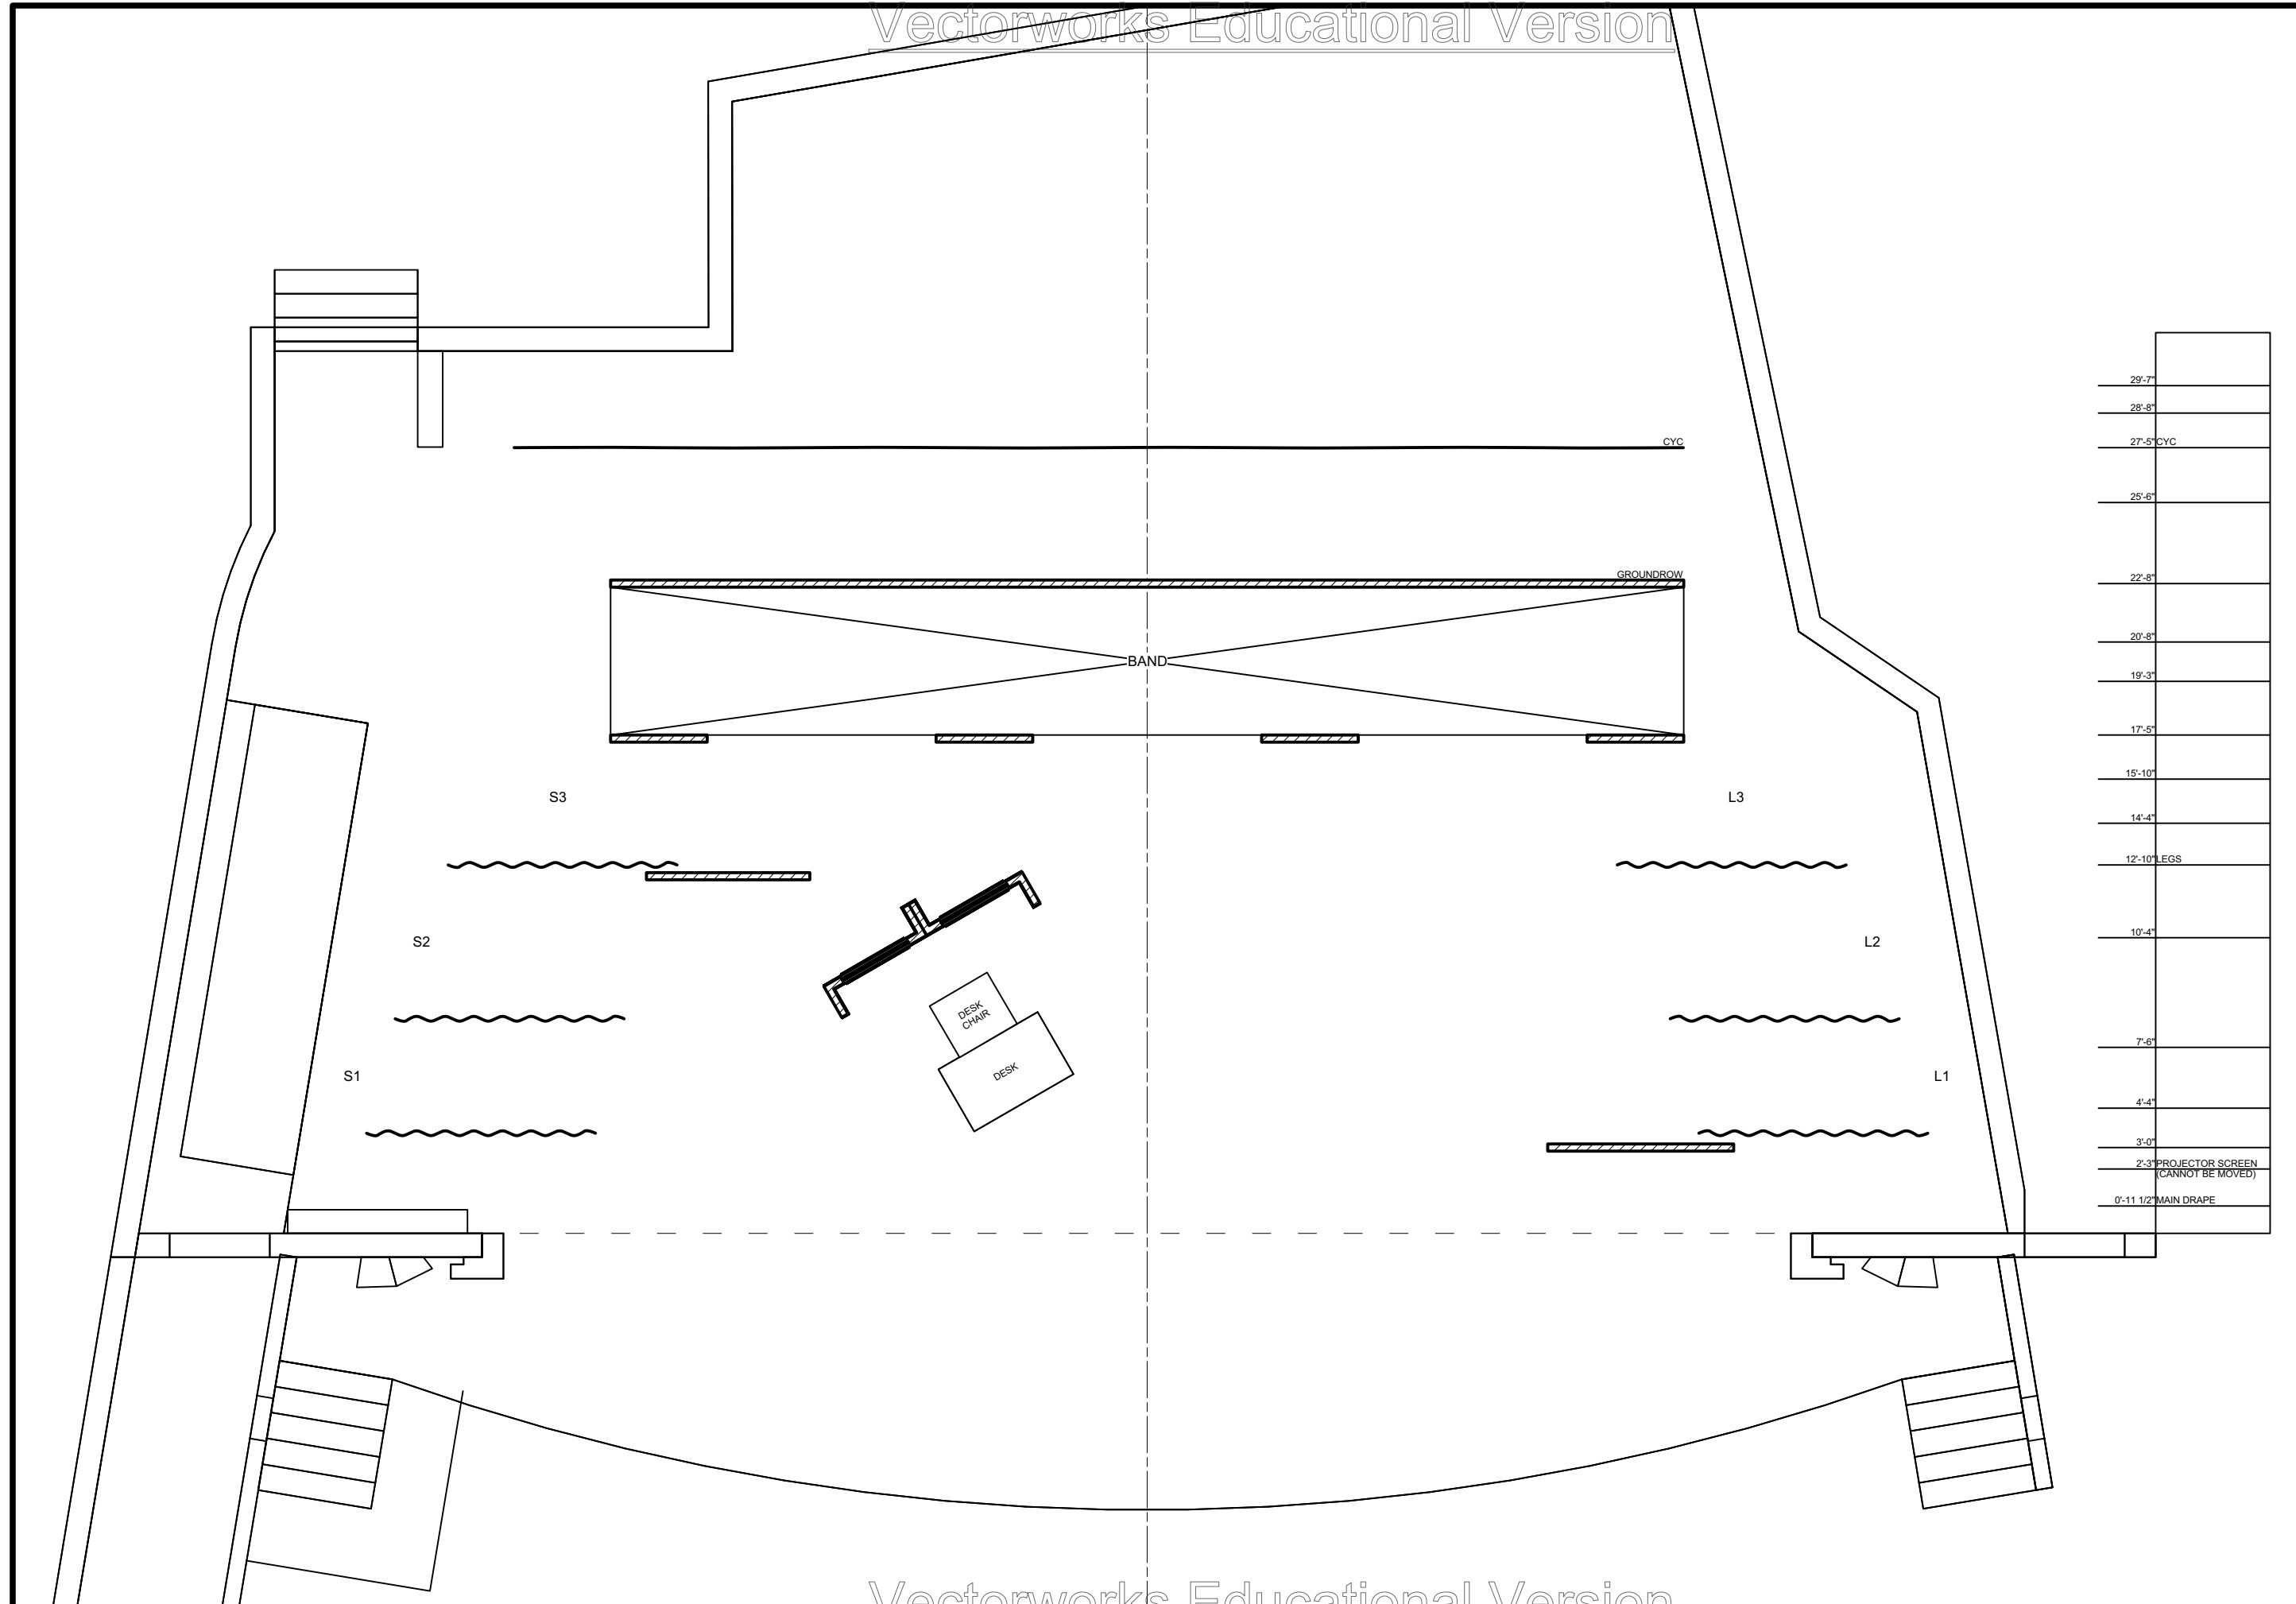

**Disclaimer:**  
 Drawings are only meant only to illustrate ideas and are not to be used for construction. All structural elements shown in the design must be evaluated and stamped by a certified technical director before construction. The designer does not assume any liability for structural integrity in the designs. The company selected to build the designs will assume all liability to its structural integrity and related consumer, crew and performer safety.

*Brandon M. Newton*  
 Scenic Designer Signature

Venue: **Actor's Playhouse**

Stage: **Mainstage Theatre**

Director: **David Arisco**

Technical Director: **Gene Seyffer**

Show Title: **BRIGHT STAR**

Sheet Title: **A1S7 - Mayor Office (1923)**


Date: **02 Mar 2023**

Designer: **Brandon M. Newton**

Scale: **1/4" = 1'-0"**

Drawn By: **Brandon M. Newton**

Sheet Number: **GP-7** of: **0**

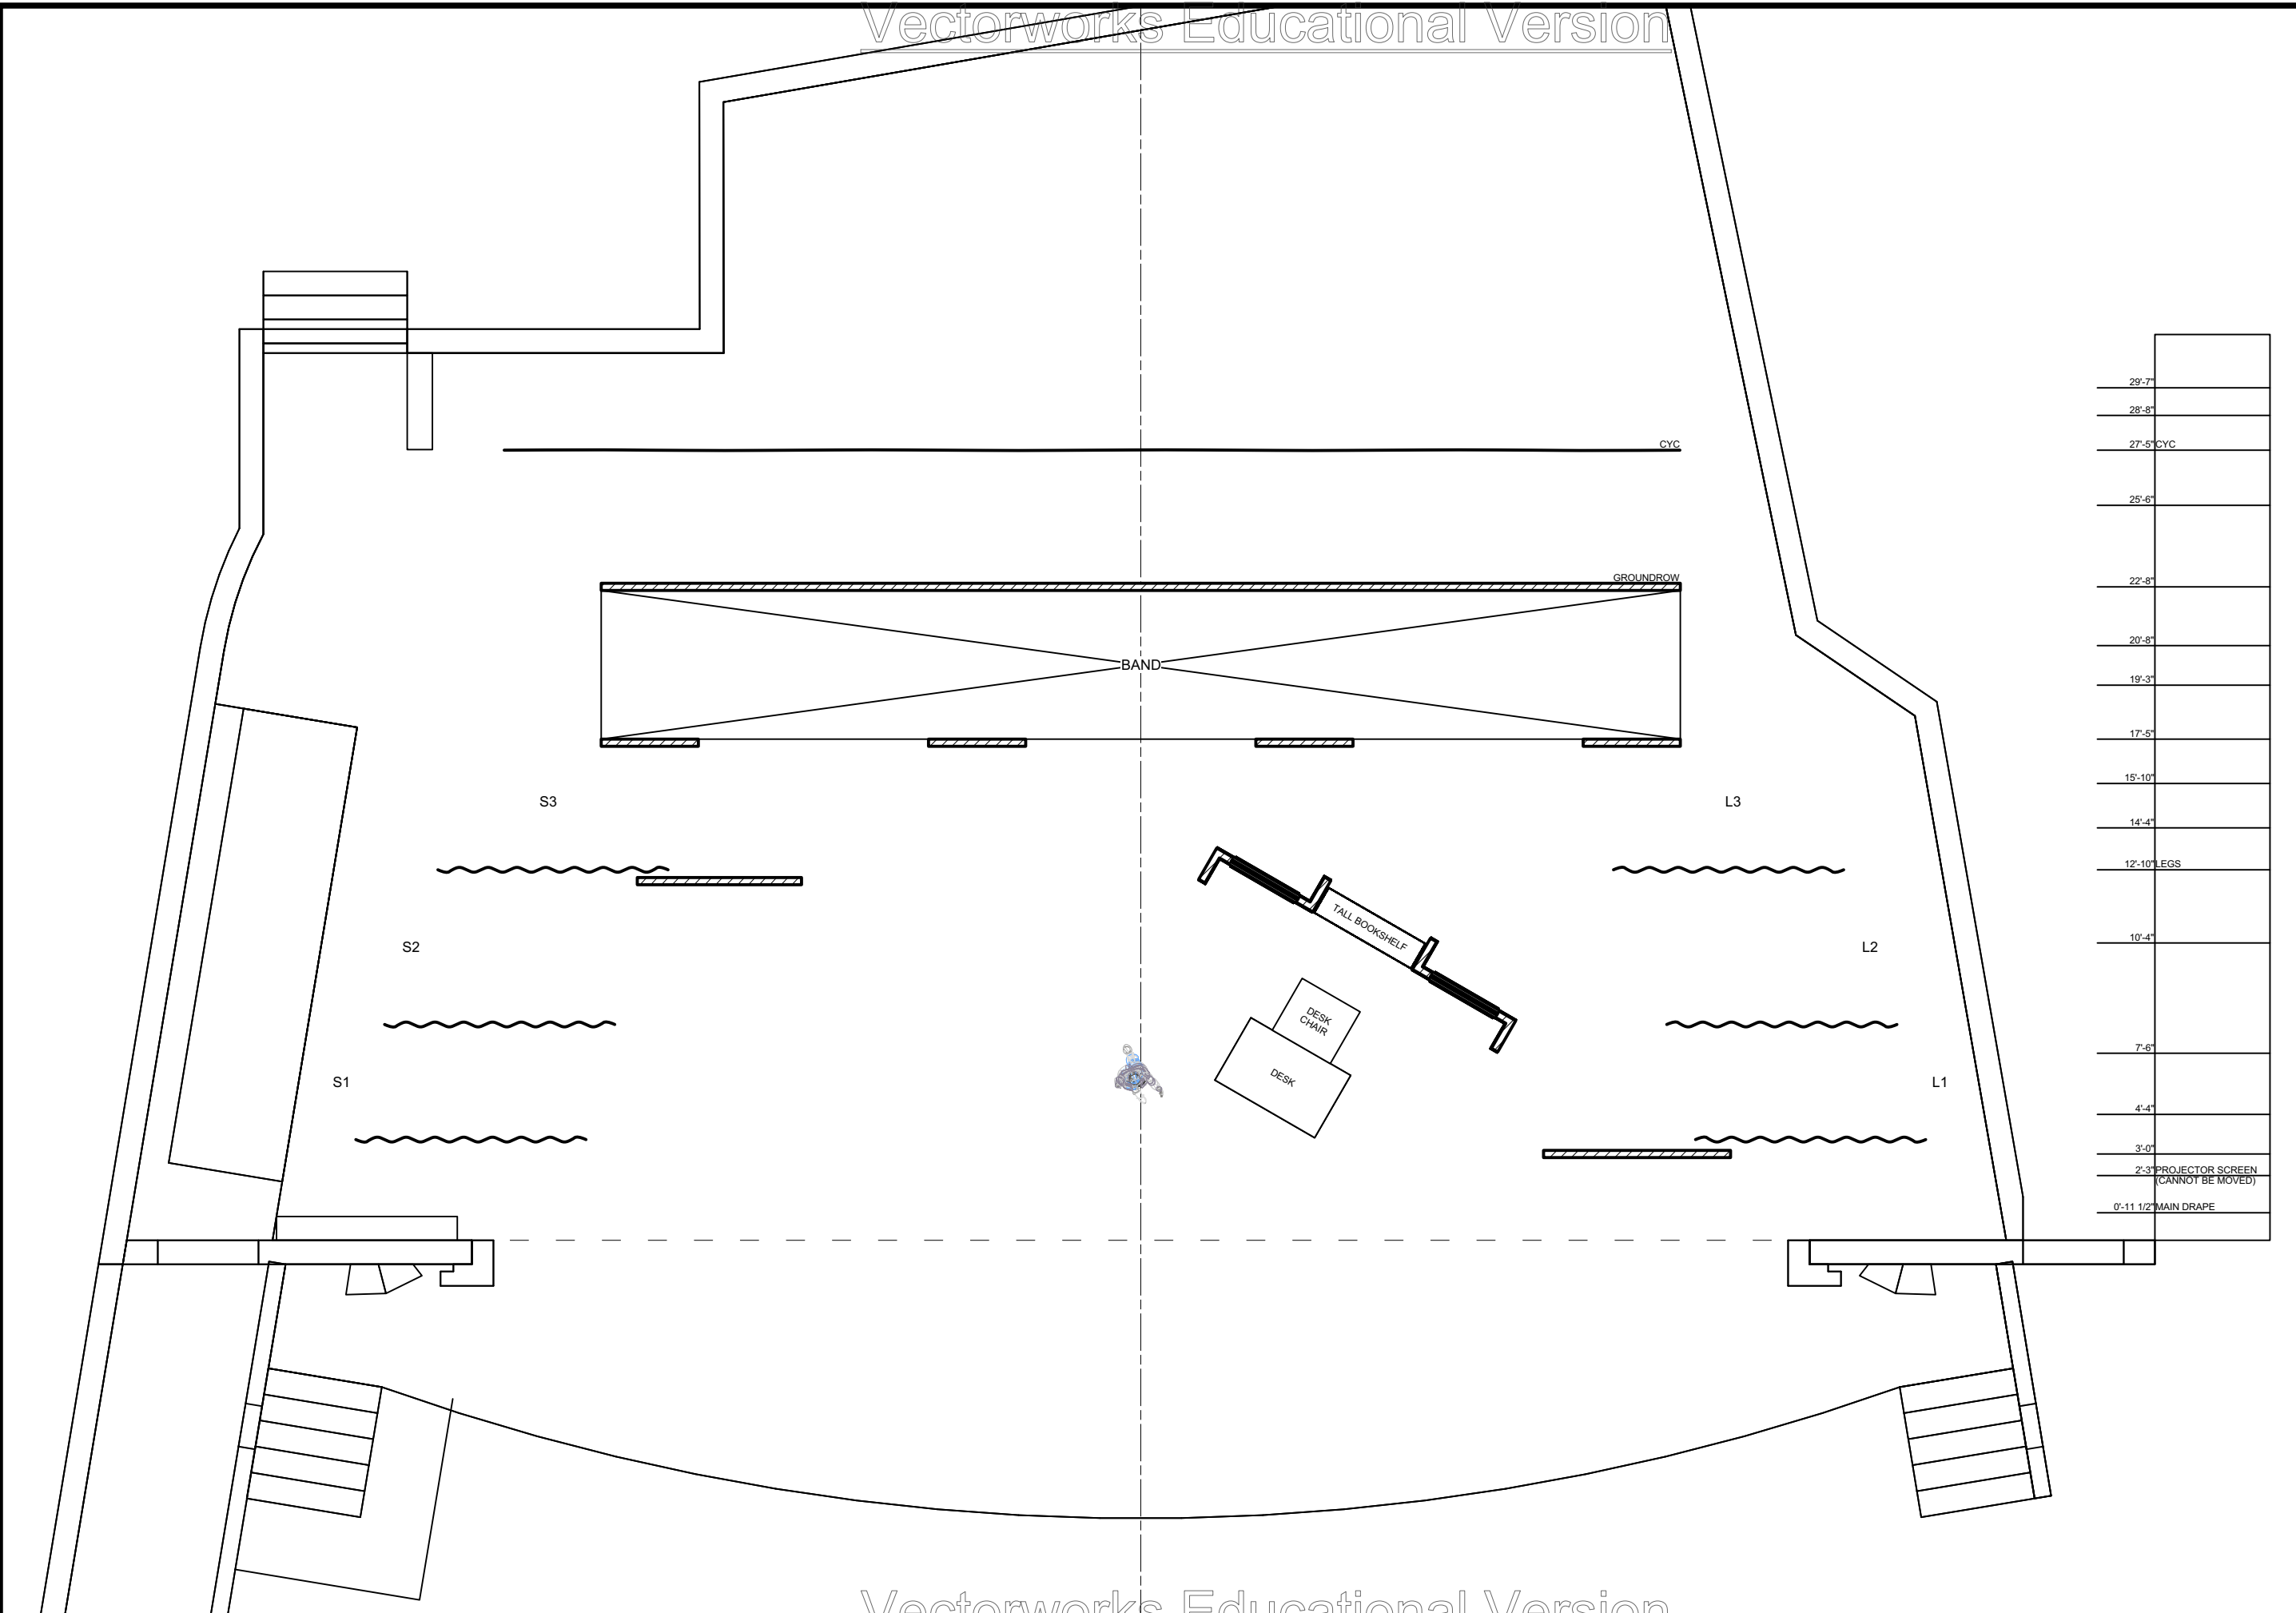

29'-7"	
28'-8"	
27'-5" CYC	
25'-6"	
22'-8"	
20'-8"	
19'-3"	
17'-5"	
15'-10"	
14'-4"	
12'-10" LEGS	
10'-4"	
7'-6"	
4'-4"	
3'-0"	
2'-3" PROJECTOR SCREEN (CANNOT BE MOVED)	
0'-11 1/2" MAIN DRAPE	


**Disclaimer:**  
 Drawings are only meant only to illustrate ideas and are not to be used for construction. All structural elements shown in the design must be evaluated and stamped by a certified technical director before construction. The designer does not assume any liability for structural integrity in the designs. The company selected to build the designs will assume all liability to its structural integrity and related consumer, crew and performer safety.

*Brandon M. Newton*  
 Scenic Designer Signature

Sheet Title: <b>A1S8 - Alice's Office (1945)</b>	Scale: <b>1/4" = 1'-0"</b>	Drawn By: <b>Brandon M. Newton</b>
Date: <b>02 Mar 2023</b>		Designer: <b>Brandon M. Newton</b>
Sheet Number: <b>GP-8</b>		

Venue: <b>Actor's Playhouse</b>	Director: <b>David Arisco</b>	Technical Director: <b>Gene Seyffer</b>
Show Title: <b>BRIGHT STAR</b>		



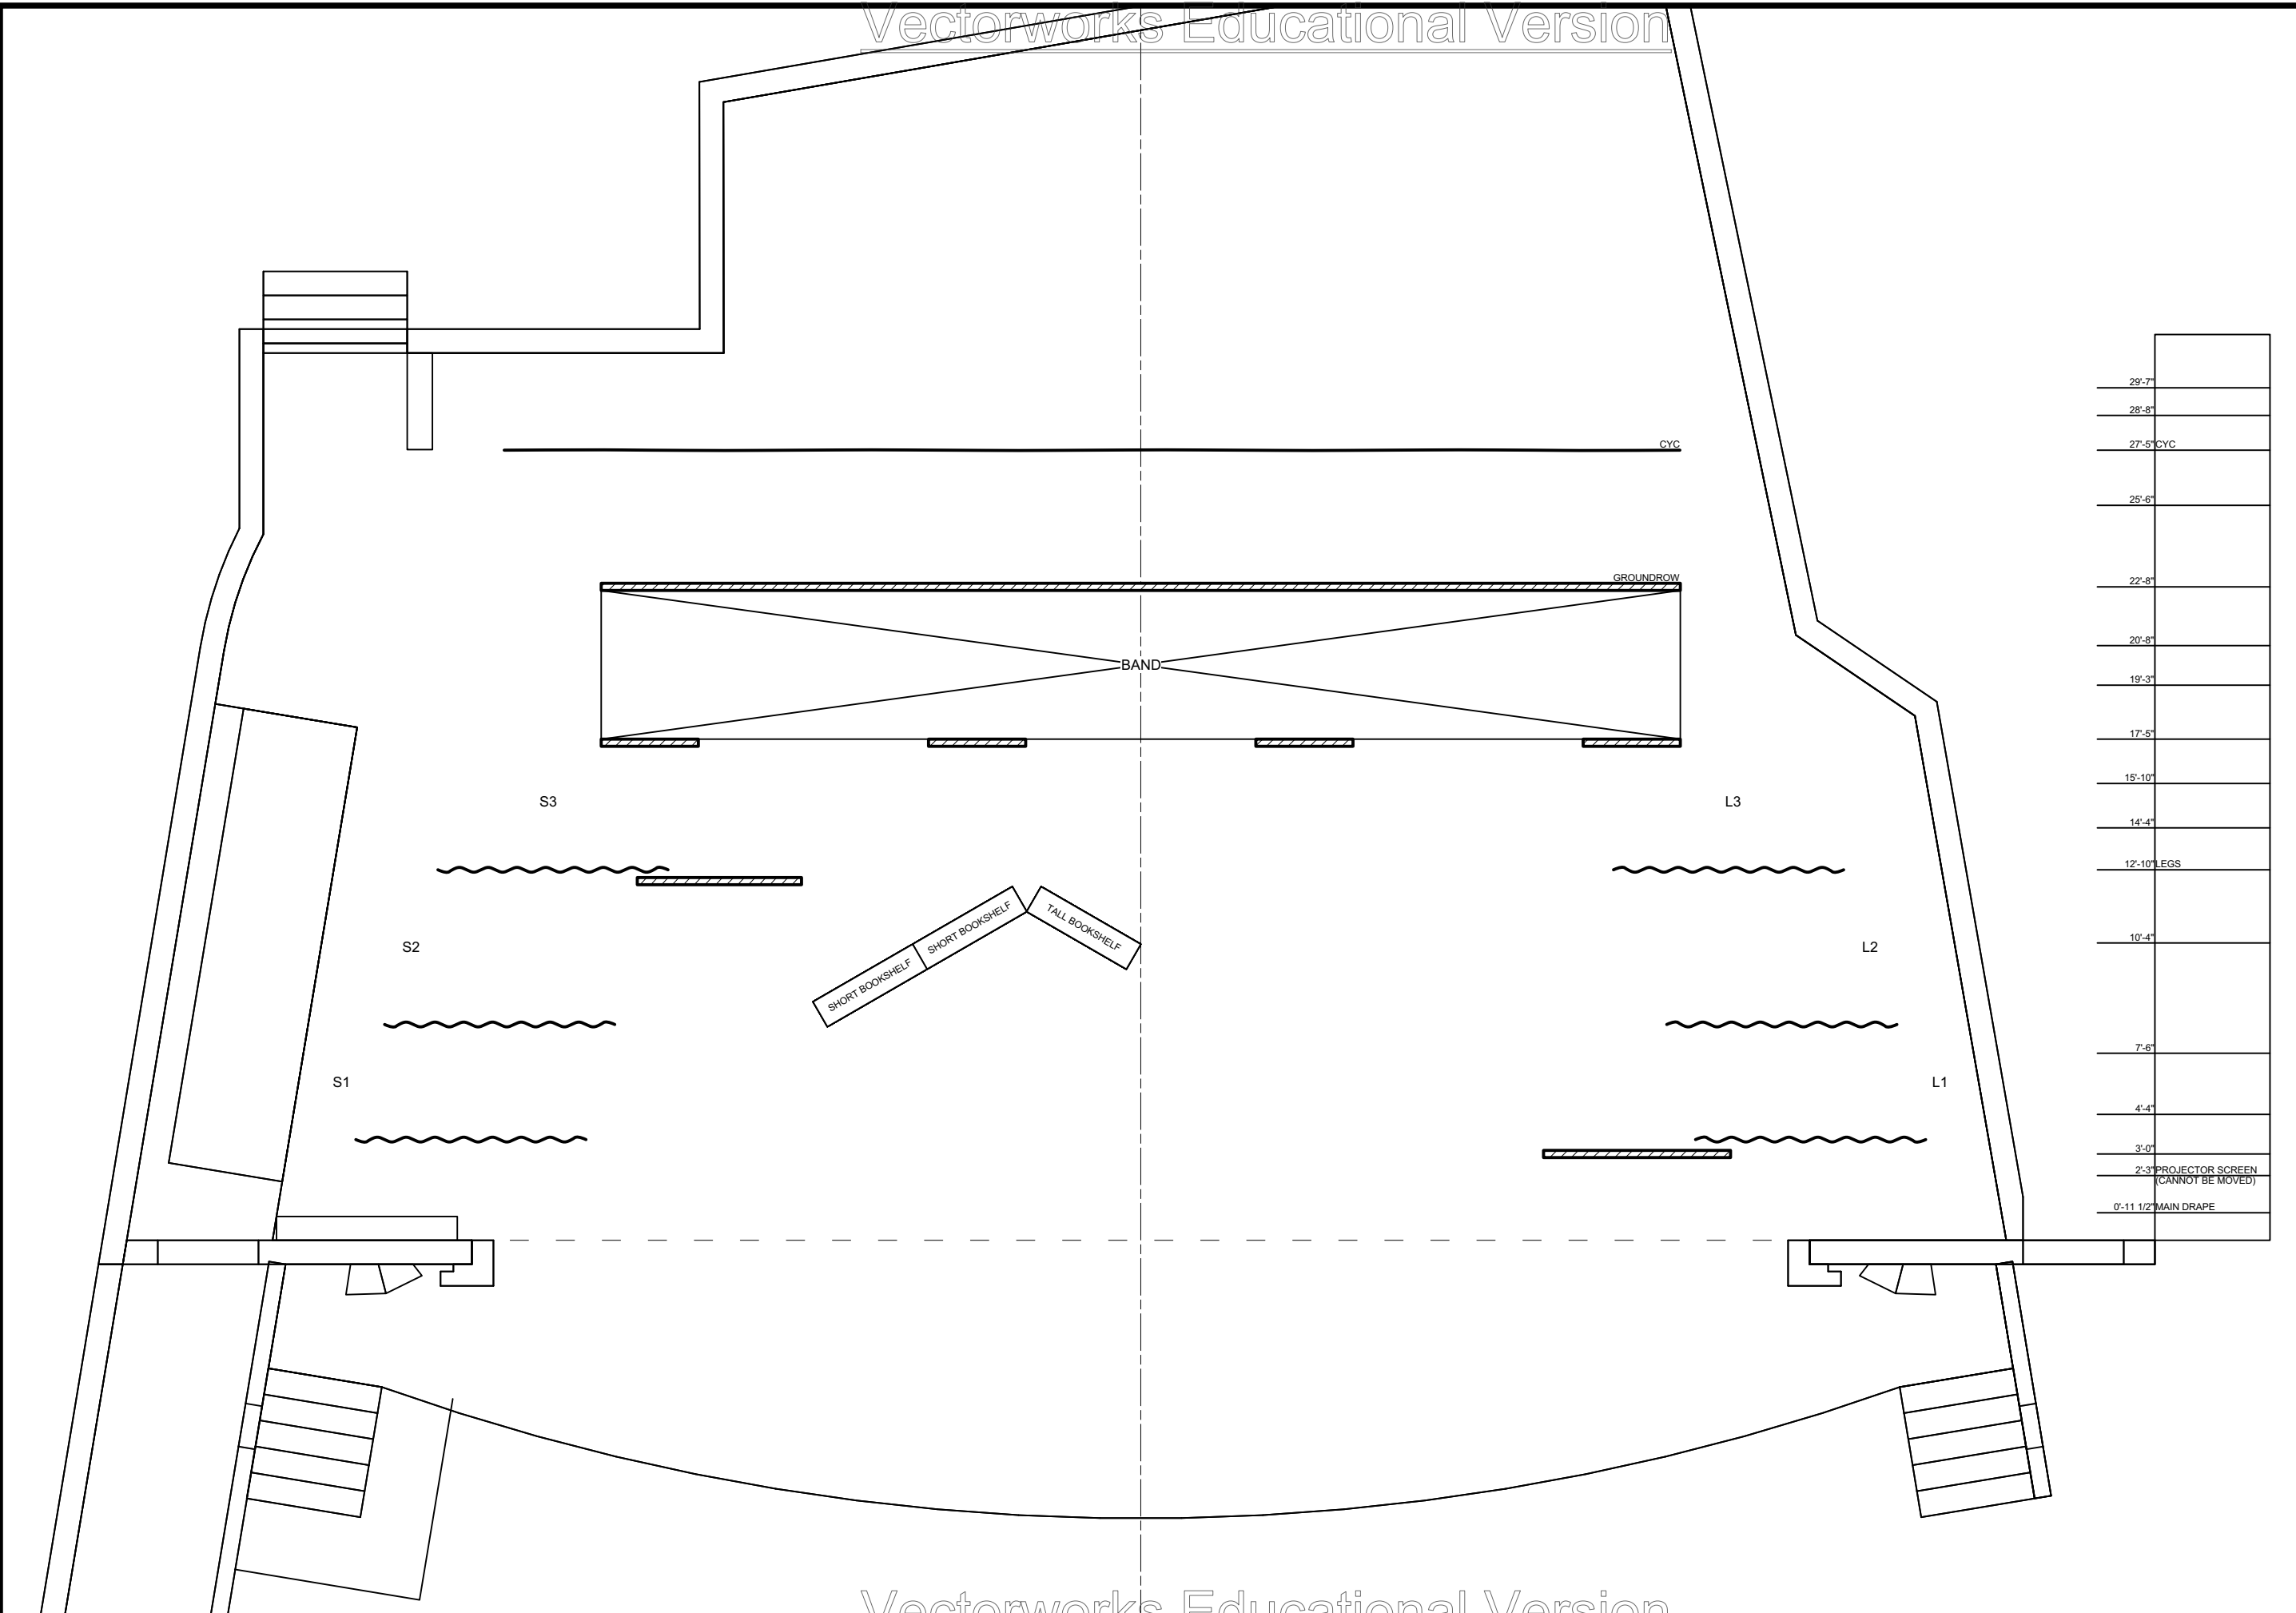


29'-7"	
28'-8"	
27'-5" CYC	
25'-6"	
22'-8"	
20'-8"	
19'-3"	
17'-5"	
15'-10"	
14'-4"	
12'-10" LEGS	
10'-4"	
7'-6"	
4'-4"	
3'-0"	
2'-3" PROJECTOR SCREEN (CANNOT BE MOVED)	
0'-11 1/2" MAIN DRAPE	

**Disclaimer:**  
 Drawings are only meant only to illustrate ideas and are not to be used as a basis for construction. All structural elements shown in the design must be evaluated and stamped by a certified technical director before construction. The designer does not assume any liability for structural integrity in the designs. The company selected to build the designs will assume all liability to its structural integrity and related consumer, crew and performer safety.

*Brandon M. Newton*  
 Scenic Designer Signature

Sheet Title: <b>A1S9 - Margo's Bookshop (1945)</b>	Scale: <b>1/4" = 1'-0"</b>	Drawn By: <b>Brandon M. Newton</b>
Date: <b>02 Mar 2023</b>		Designer: <b>Brandon M. Newton</b>
Venue: <b>Actor's Playhouse</b>		Technical Director: <b>Gene Seyffer</b>
Show Title: <b>BRIGHT STAR</b>		Director: <b>David Arisco</b>
Stage: <b>Mainstage Theatre</b>		
Sheet Number: <b>GP-9</b>		of: <b>0</b>

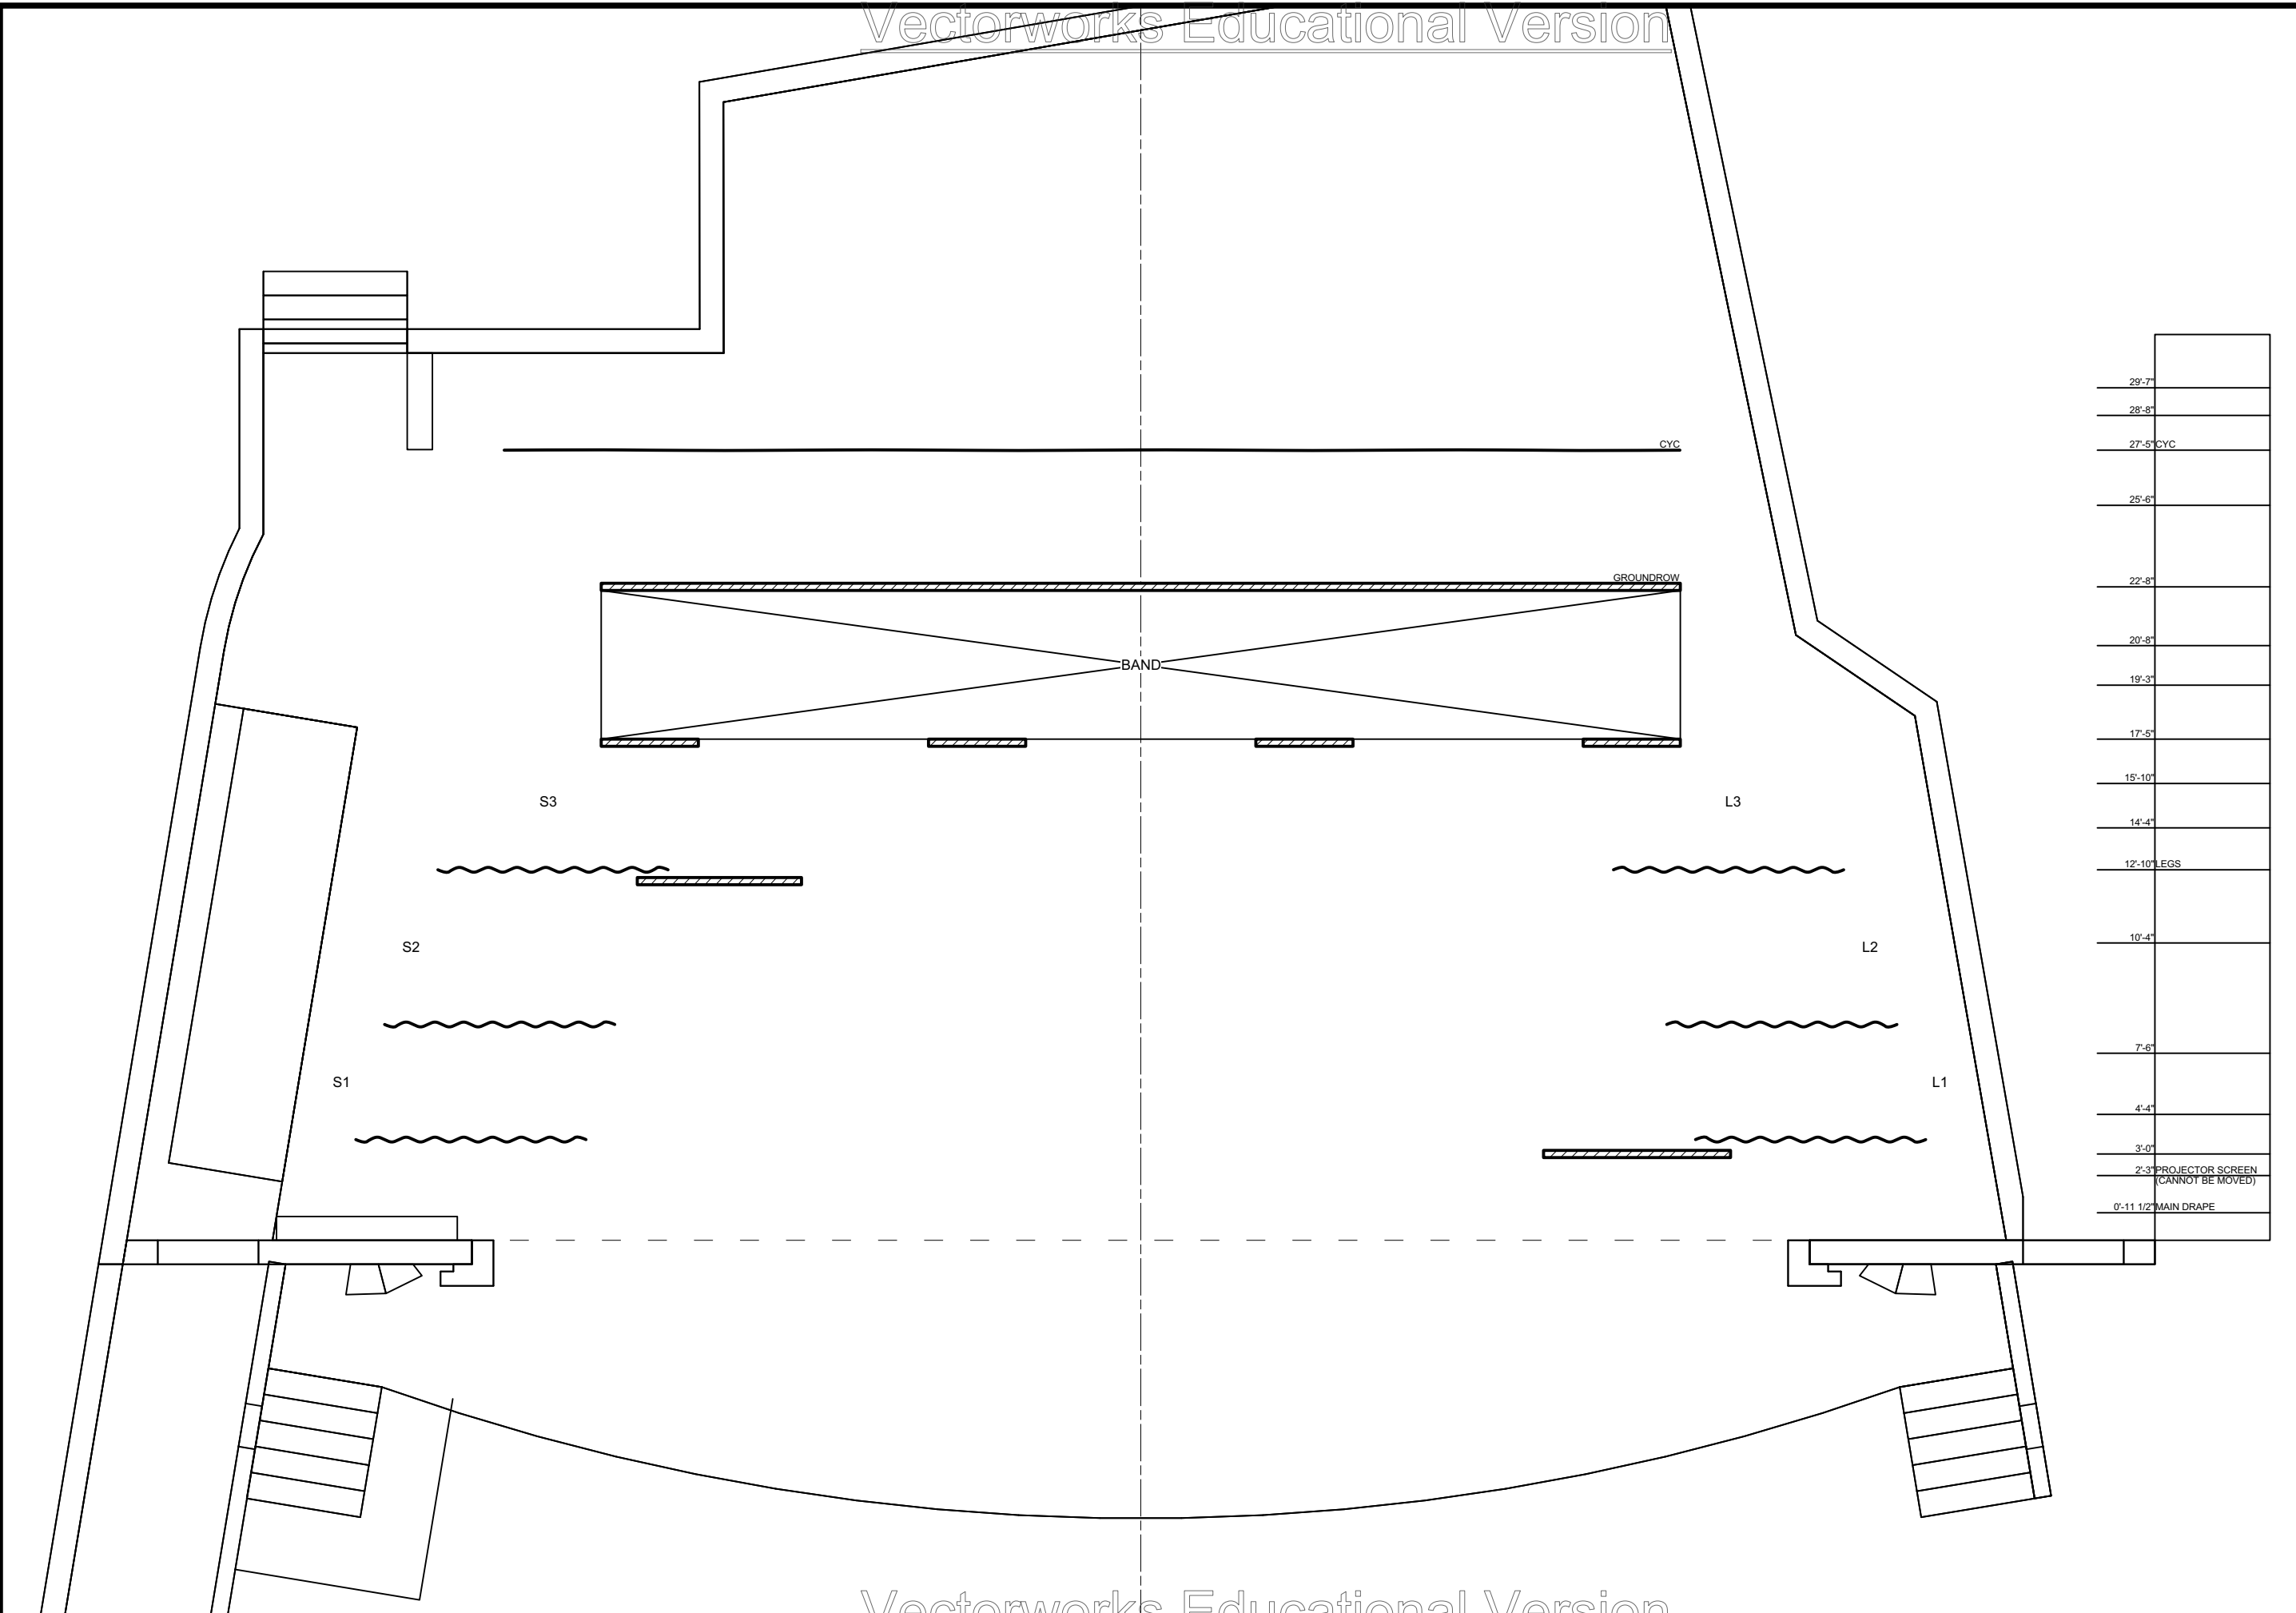


29'-7"	
28'-8"	
27'-5" CYC	
25'-6"	
22'-8"	
20'-8"	
19'-3"	
17'-5"	
15'-10"	
14'-4"	
12'-10" LEGS	
10'-4"	
7'-6"	
4'-4"	
3'-0"	
2'-3" PROJECTOR SCREEN (CANNOT BE MOVED)	
0'-11 1/2" MAIN DRAPE	

**Disclaimer:**  
 Drawings are only meant only to illustrate ideas and are not to be used as a basis for construction. All structural elements shown in the design must be evaluated and stamped by a certified technical director before construction. The designer does not assume any liability for structural integrity in the designs. The company selected to build the designs will assume all liability to its structural integrity and related consumer, crew and performer safety.

*Brandon M. Newton*  
 Scenic Designer Signature

Sheet Title: <b>A1S10 - Zebulon Park (1923)</b>	Scale: <b>1/4" = 1'-0"</b>	Drawn By: <b>Brandon M. Newton</b>
Date: <b>02 Mar 2023</b>		Designer: <b>Brandon M. Newton</b>
Sheet Number: <b>GP-10</b>		of: <b>0</b>

Venue: <b>Actor's Playhouse</b>	Director: <b>David Arisco</b>	Technical Director: <b>Gene Seyffer</b>
Show Title: <b>BRIGHT STAR</b>		

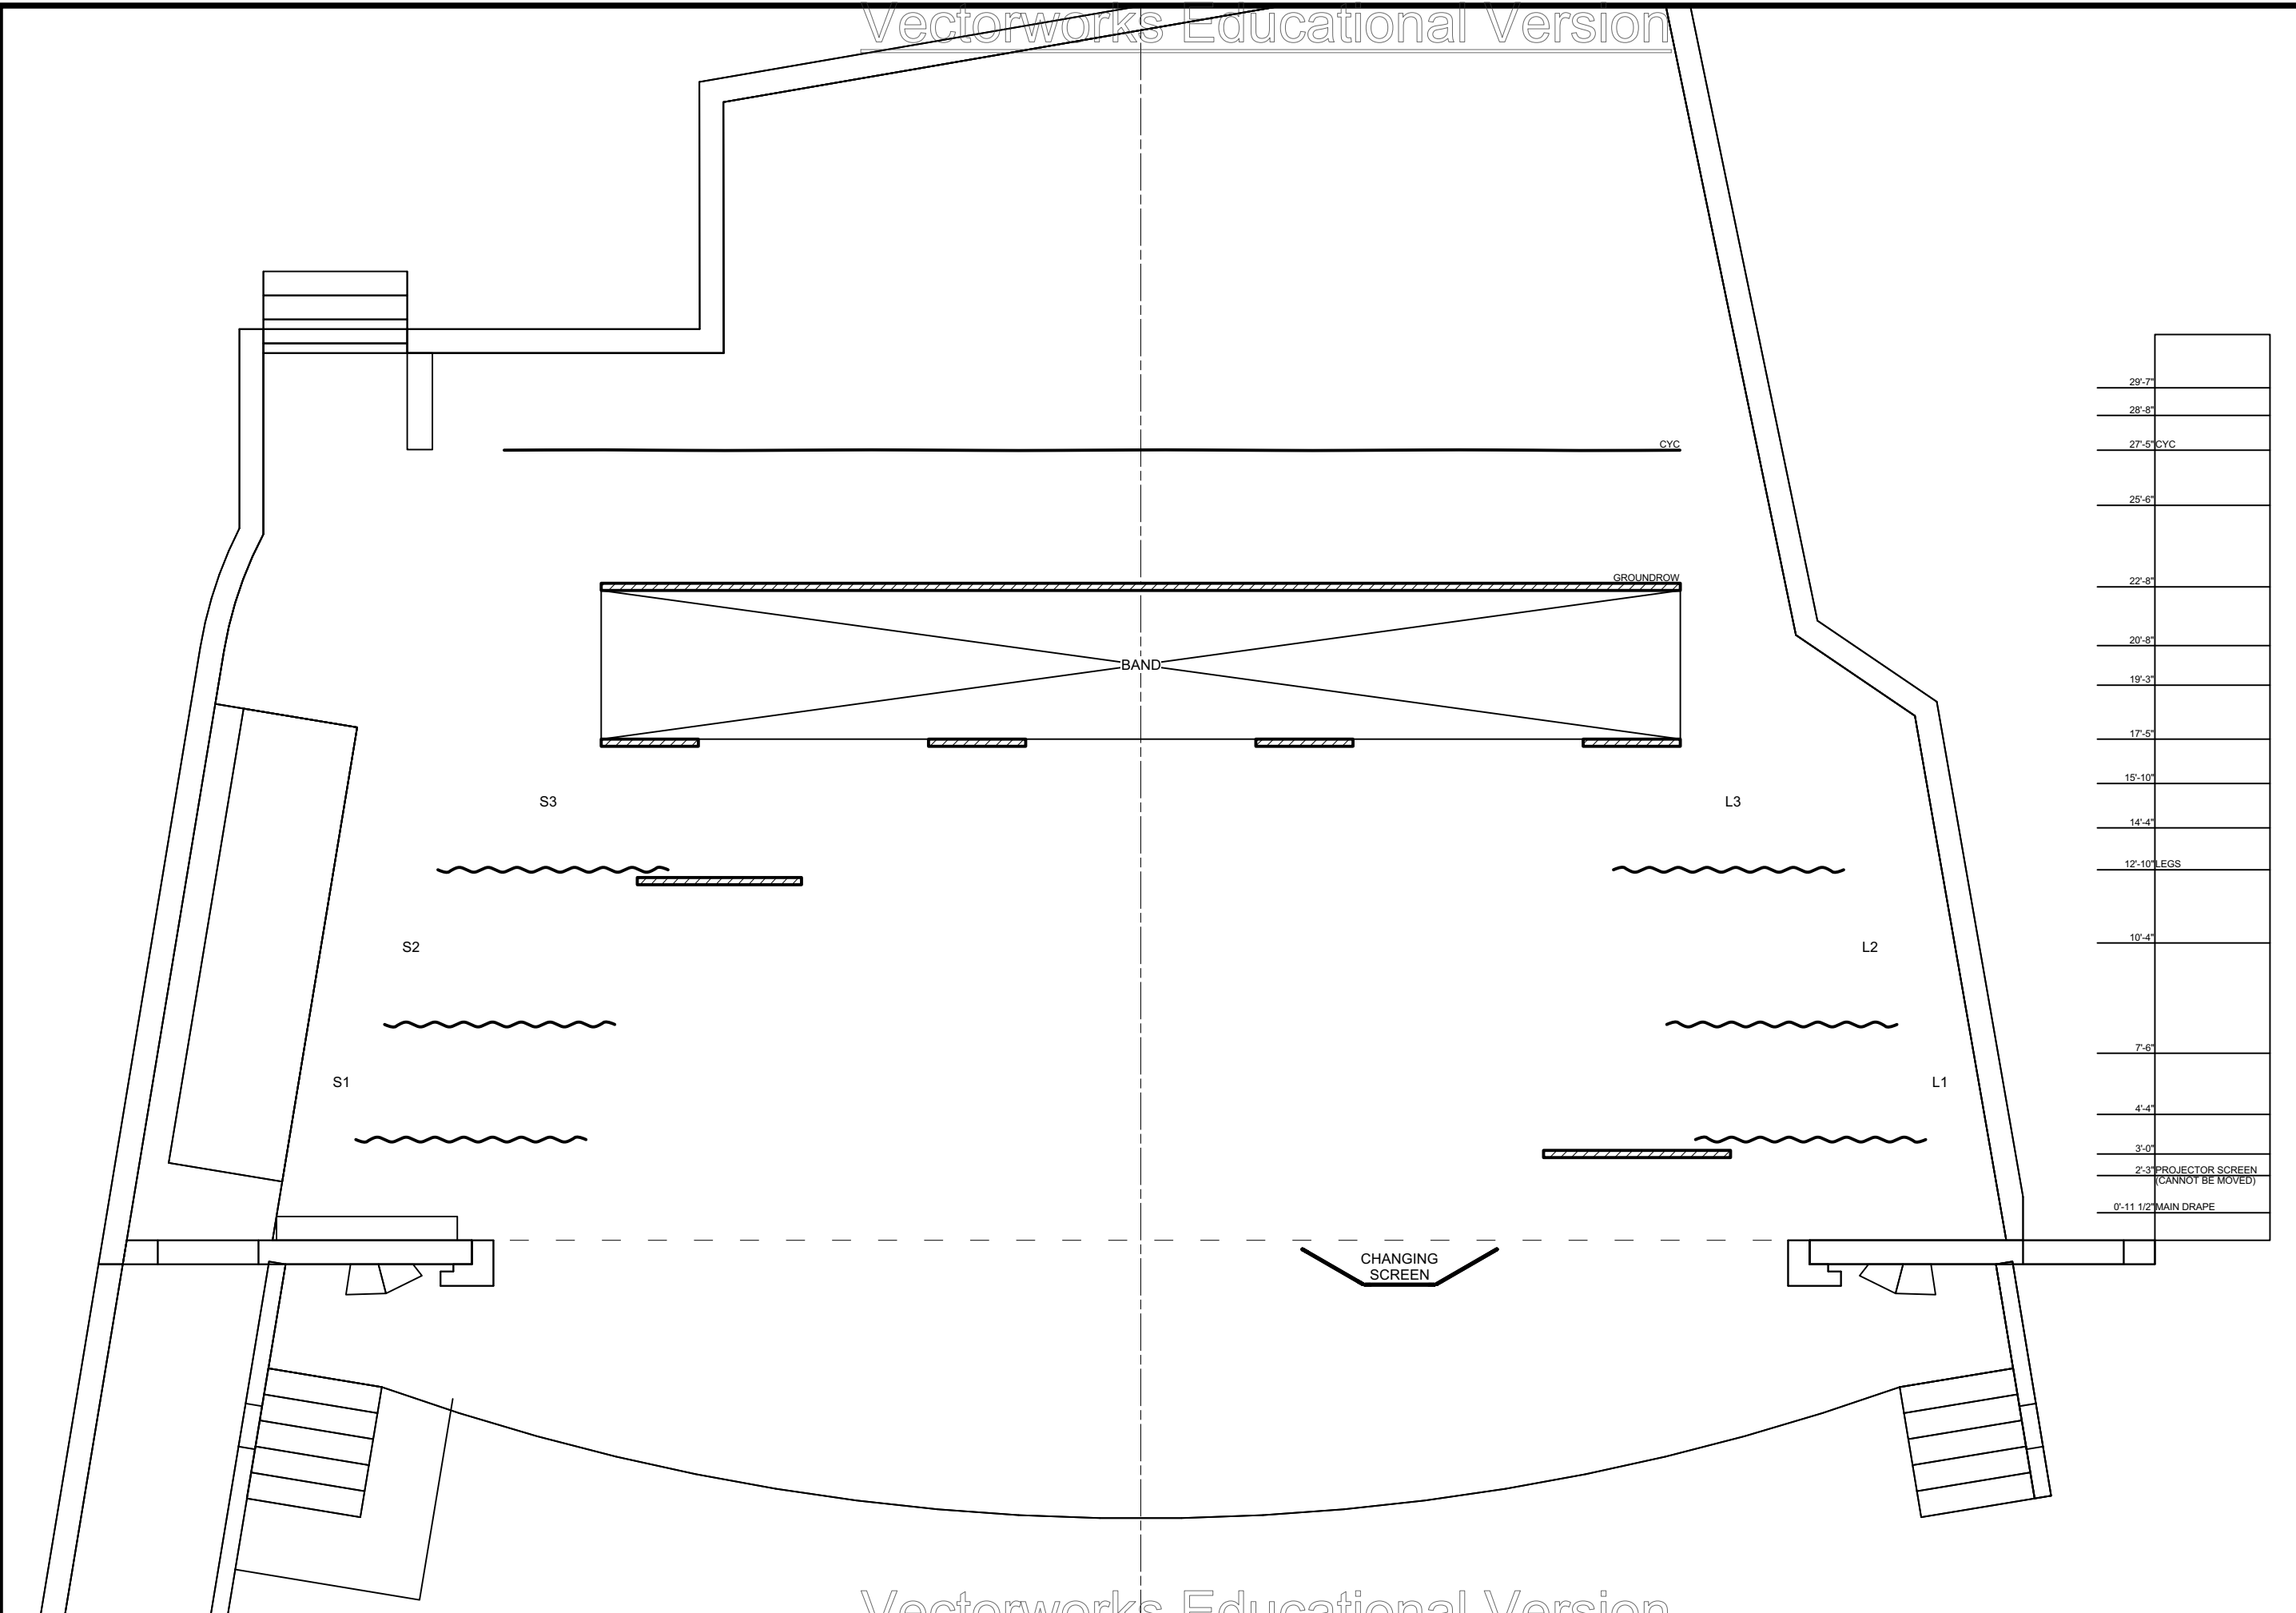

29'-7"	
28'-8"	
27'-5" CYC	
25'-6"	
22'-8"	
20'-8"	
19'-3"	
17'-5"	
15'-10"	
14'-4"	
12'-10" LEGS	
10'-4"	
7'-6"	
4'-4"	
3'-0"	
2'-3" PROJECTOR SCREEN (CANNOT BE MOVED)	
0'-11 1/2" MAIN DRAPE	


**Disclaimer:**  
 Drawings are only meant only to illustrate ideas and are not to be used for construction. All structural elements shown in the design must be evaluated and stamped by a certified technical director before construction. The designer does not assume any liability for structural integrity in the designs. The company selected to build the designs will assume all liability to its structural integrity and related consumer, crew and performer safety.

*Brandon M. Newton*  
 Scenic Designer Signature

Sheet Title: <b>A1S11 - Doctor's Office (1923)</b>	Scale: <b>1/4" = 1'-0"</b>	Drawn By: <b>Brandon M. Newton</b>
Date: <b>02 Mar 2023</b>		Designer: <b>Brandon M. Newton</b>
Sheet Number: <b>GP-11</b>		of: <b>0</b>

Venue: <b>Actor's Playhouse</b>	Director: <b>David Arisco</b>	Technical Director: <b>Gene Seyffer</b>
Stage: <b>Mainstage Theatre</b>		

Show Title:  
**BRIGHT STAR**

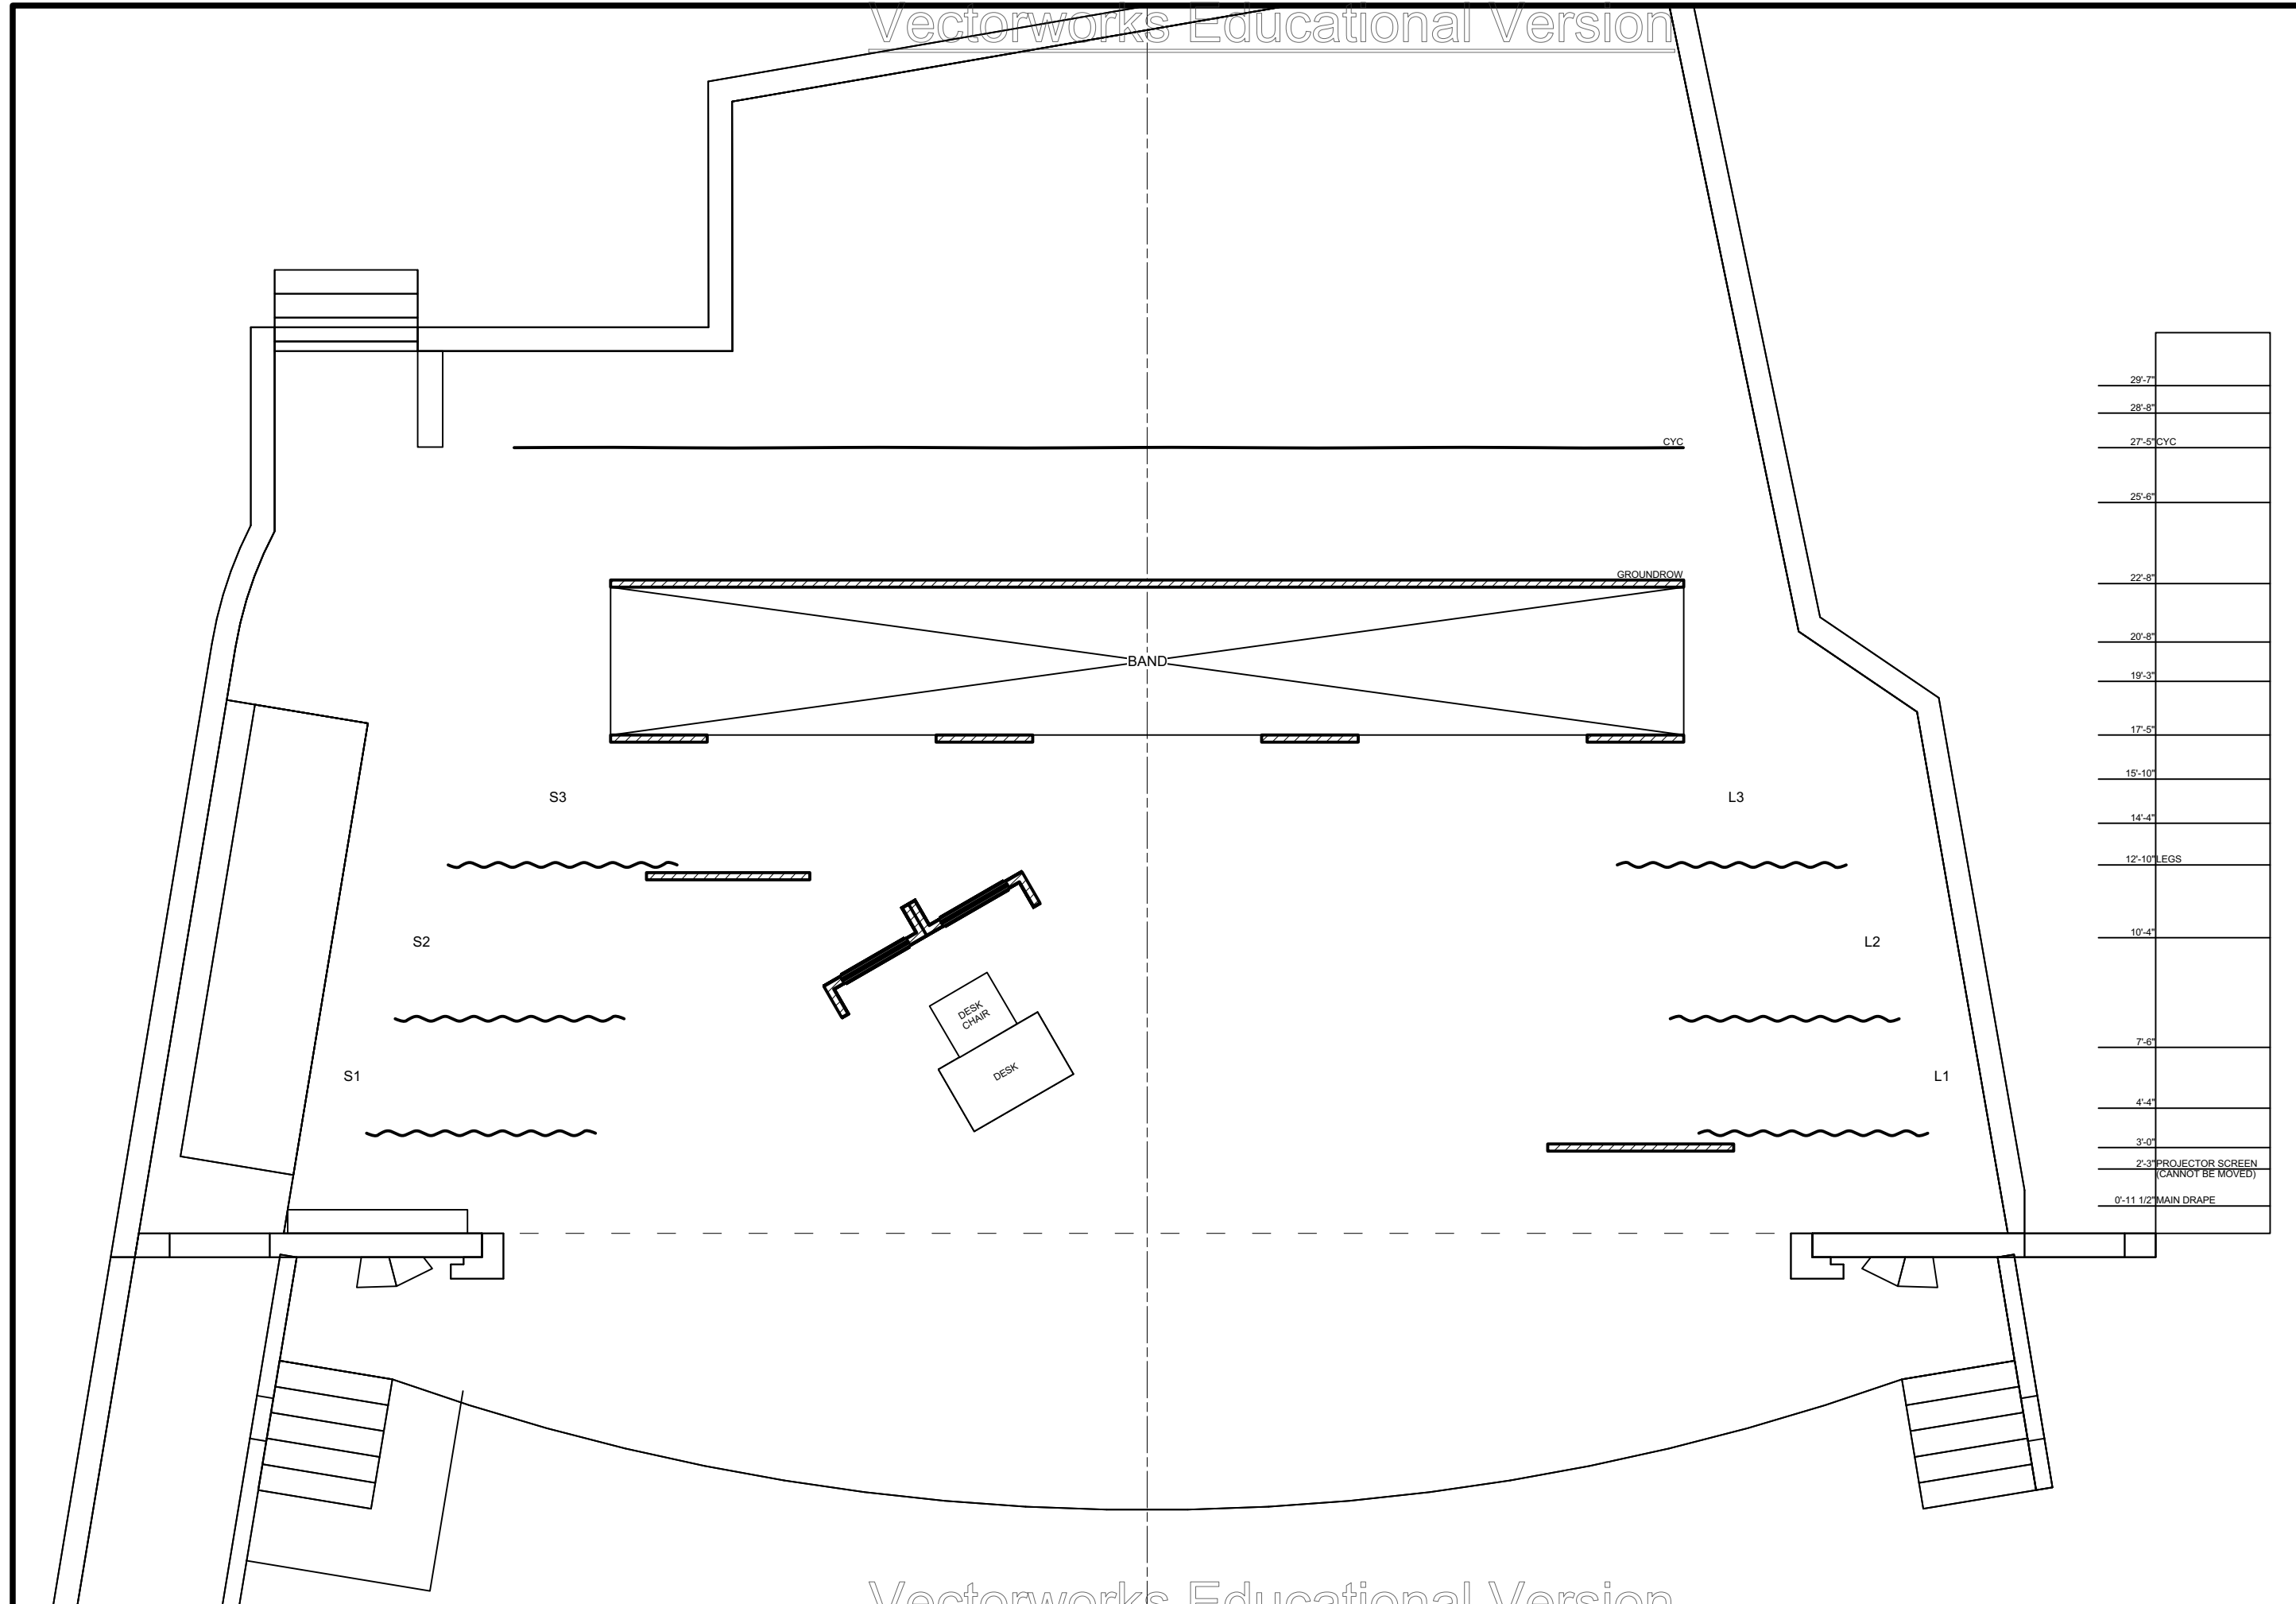

**Disclaimer:**  
 Drawings are only meant only to illustrate ideas and are not to be used for construction. All structural elements shown in the design must be evaluated and stamped by a certified technical director before construction. The designer does not assume any liability for structural integrity in the designs. The company selected to build the designs will assume all liability to its structural integrity and related consumer, crew and performer safety.

*Brandon M. Newton*  
 Scenic Designer Signature

Venue: **Actor's Playhouse**

Stage: **Mainstage Theatre**

Director: **David Arisco**

Technical Director: **Gene Seyffer**

Show Title: **BRIGHT STAR**

Sheet Title: **A1S12 - Mayor's Office (1923)**


Date: **02 Mar 2023**

Scale: **1/4" = 1'-0"**

Designer: **Brandon M. Newton**

Drawn By: **Brandon M. Newton**

Sheet Number: **GP-12** of **0**

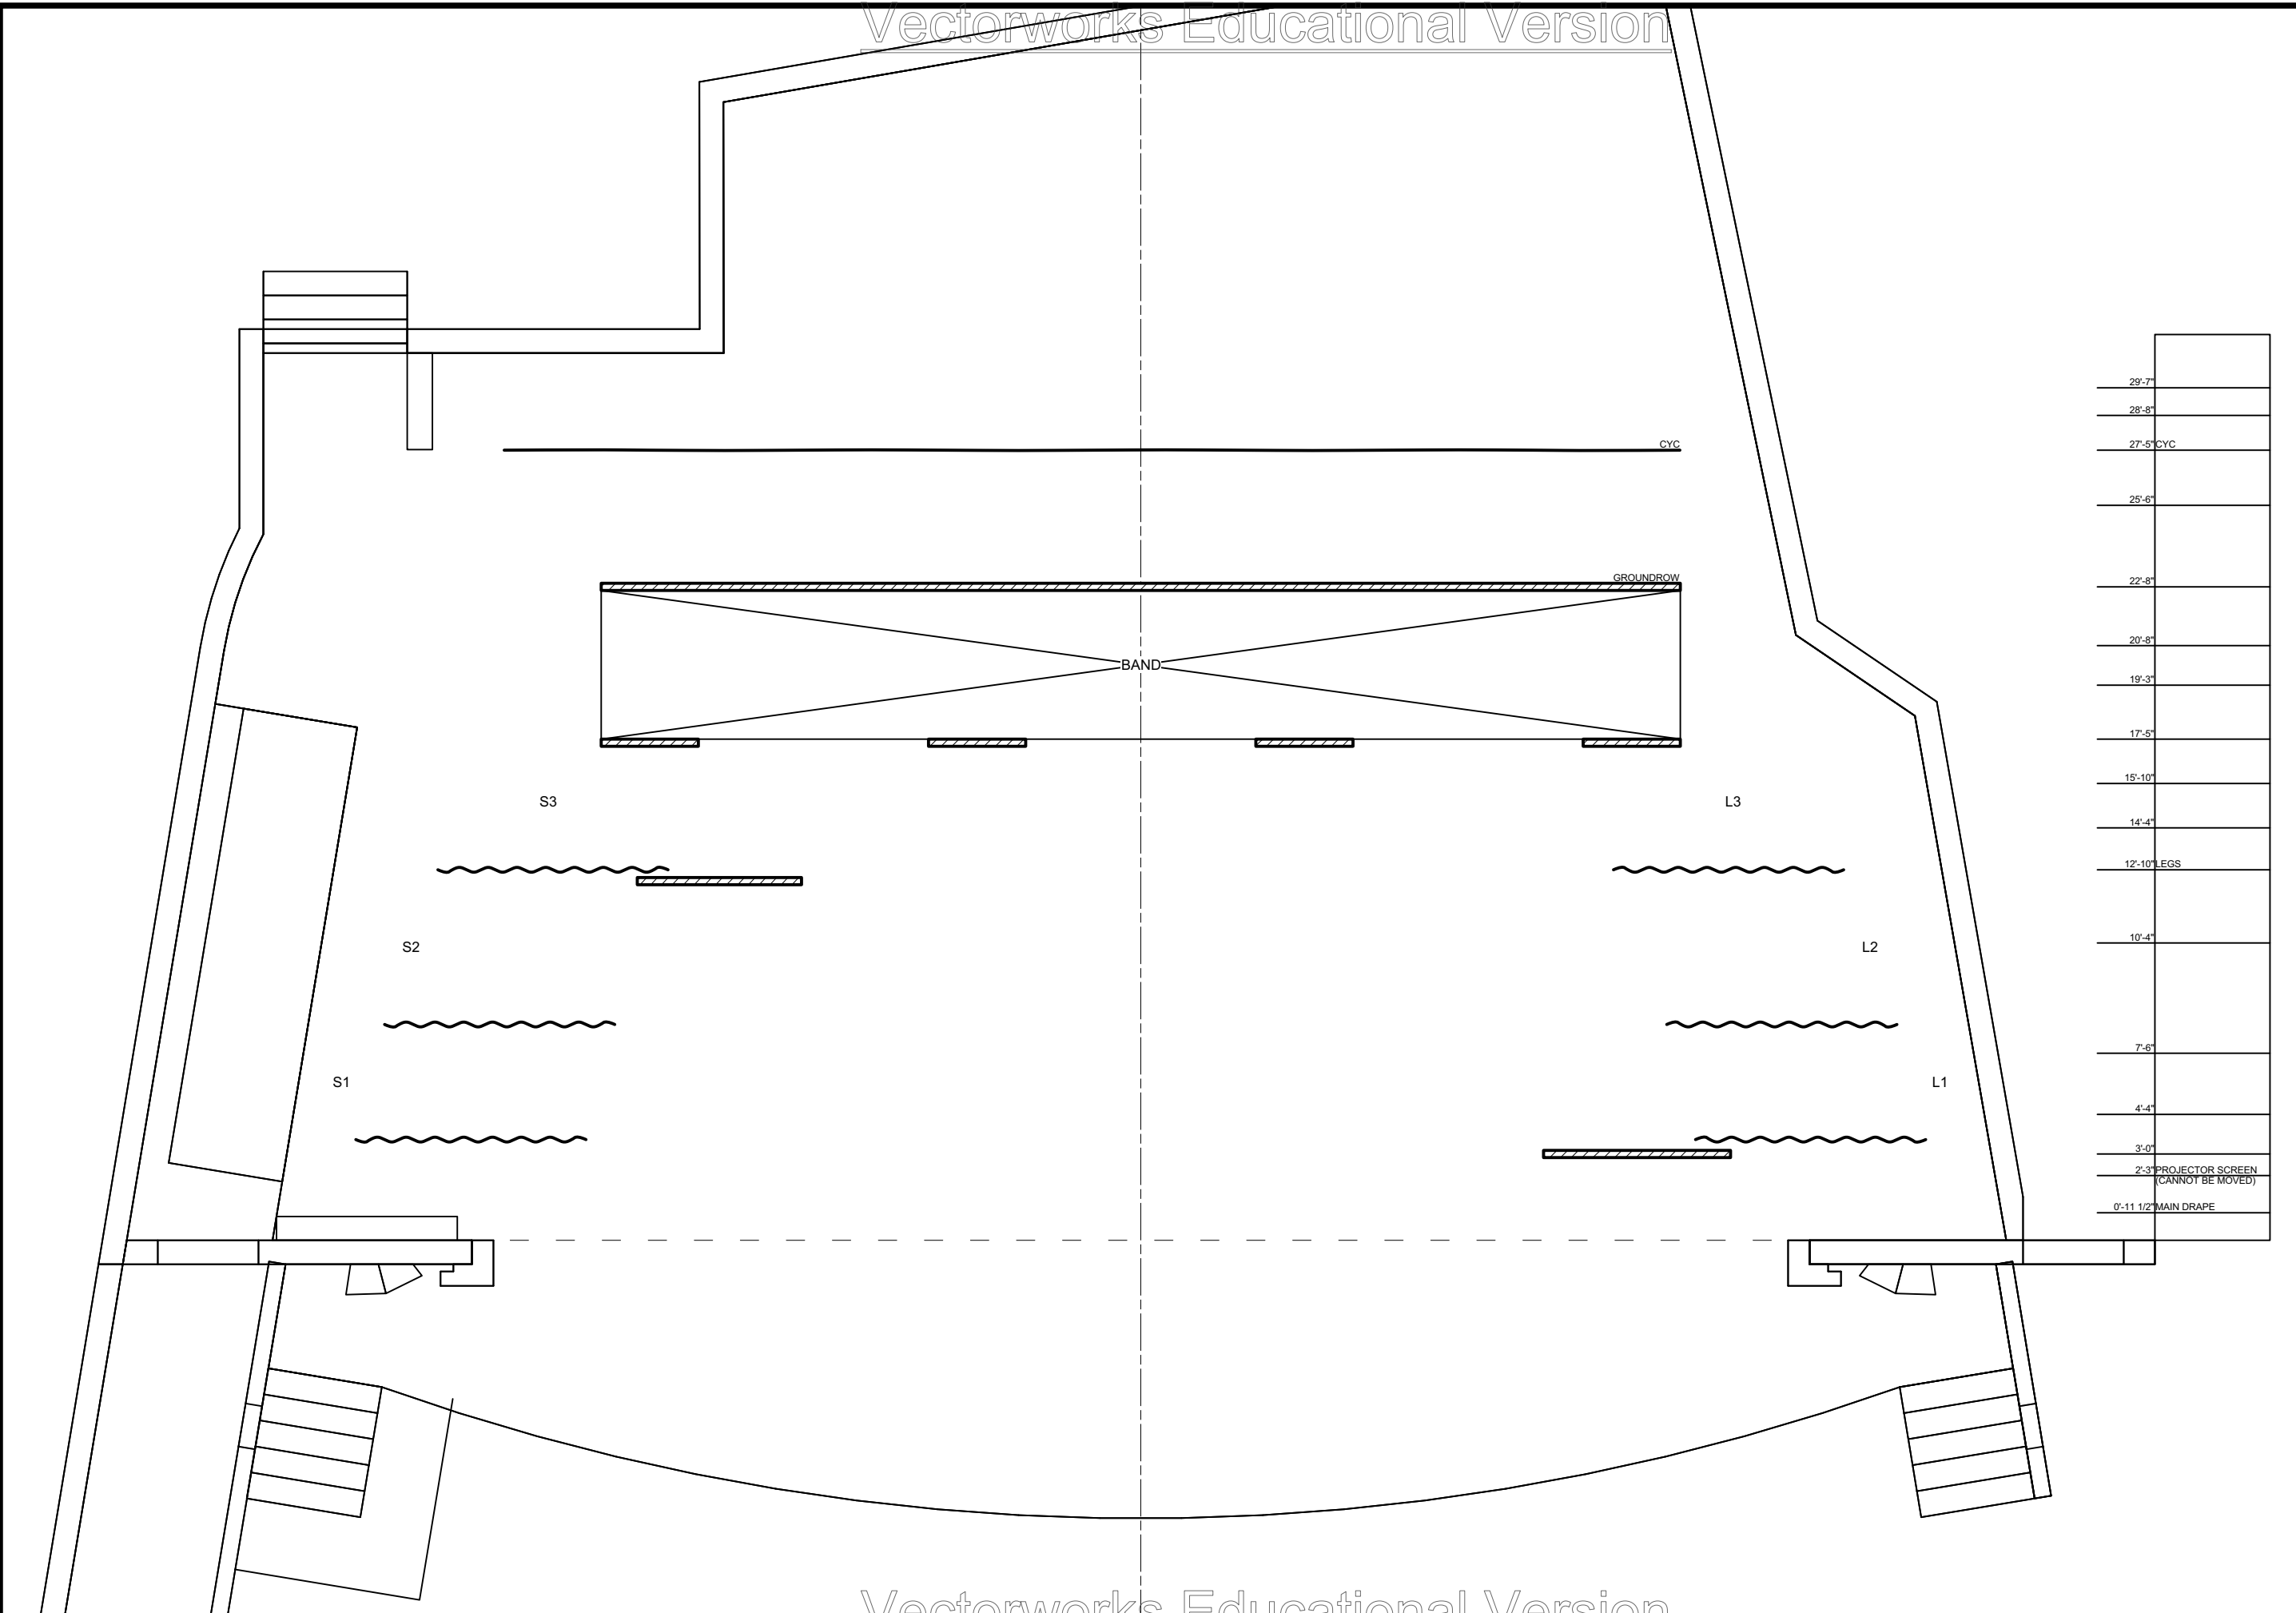

**Disclaimer:**  
 Drawings are only meant only to illustrate ideas and are not to be used as a basis for construction. All structural elements shown in the design must be evaluated and stamped by a certified technical director before construction. The designer does not assume any liability for structural integrity in the designs. The company selected to build the designs will assume all liability to its structural integrity and related consumer, crew and performer safety.

*Brandon M. Newton*  
 Scenic Designer Signature

Venue: **Actor's Playhouse**

Stage: **Mainstage Theatre**

Director: **David Arisco**

Technical Director: **Gene Seyffer**

Show Title: **BRIGHT STAR**

Sheet Title: **A1S13 - Limbo**

Date: **02 Mar 2023**


Scale: **1/4" = 1'-0"**

Designer: **Brandon M. Newton**

Drawn By: **Brandon M. Newton**

Sheet Number: **GP-13**

of: **0**

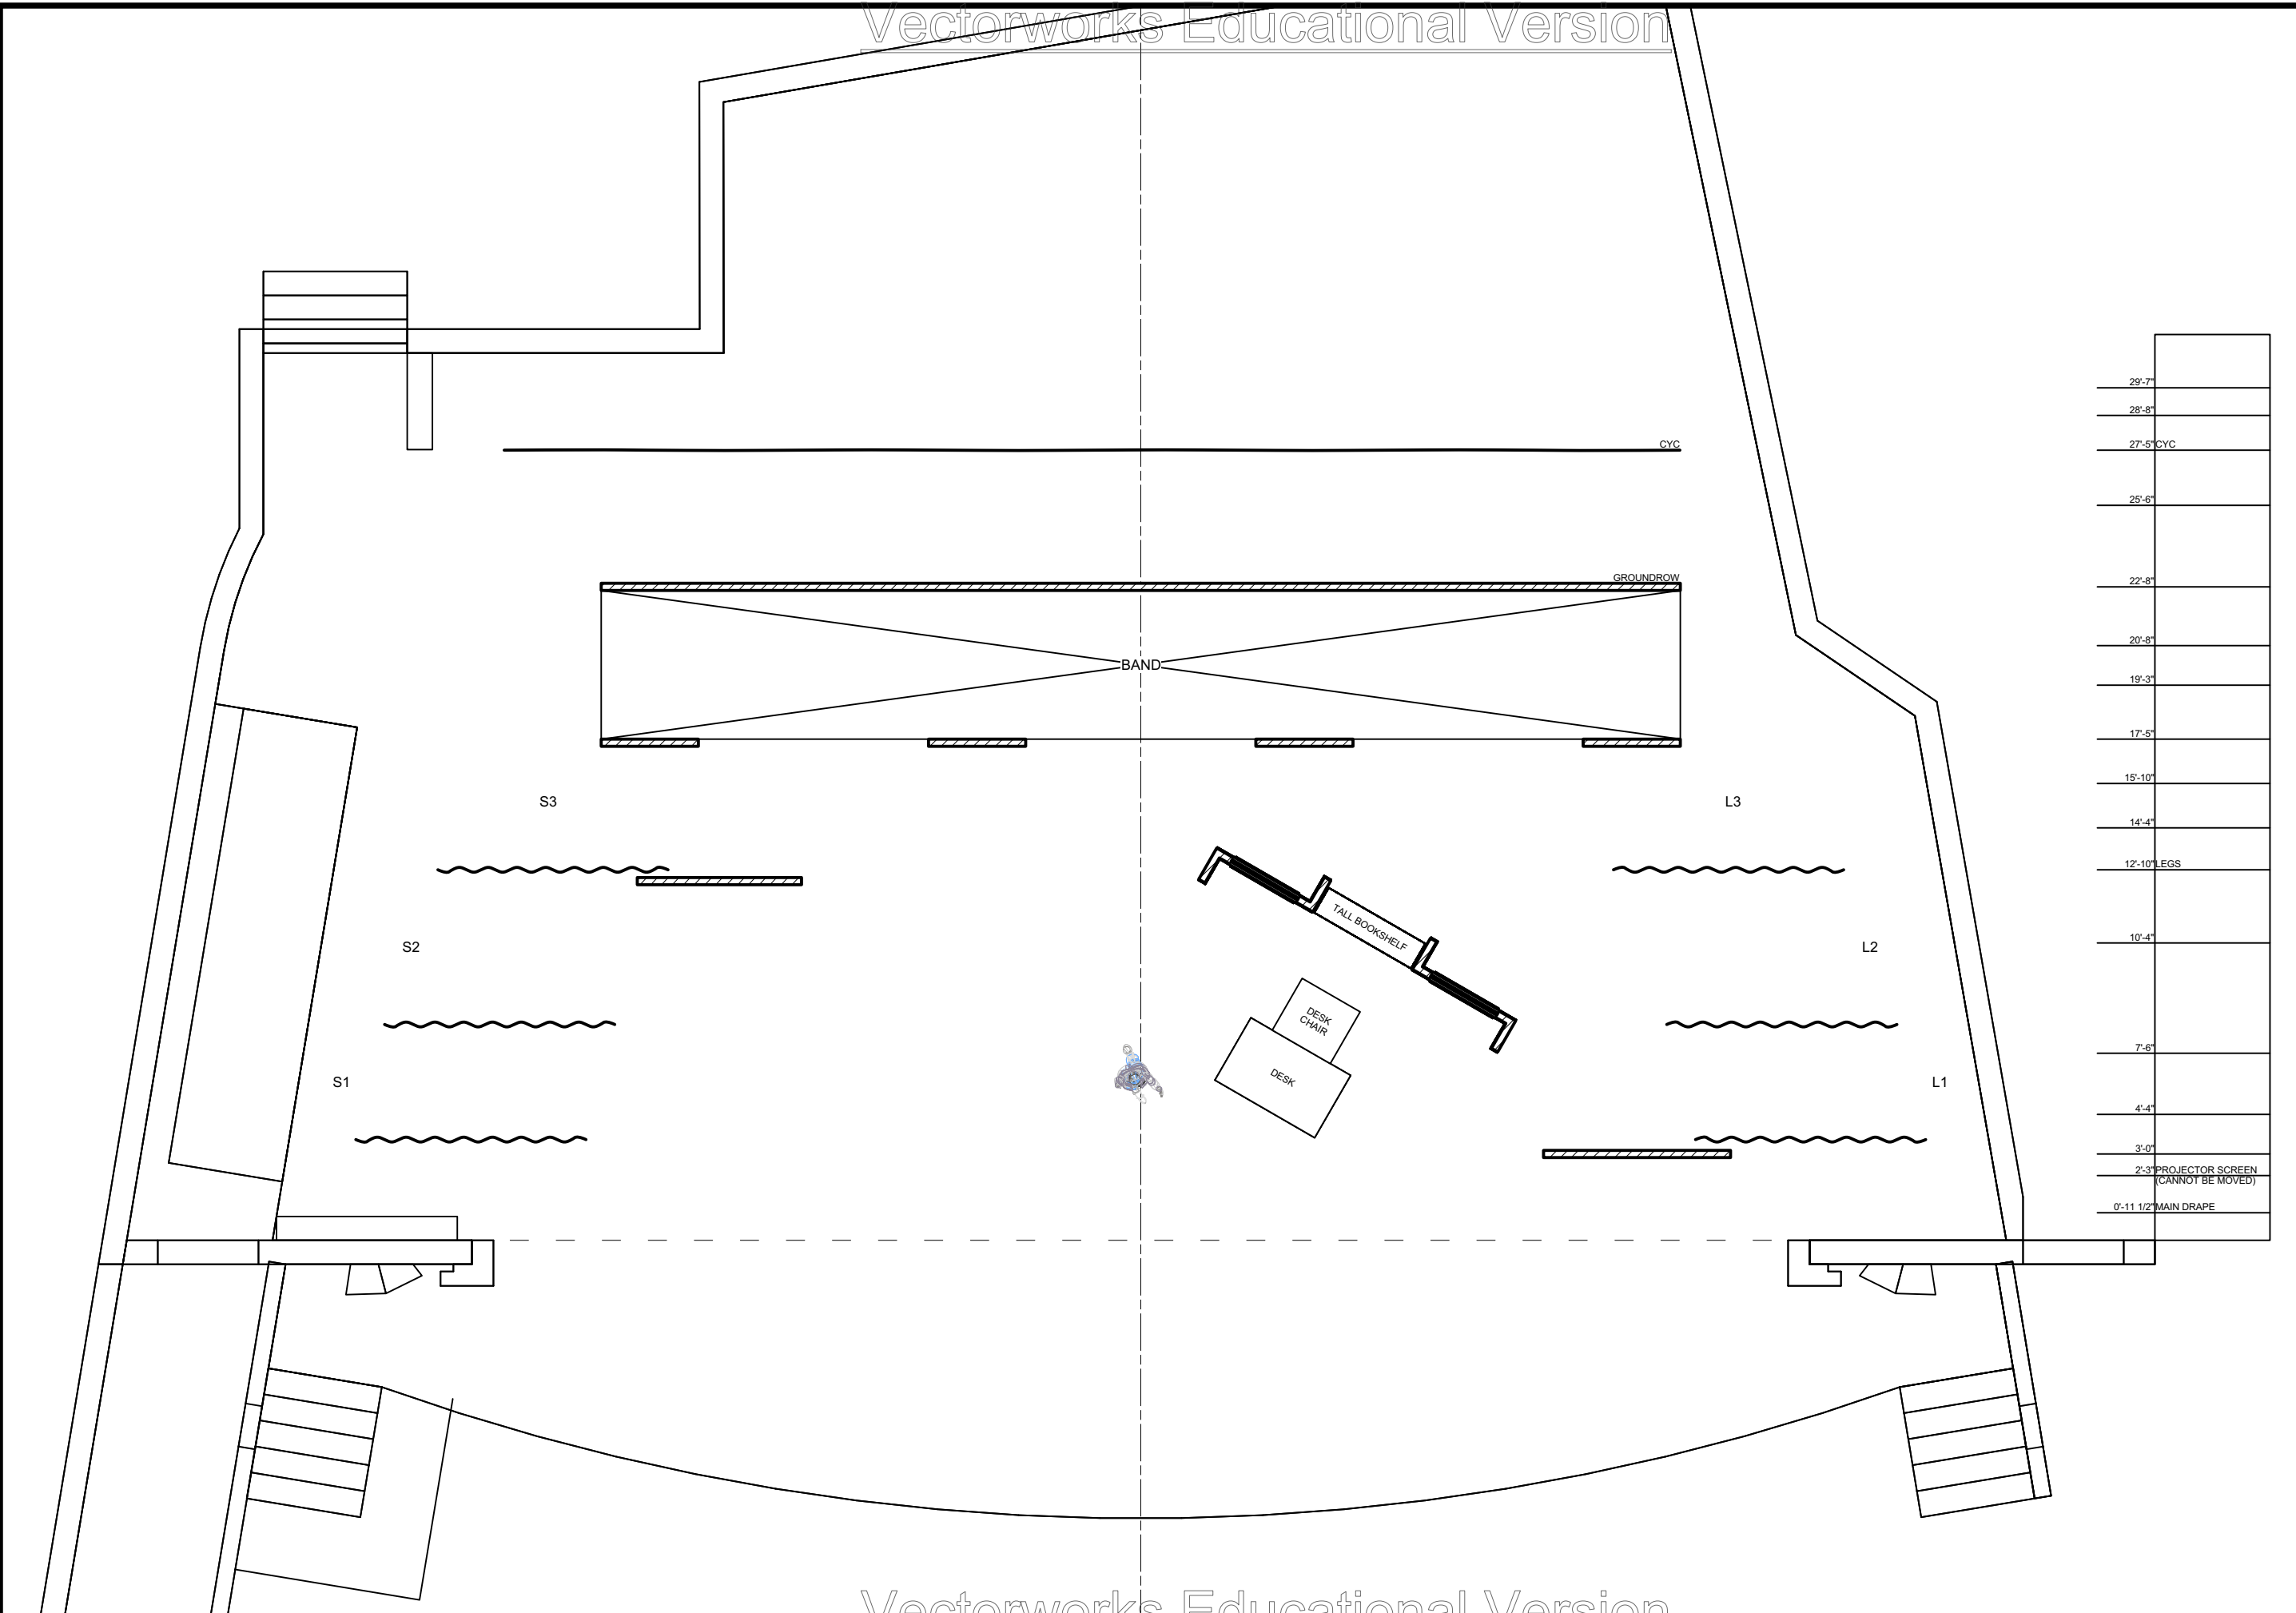

29'-7"	
28'-8"	
27'-5" CYC	
25'-6"	
22'-8"	
20'-8"	
19'-3"	
17'-5"	
15'-10"	
14'-4"	
12'-10" LEGS	
10'-4"	
7'-6"	
4'-4"	
3'-0"	
2'-3" PROJECTOR SCREEN (CANNOT BE MOVED)	
0'-11 1/2" MAIN DRAPE	


**Disclaimer:**  
 Drawings are only meant only to illustrate ideas and are not to be used as a basis for construction. All structural elements shown in the design must be evaluated and stamped by a certified technical director before construction. The designer does not assume any liability for structural integrity in the designs. The company selected to build the designs will assume all liability to its structural integrity and related consumer, crew and performer safety.

*Brandon M. Newton*  
 Scenic Designer Signature

Sheet Title: <b>A1S14 - Alice's Office (1945)</b>	Scale: <b>1/4" = 1'-0"</b>	Drawn By: <b>Brandon M. Newton</b>
Date: <b>02 Mar 2023</b>		Designer: <b>Brandon M. Newton</b>
Venue: <b>Actor's Playhouse</b>	Stage: <b>Mainstage Theatre</b>	Director: <b>David Arisco</b>
		Technical Director: <b>Gene Seyffer</b>

Show Title:  
**BRIGHT STAR**

Sheet Number:  
**GP-14** of **0**

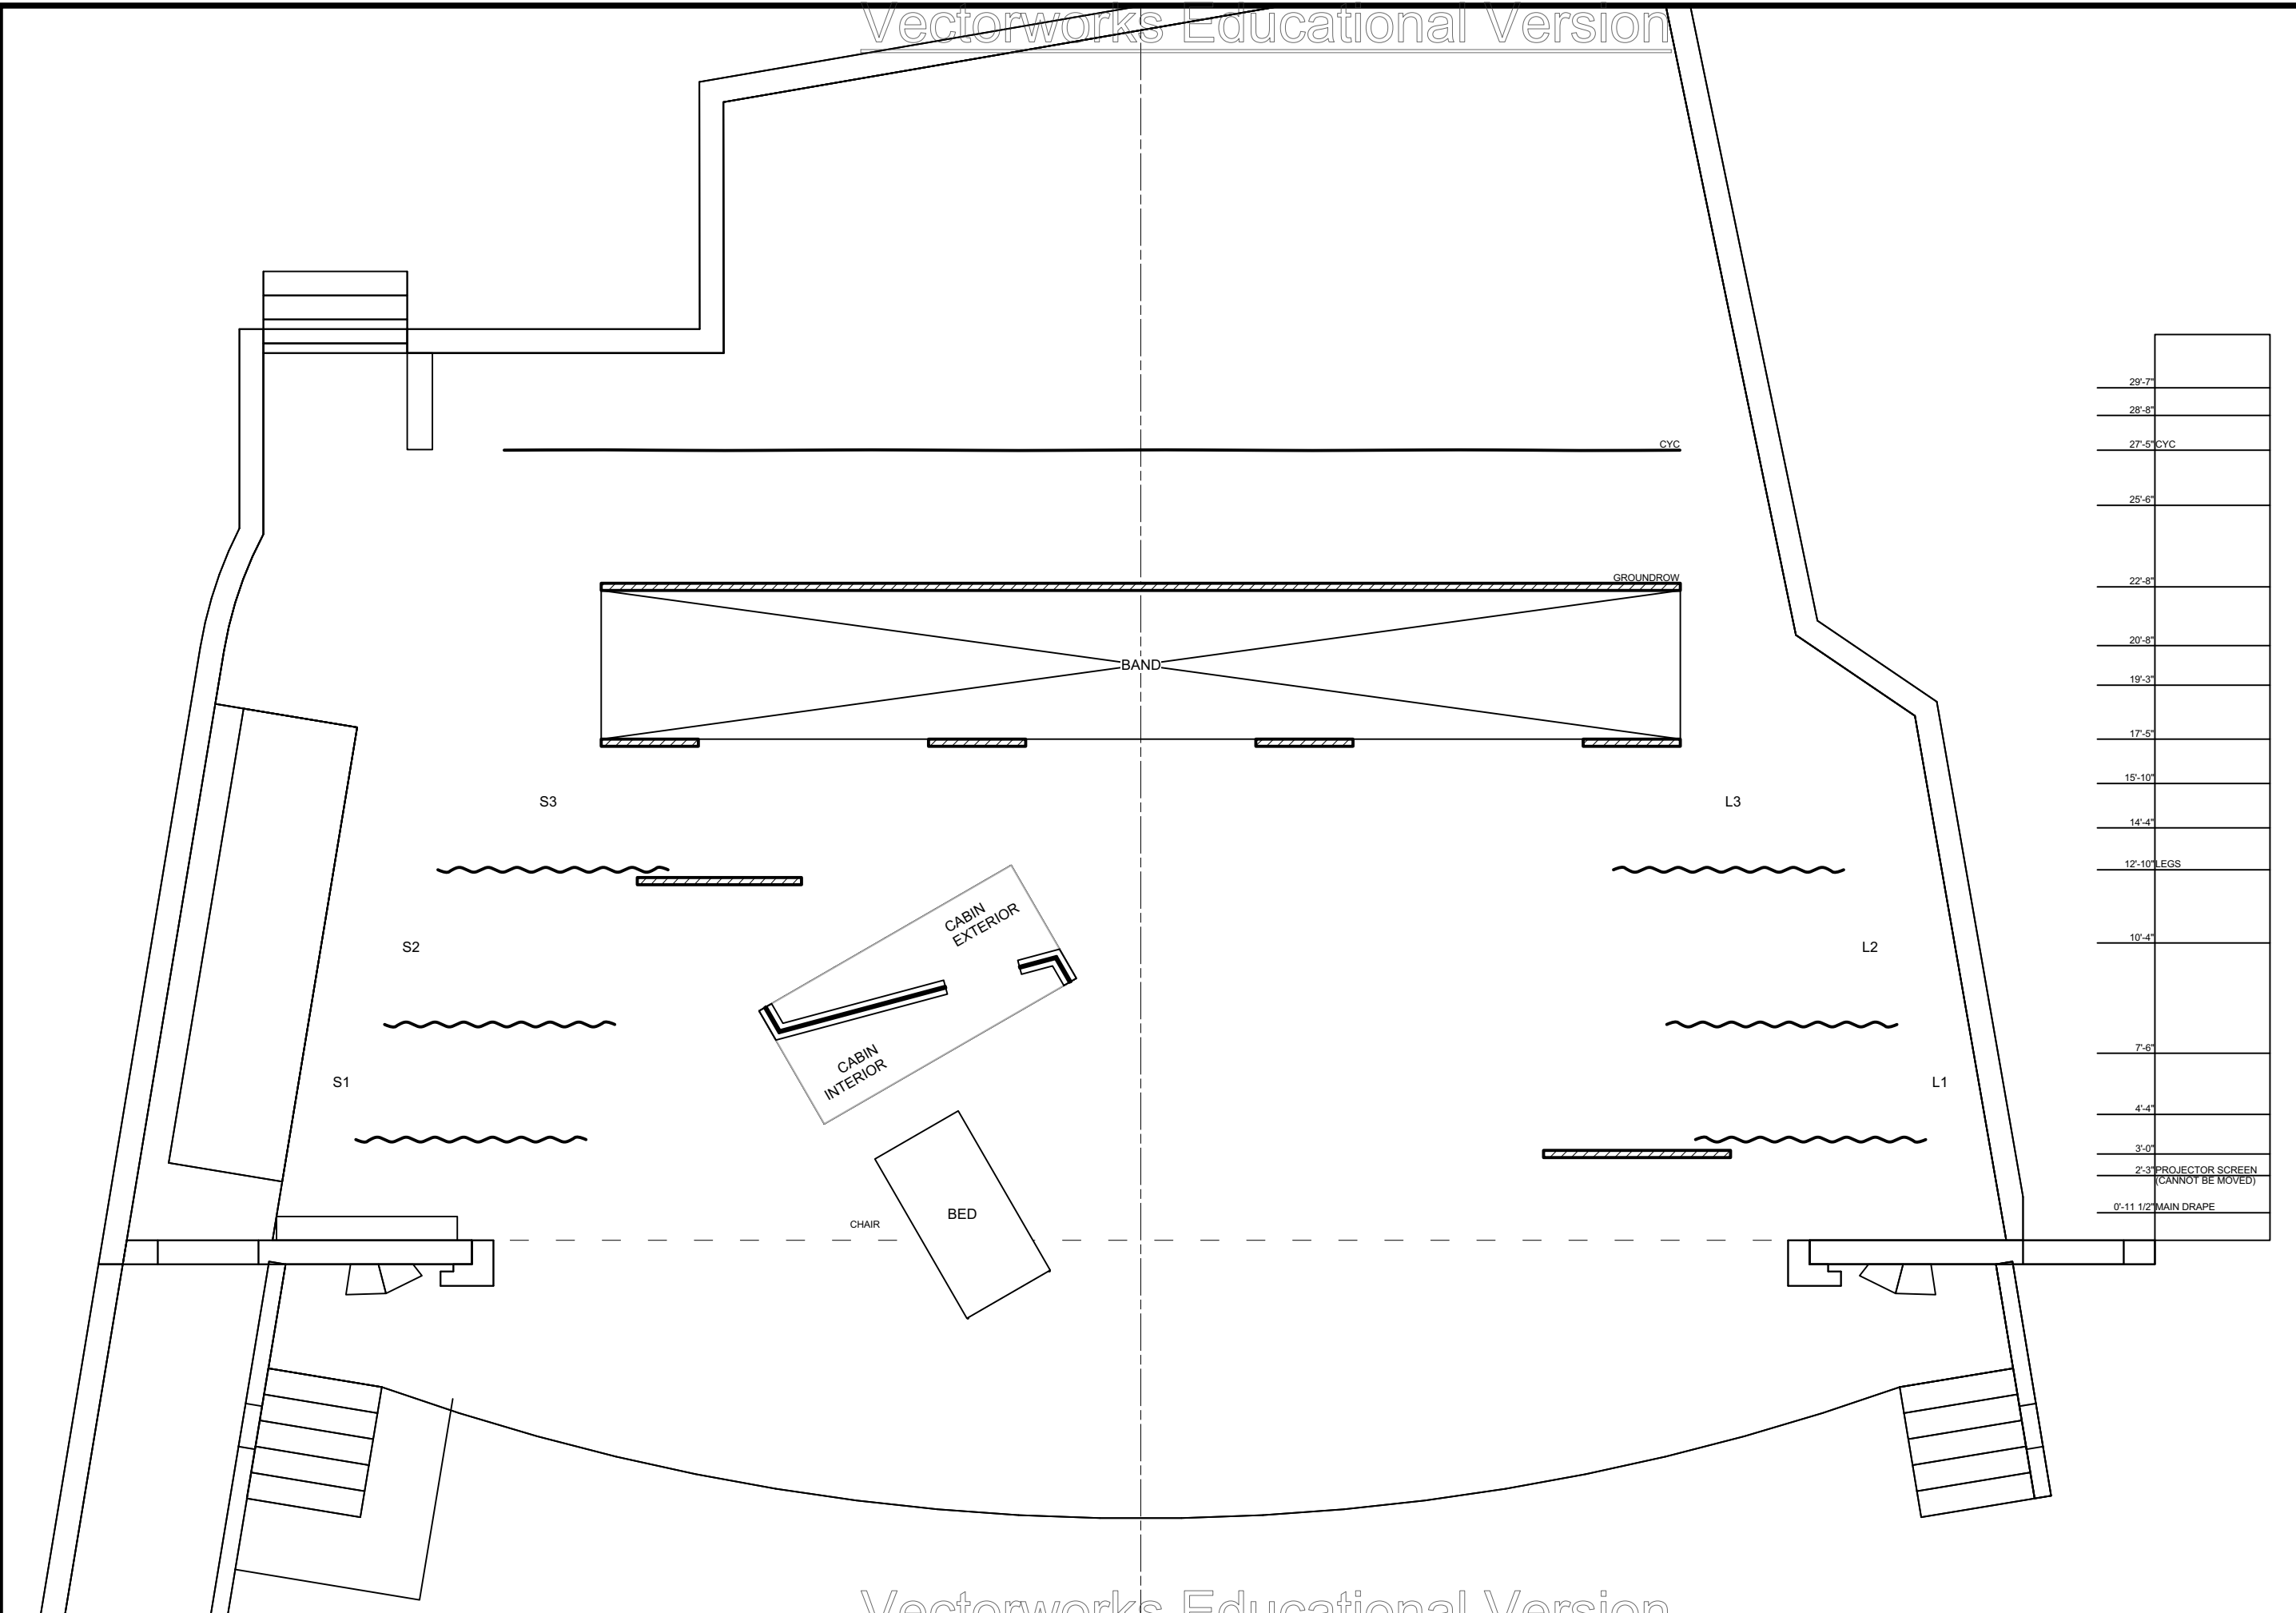

**Disclaimer:**  
 Drawings are only meant only to illustrate ideas and are not to be used for construction. All structural elements shown in the design must be evaluated and stamped by a certified technical director before construction. The designer does not assume any liability for structural integrity in the designs. The company selected to build the designs will assume all liability to its structural integrity and related consumer, crew and performer safety.

*Brandon M. Newton*  
 Scenic Designer Signature

Venue: **Actor's Playhouse**

Stage: **Mainstage Theatre**

Director: **David Arisco**

Technical Director: **Gene Seyffer**

Show Title: **BRIGHT STAR**

Sheet Title: **A1S15 - Shack (1924)**


Date: **02 Mar 2023**

Designer: **Brandon M. Newton**

Scale: **1/4" = 1'-0"**

Drawn By: **Brandon M. Newton**

Sheet Number: **GP-15** of **0**

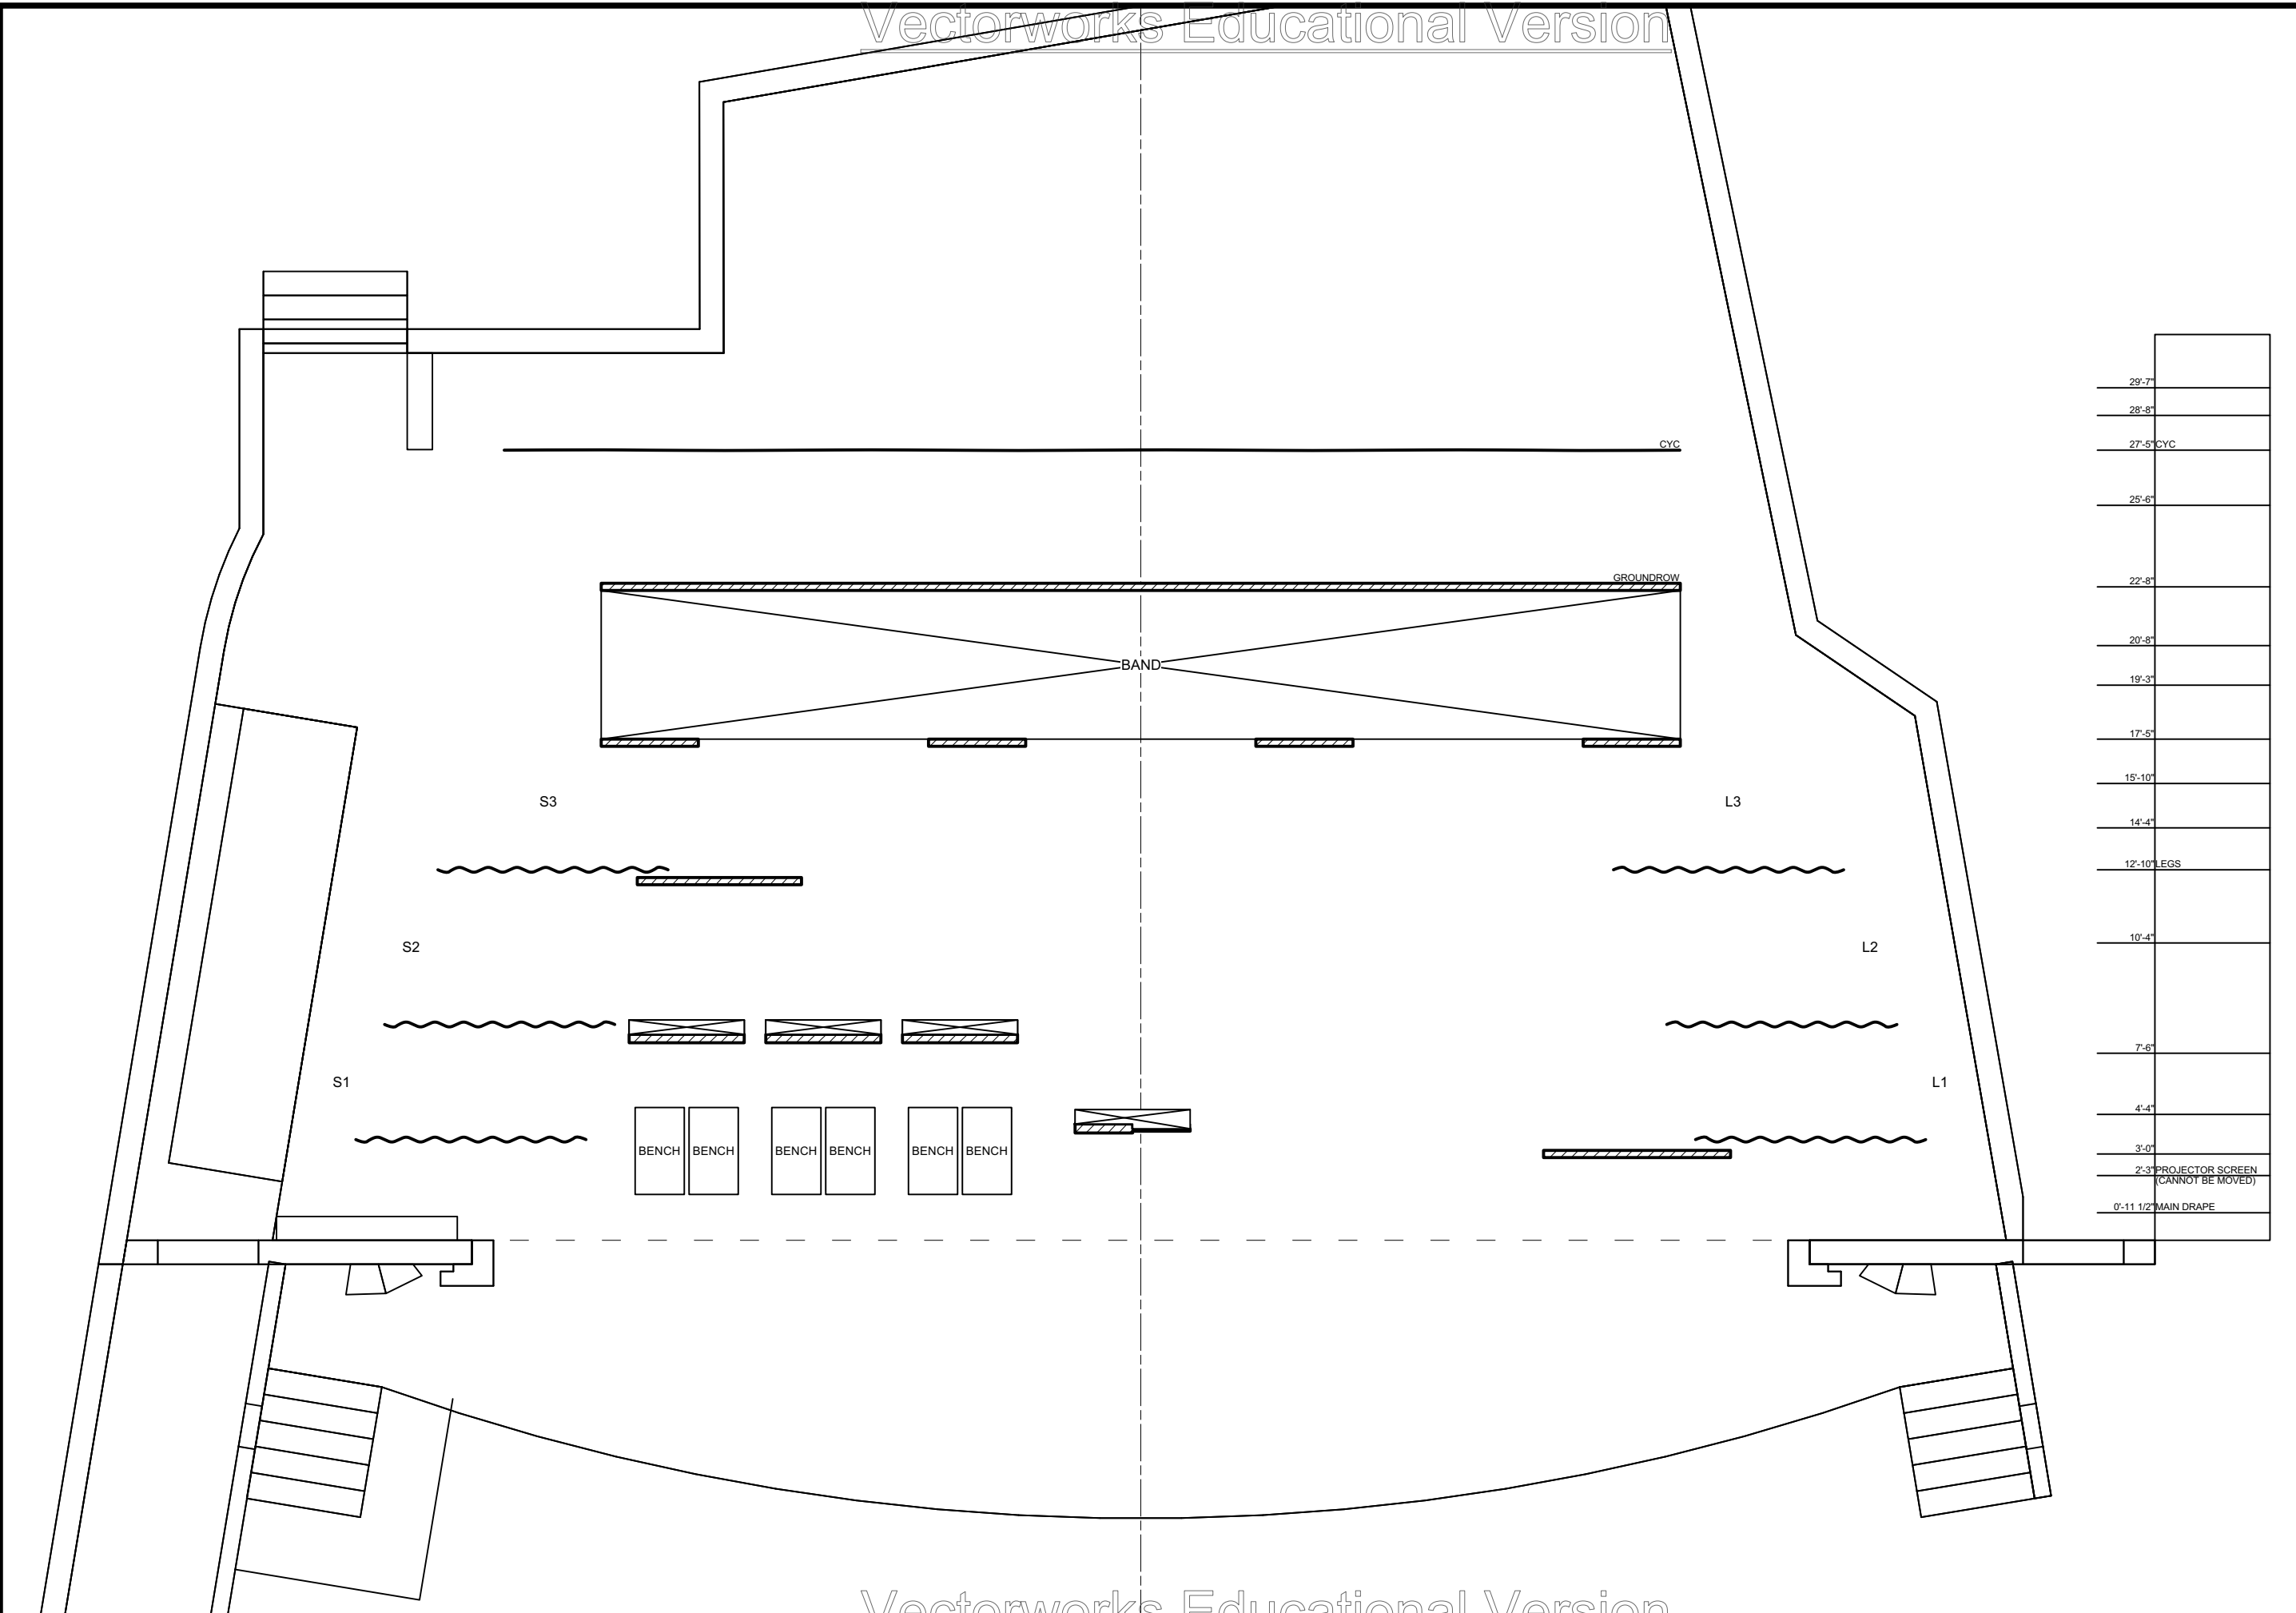

**Disclaimer:**  
 Drawings are only meant only to illustrate ideas and are not to be used for construction. All structural elements shown in the design must be evaluated and stamped by a certified technical director before construction. The designer does not assume any liability for structural integrity in the designs. The company selected to build the designs will assume all liability to its structural integrity and related consumer, crew and performer safety.

*Brandon M. Newton*  
 Scenic Designer Signature

Venue: **Actor's Playhouse**

Stage: **Mainstage Theatre**

Director: **David Arisco**

Technical Director: **Gene Seyffer**

Show Title: **BRIGHT STAR**

Sheet Title: **A1S16 - Train Car (1924)**

Date: **02 Mar 2023**


Designer: **Brandon M. Newton**

Scale: **1/4" = 1'-0"**

Drawn By: **Brandon M. Newton**

Sheet Number: **GP-16** of **0**



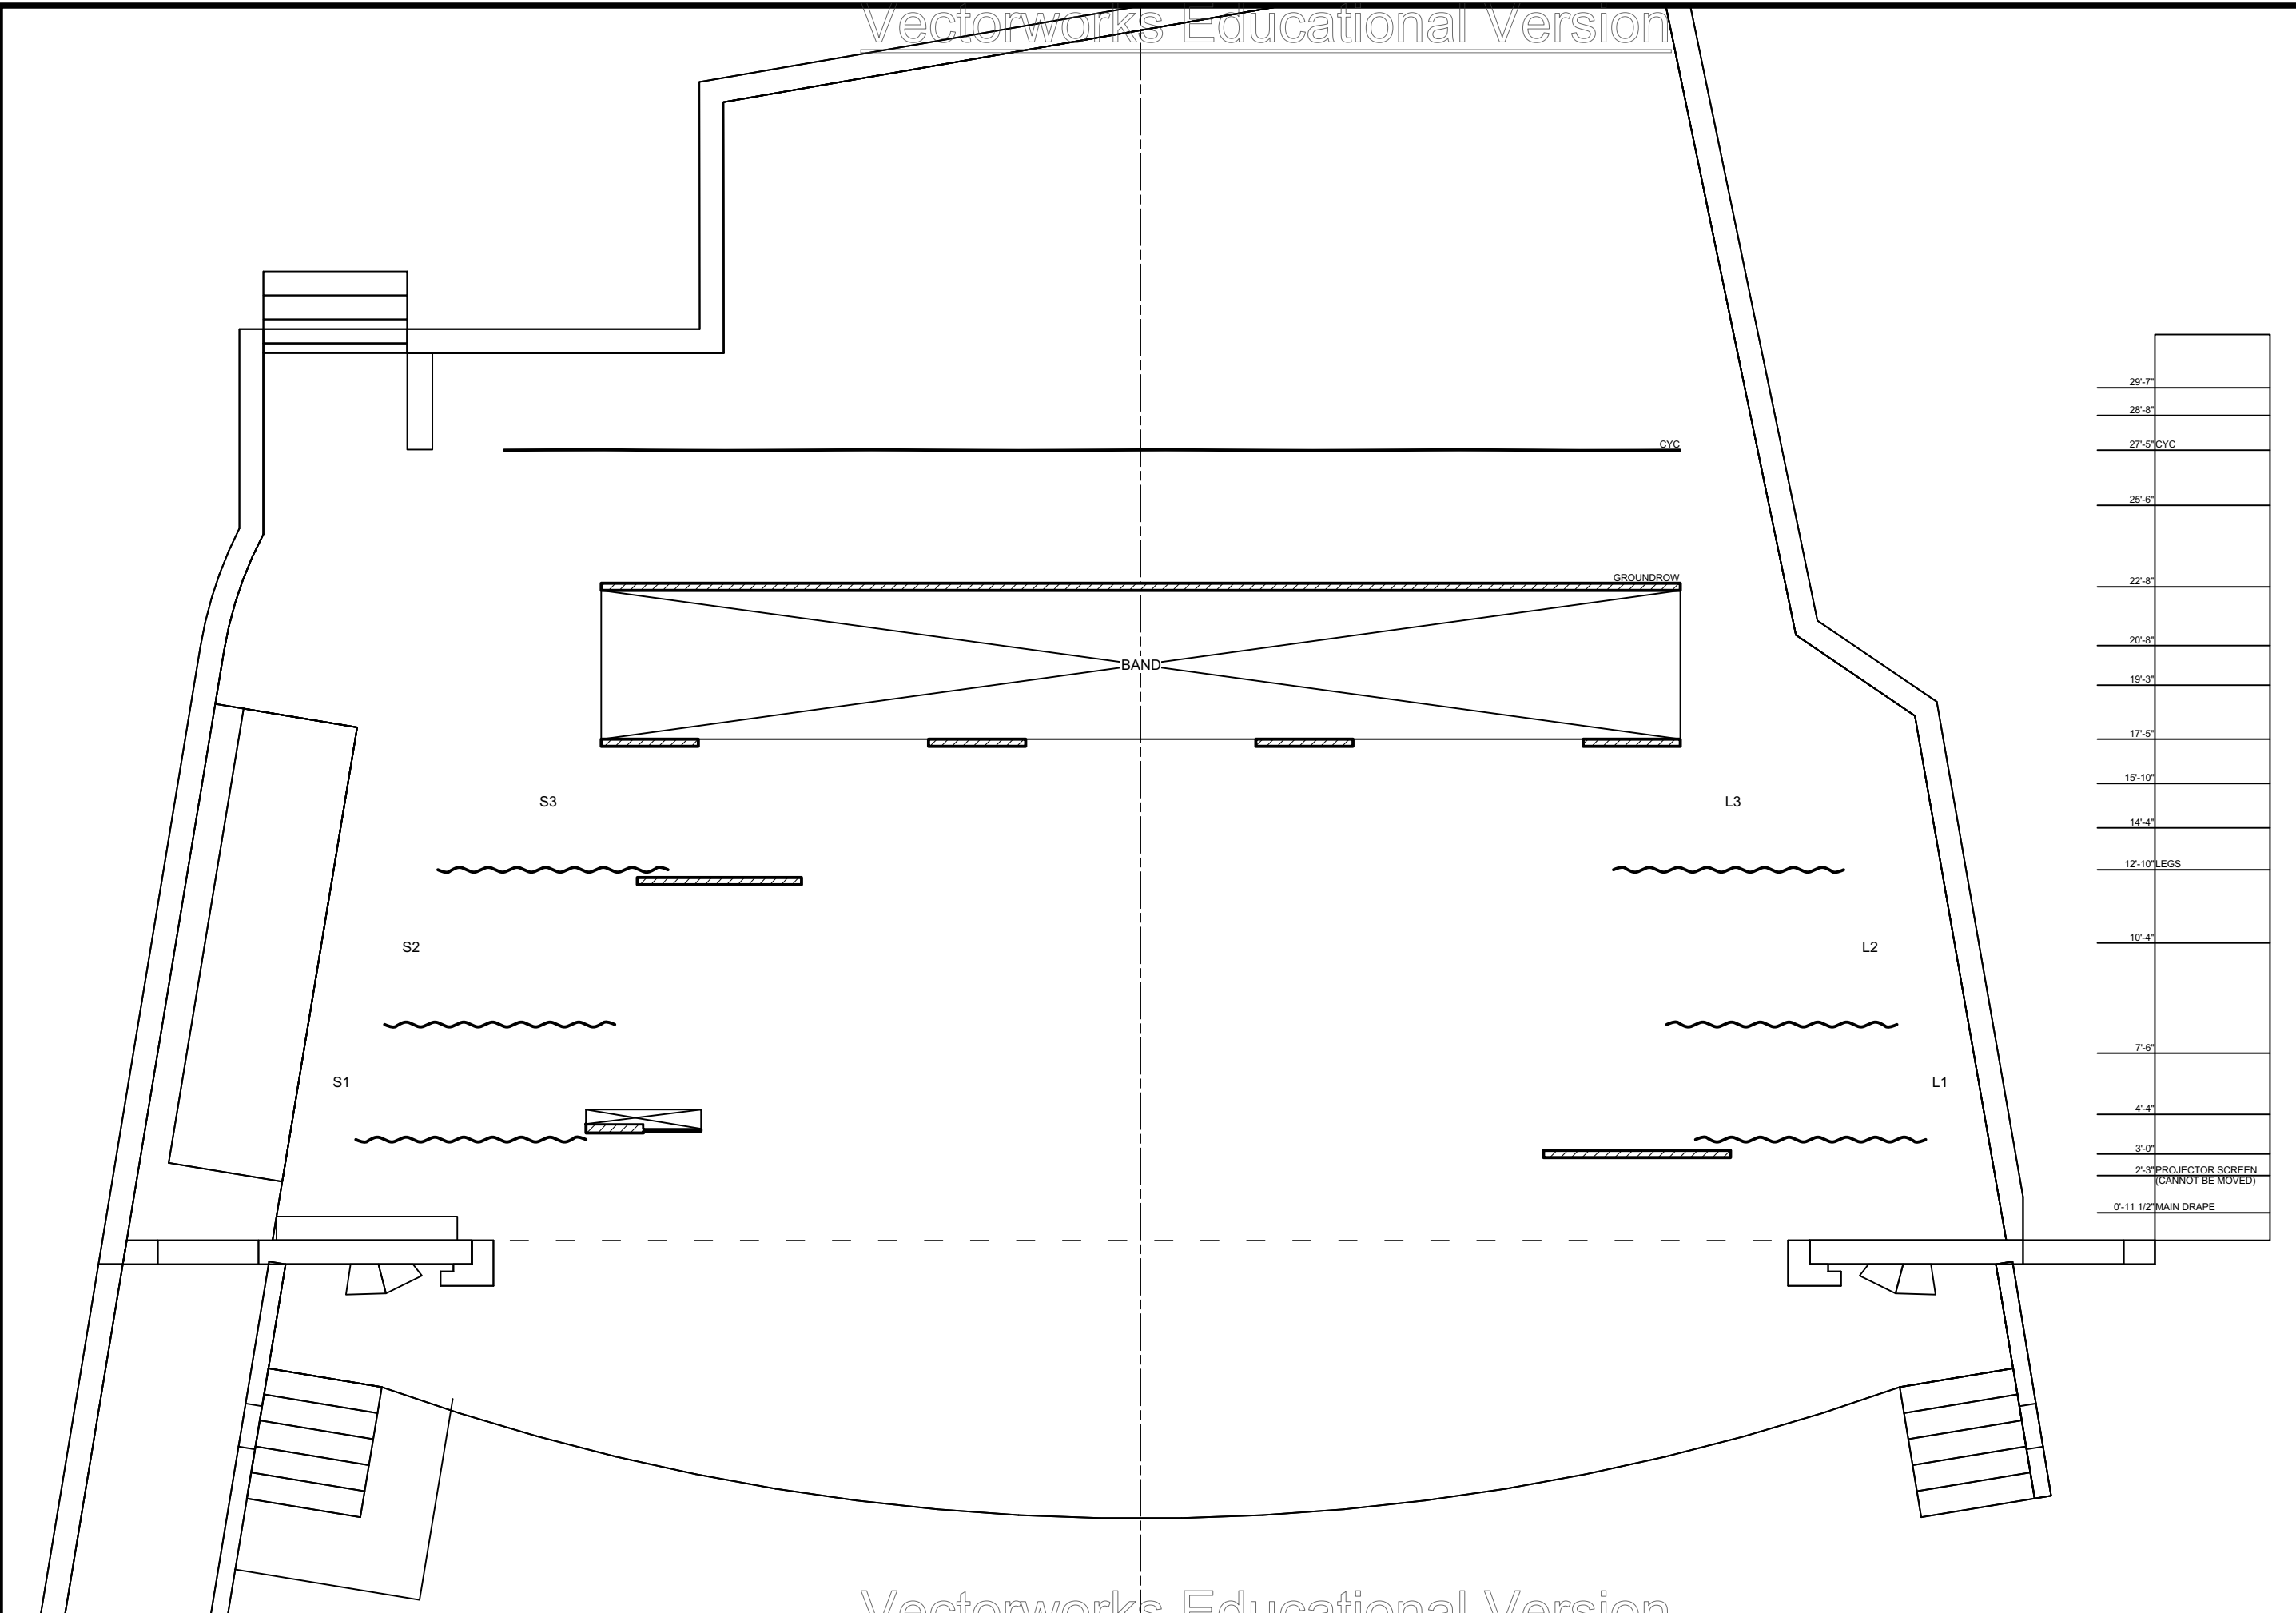


29'-7"	
28'-8"	
27'-5" CYC	
25'-6"	
22'-8"	
20'-8"	
19'-3"	
17'-5"	
15'-10"	
14'-4"	
12'-10" LEGS	
10'-4"	
7'-6"	
4'-4"	
3'-0"	
2'-3" PROJECTOR SCREEN (CANNOT BE MOVED)	
0'-11 1/2" MAIN DRAPE	

**Disclaimer:**  
 Drawings are only meant only to illustrate ideas and are not to be used for construction. All structural elements shown in the design must be evaluated and stamped by a certified technical director before construction. The designer does not assume any liability for structural integrity in the designs. The company selected to build the designs will assume all liability to its structural integrity and related consumer, crew and performer safety.

*Brandon M. Newton*  
 Scenic Designer Signature

Sheet Title: <b>A2S0 - Train Depot (1924)</b>	Scale: <b>1/4" = 1'-0"</b>	Drawn By: <b>Brandon M. Newton</b>
Date: <b>02 Mar 2023</b>		Designer: <b>Brandon M. Newton</b>
Sheet Number: <b>GP-17</b>		of: <b>0</b>

Venue: <b>Actor's Playhouse</b>	Director: <b>David Arisco</b>	Technical Director: <b>Gene Seyffer</b>
Show Title: <b>BRIGHT STAR</b>		

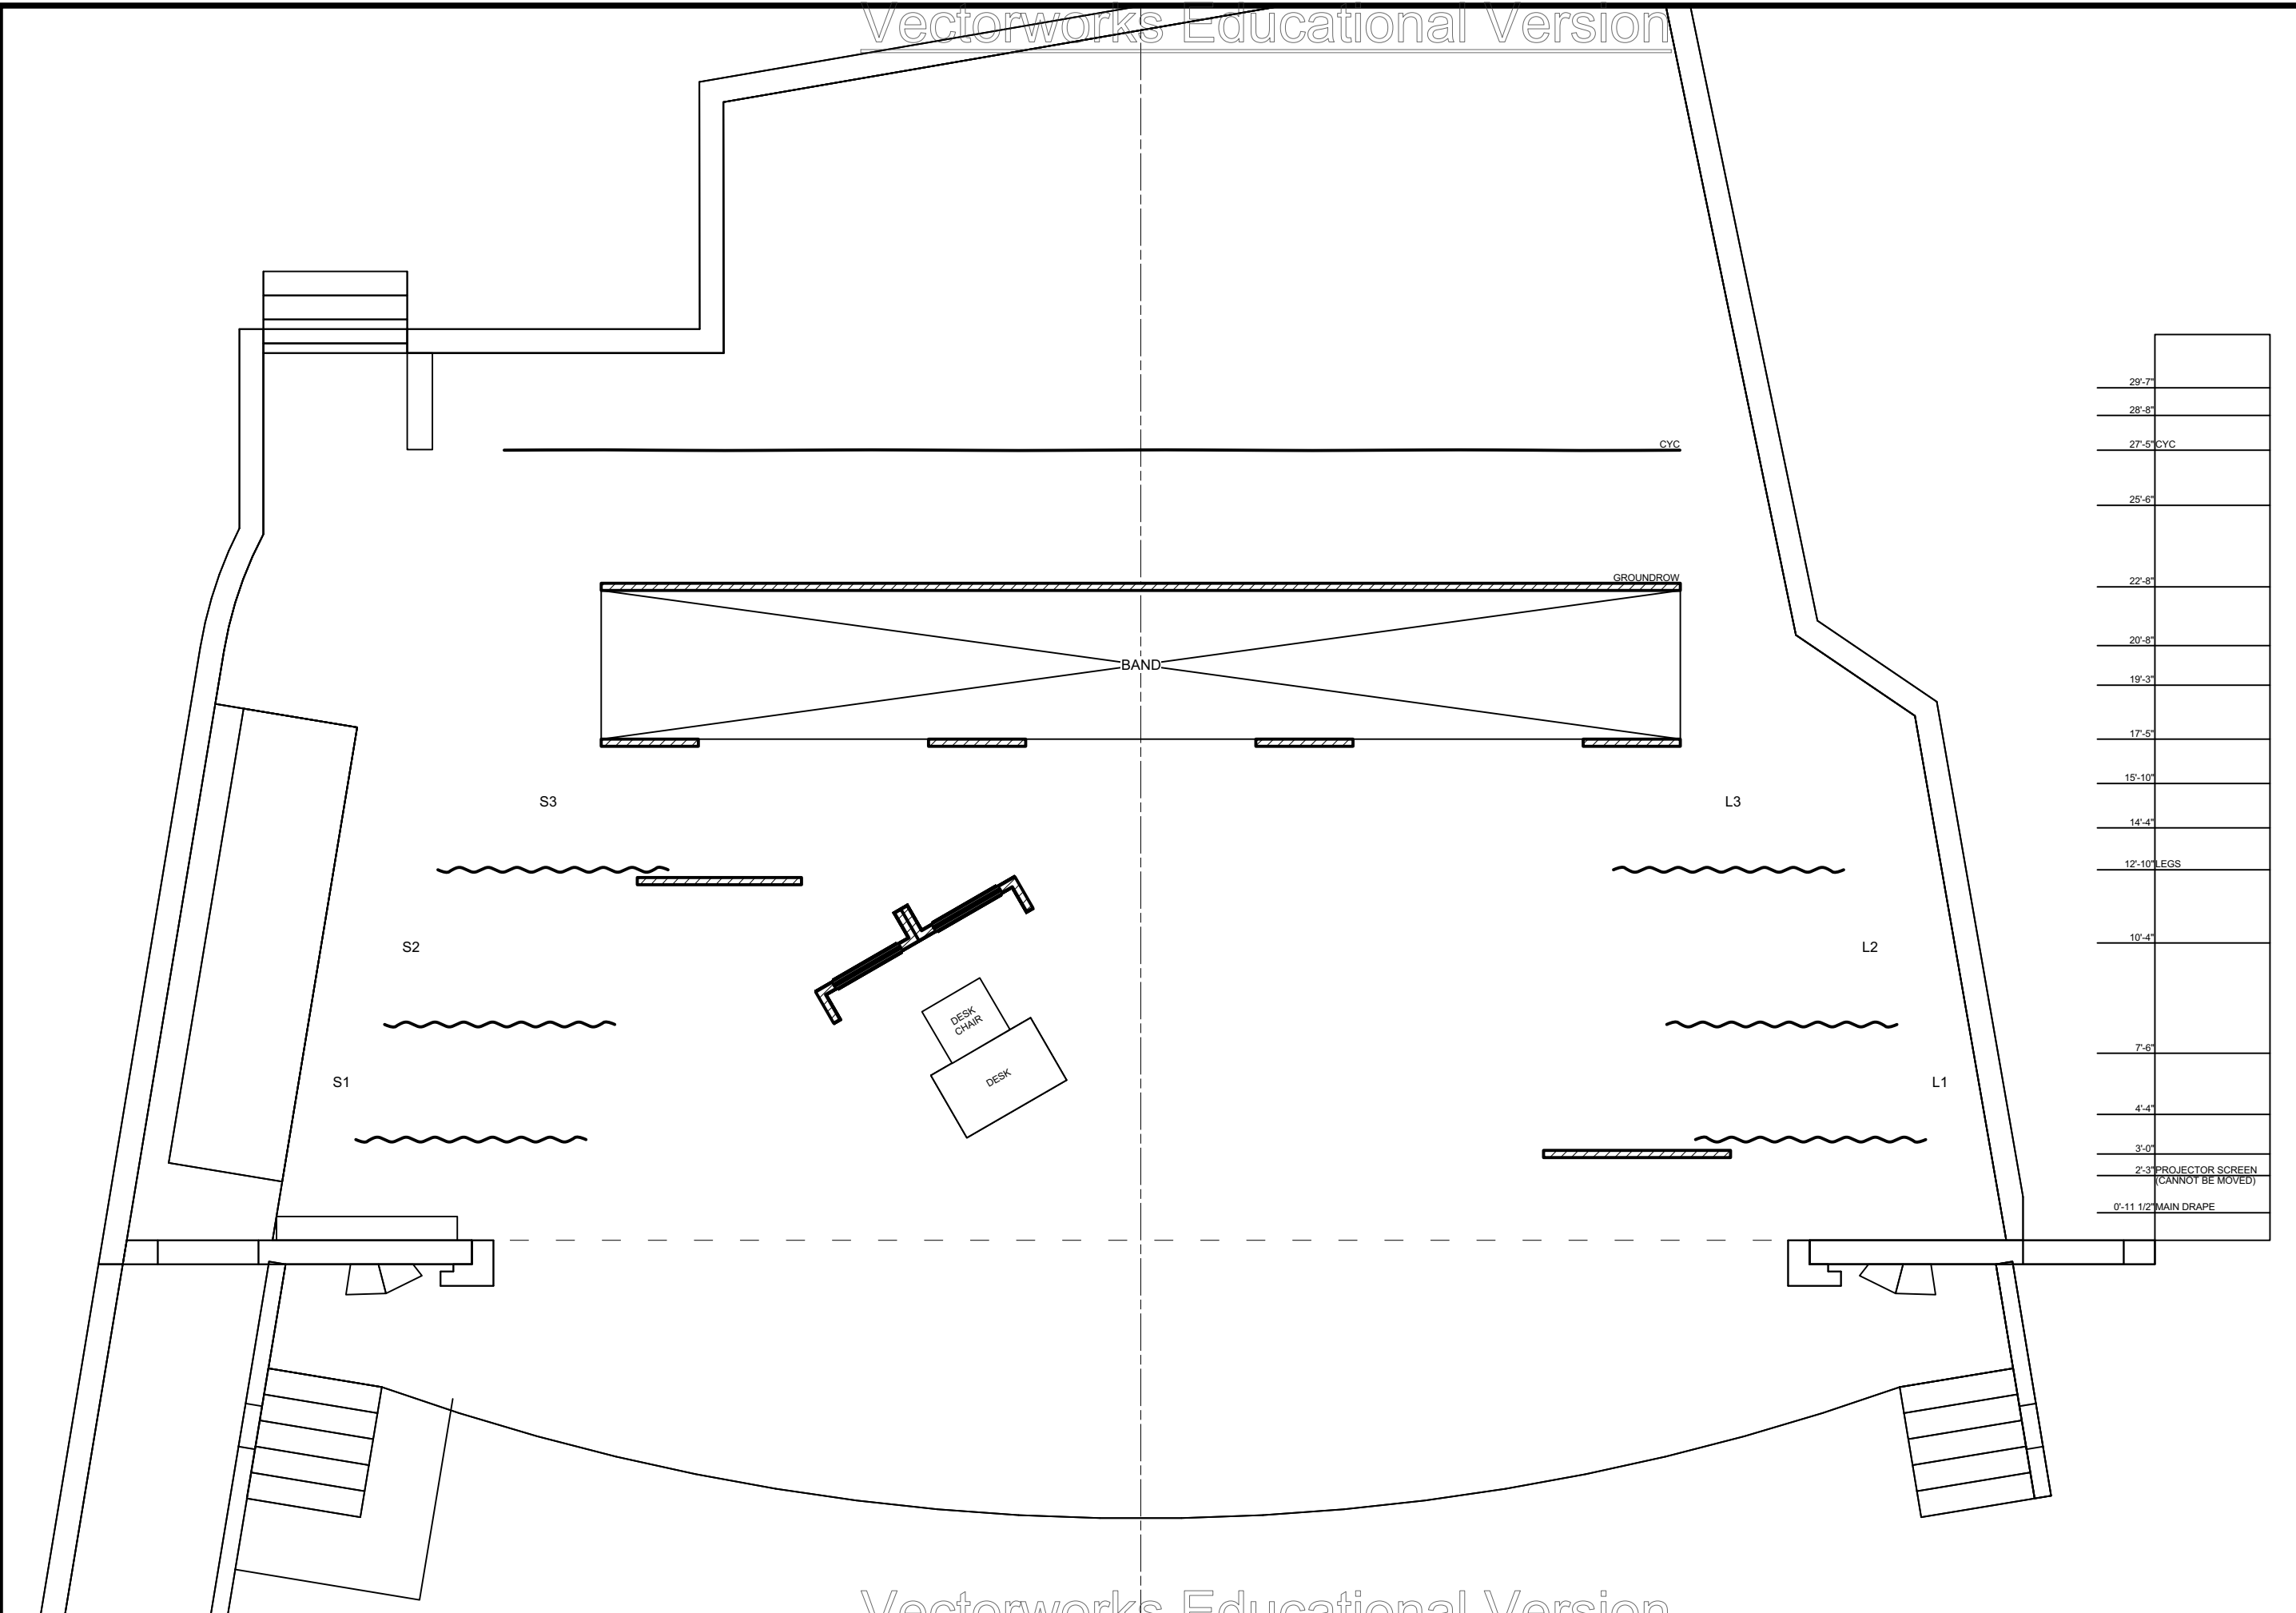

**Disclaimer:**  
 Drawings are only meant only to illustrate ideas and are not to be used for construction. All structural elements shown in the design must be evaluated and stamped by a certified technical director before construction. The designer does not assume any liability for structural integrity in the designs. The company selected to build the designs will assume all liability to its structural integrity and related consumer, crew and performer safety.

*Brandon M. Newton*  
 Scenic Designer Signature

Venue: **Actor's Playhouse**

Stage: **Mainstage Theatre**

Director: **David Arisco**

Technical Director: **Gene Seyffer**

Show Title: **BRIGHT STAR**

Sheet Title: **A2S1 - Mayor's Office (1924)**

Date: **02 Mar 2023**


Designer: **Brandon M. Newton**

Scale: **1/4" = 1'-0"**

Drawn By: **Brandon M. Newton**

Sheet Number: **GP-18** of: **0**



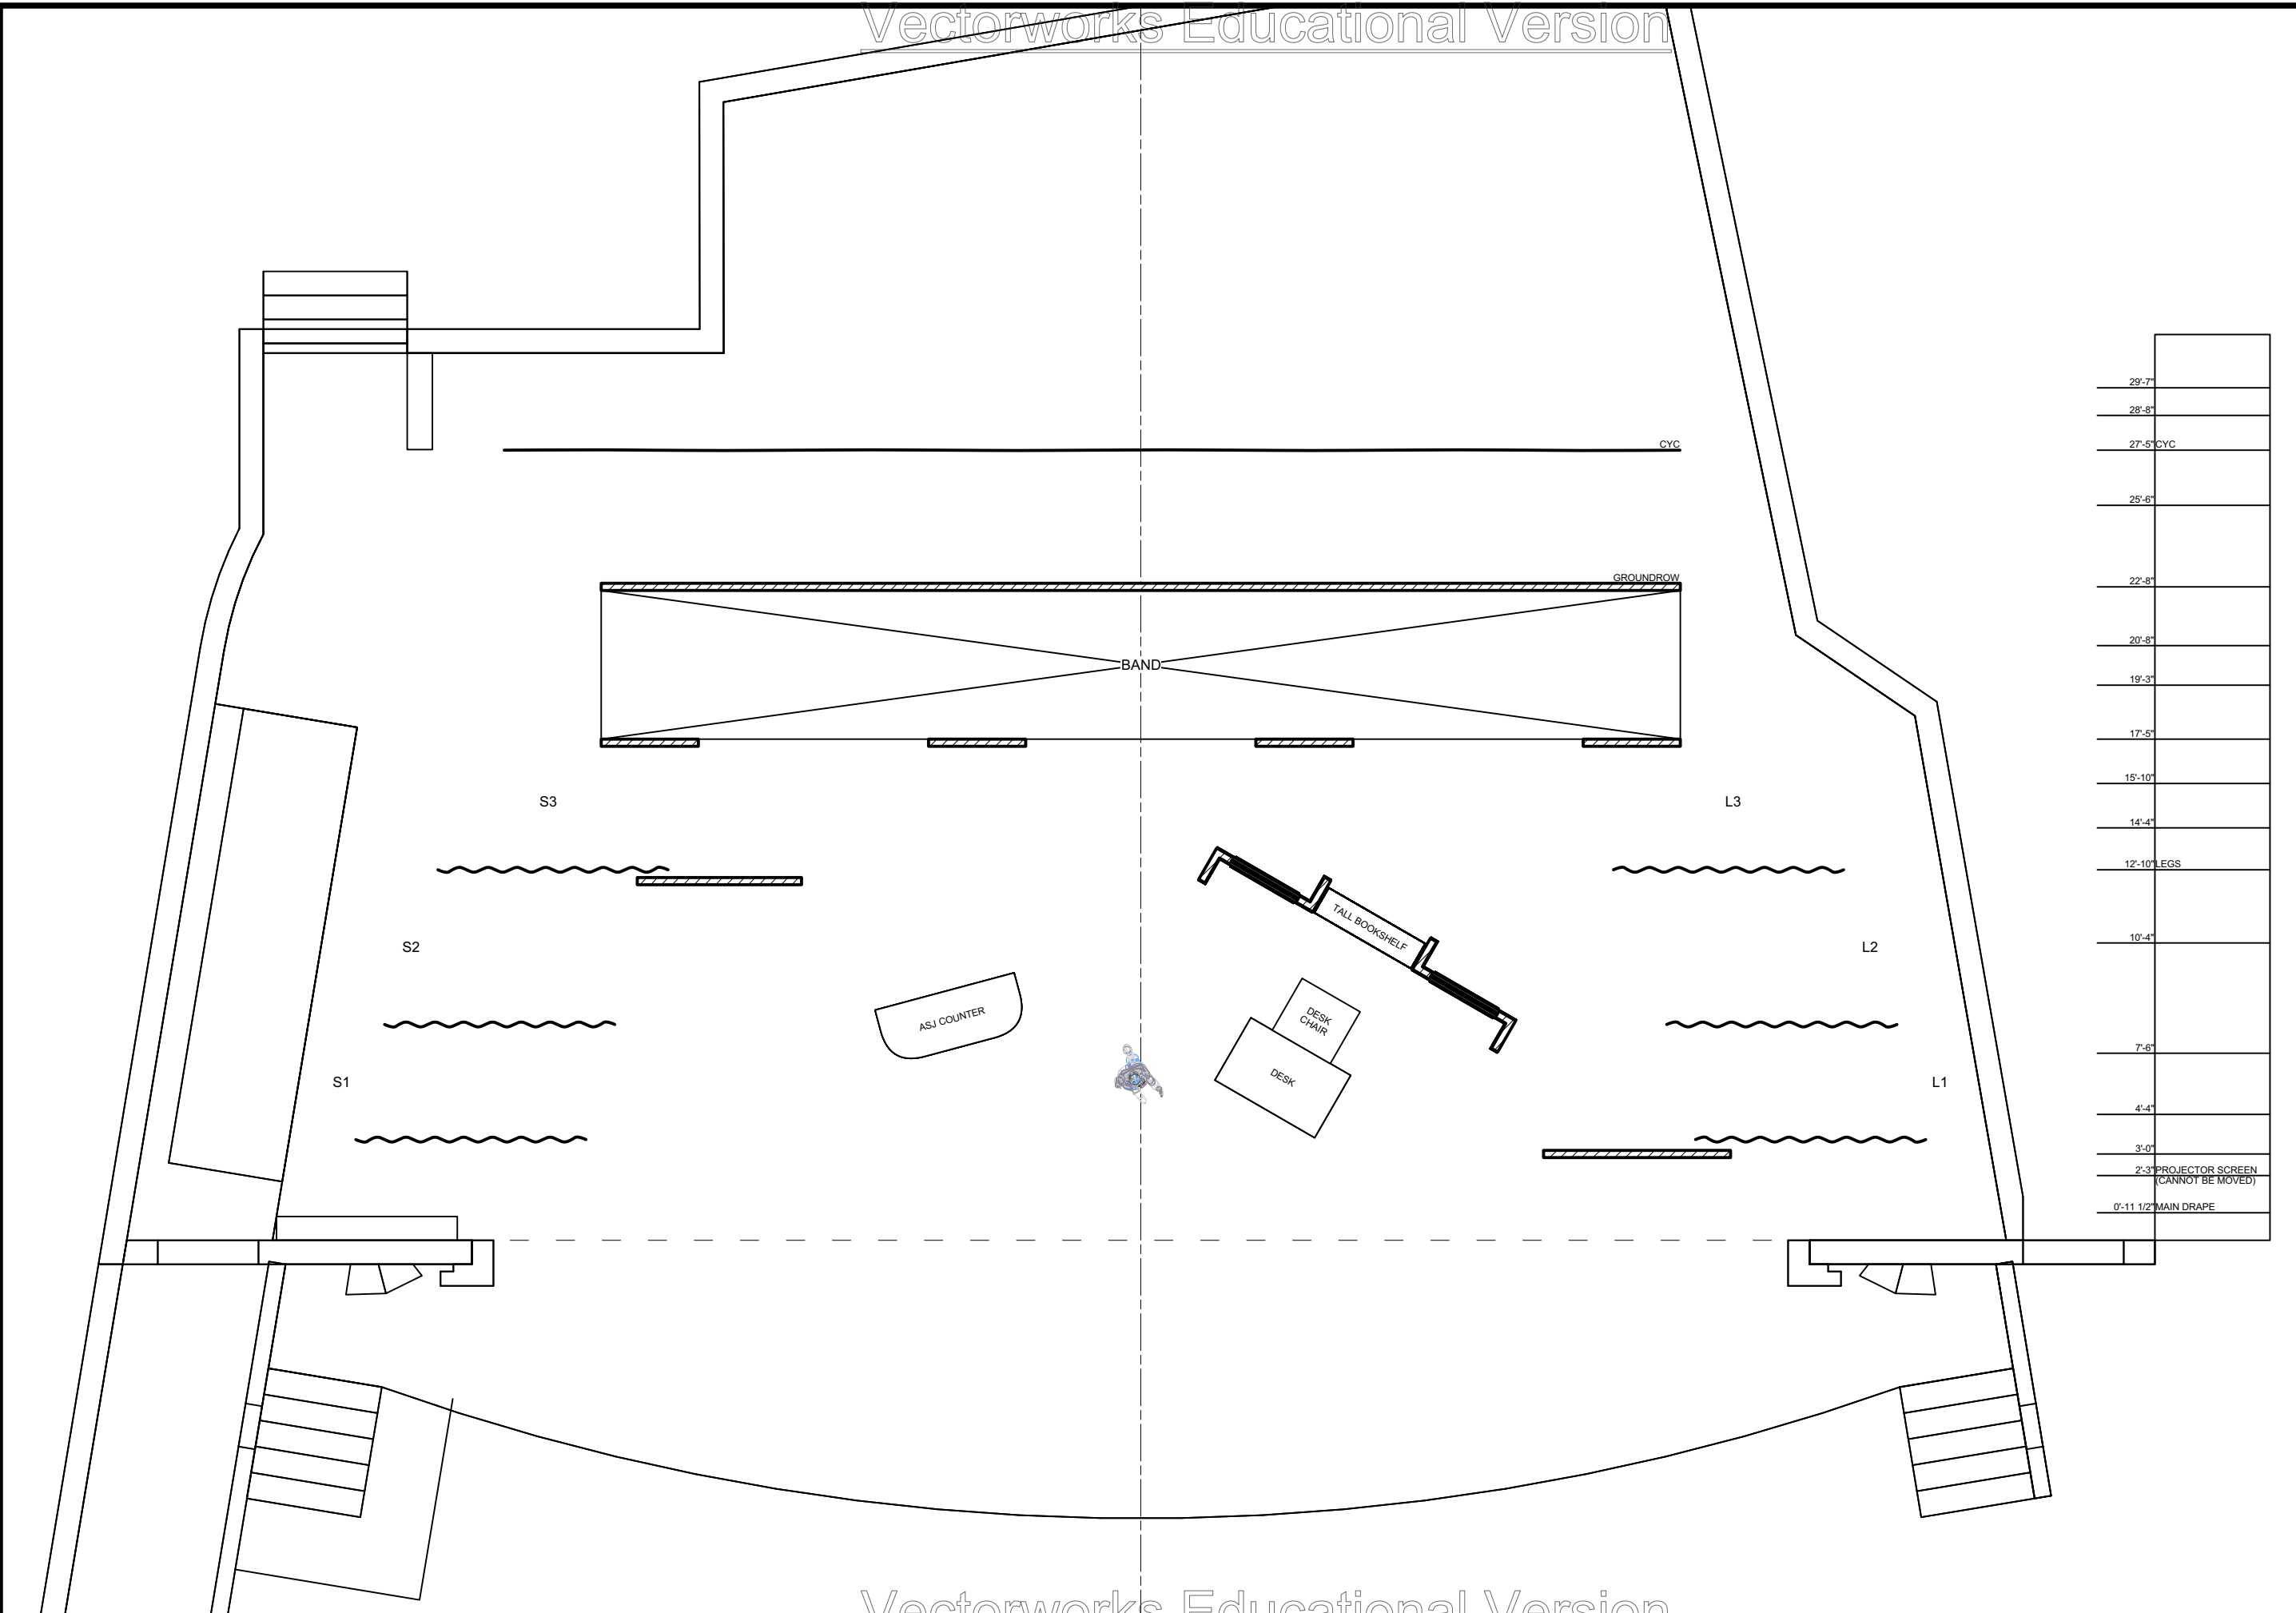


29'-7"	
28'-8"	
27'-5" CYC	
25'-6"	
22'-8"	
20'-8"	
19'-3"	
17'-5"	
15'-10"	
14'-4"	
12'-10" LEGS	
10'-4"	
7'-6"	
4'-4"	
3'-0"	
2'-3" PROJECTOR SCREEN (CANNOT BE MOVED)	
0'-11 1/2" MAIN DRAPE	

**Disclaimer:**  
 Drawings are only meant only to illustrate ideas and are not to be used for construction. All structural elements shown in the design must be evaluated and stamped by a certified technical director before construction. The designer does not assume any liability for structural integrity in the designs. The company selected to build the designs will assume all liability to its structural integrity and related consumer, crew and performer safety.

*Brandon M. Newton*  
 Scenic Designer Signature

Sheet Title: <b>A2S3 - Alice's Office (1946)</b>	Venue: <b>Actor's Playhouse</b>
Date: <b>02 Mar 2023</b>	Stage: <b>Mainstage Theatre</b>
Scale: <b>1/4" = 1'-0"</b>	Director: <b>David Arisco</b>
Designer: <b>Brandon M. Newton</b>	Technical Director: <b>Gene Seyffer</b>
Drawn By: <b>Brandon M. Newton</b>	

Sheet Number:  
**GP-20** of **0**

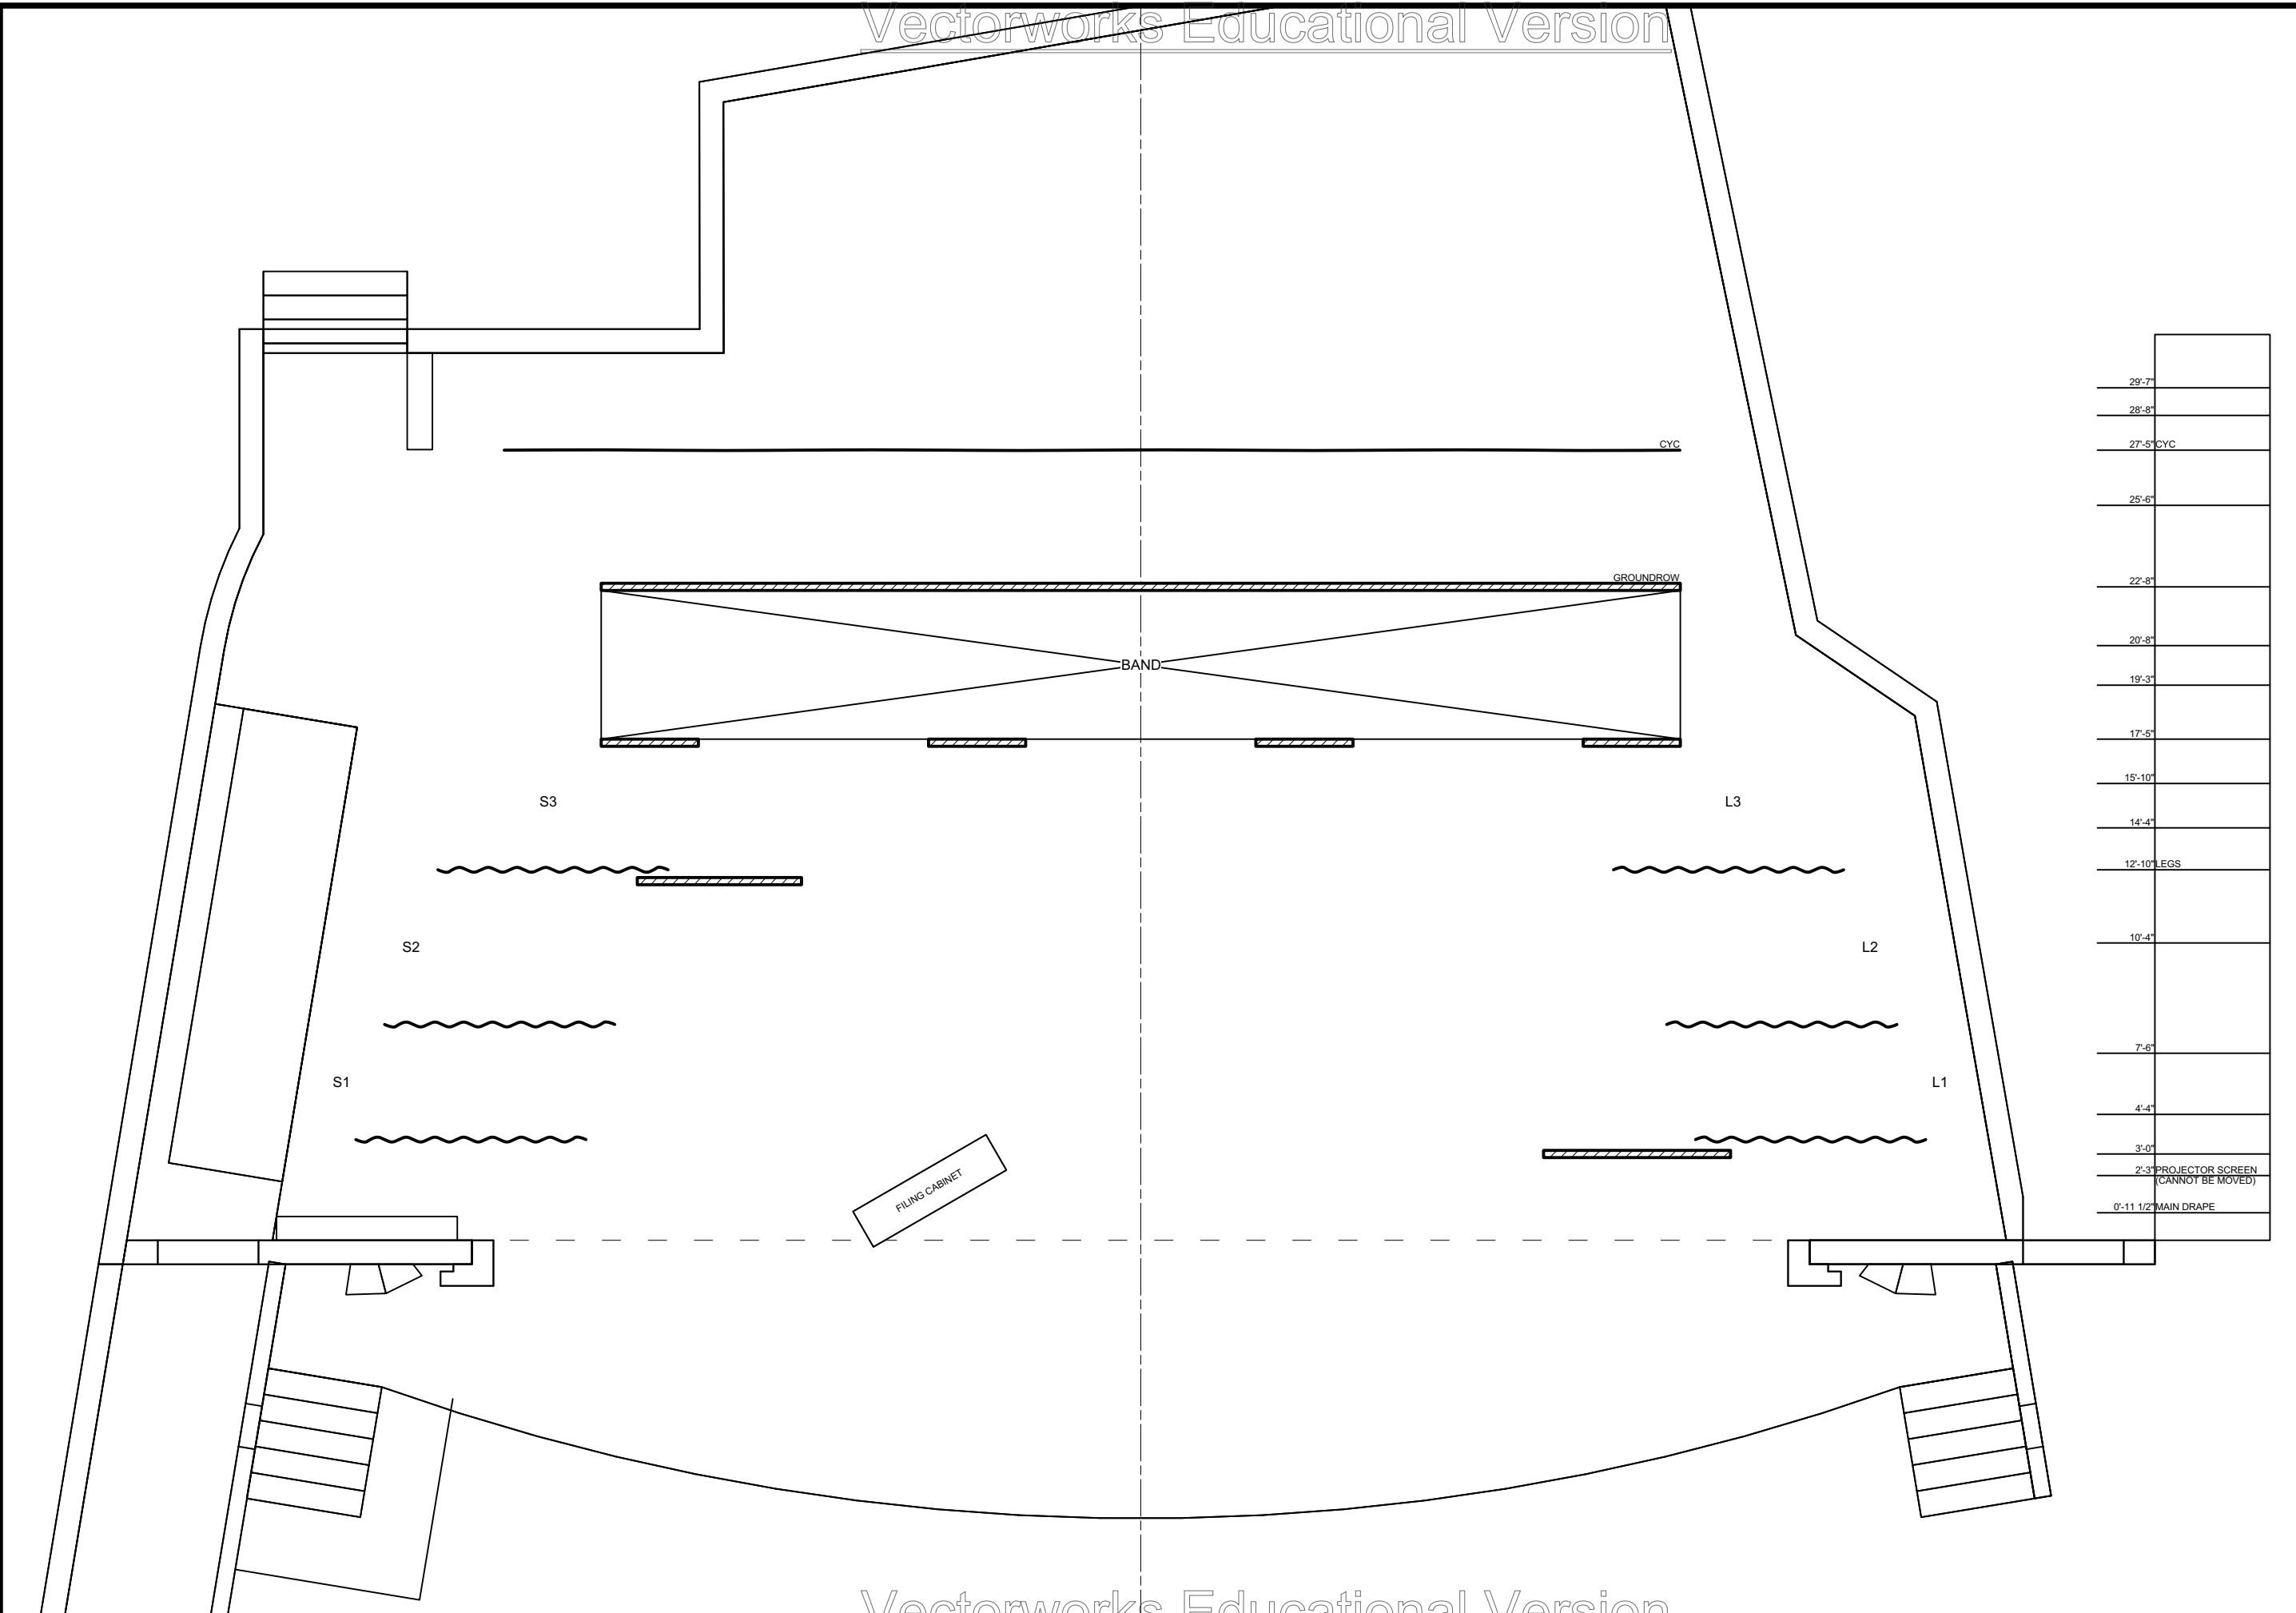

**Disclaimer:**  
 Drawings are only meant only to illustrate ideas and are not to be used for construction. All structural elements shown in the design must be evaluated and stamped by a certified technical director before construction. The designer does not assume any liability for structural integrity in the designs. The company selected to build the designs will assume all liability to its structural integrity and related consumer, crew and performer safety.

*Brandon M. Newton*  
 Scenic Designer Signature

Venue: **Actor's Playhouse**

Stage: **Mainstage Theatre**

Director: **David Arisco**

Technical Director: **Gene Seyffer**

Show Title: **BRIGHT STAR**

Sheet Title: **A2S4 - Gov Record Office (1946)**


Date: **02 Mar 2023**

Scale: **1/4" = 1'-0"**

Designer: **Brandon M. Newton**

Drawn By: **Brandon M. Newton**

Sheet Number: **GP-21** of **0**

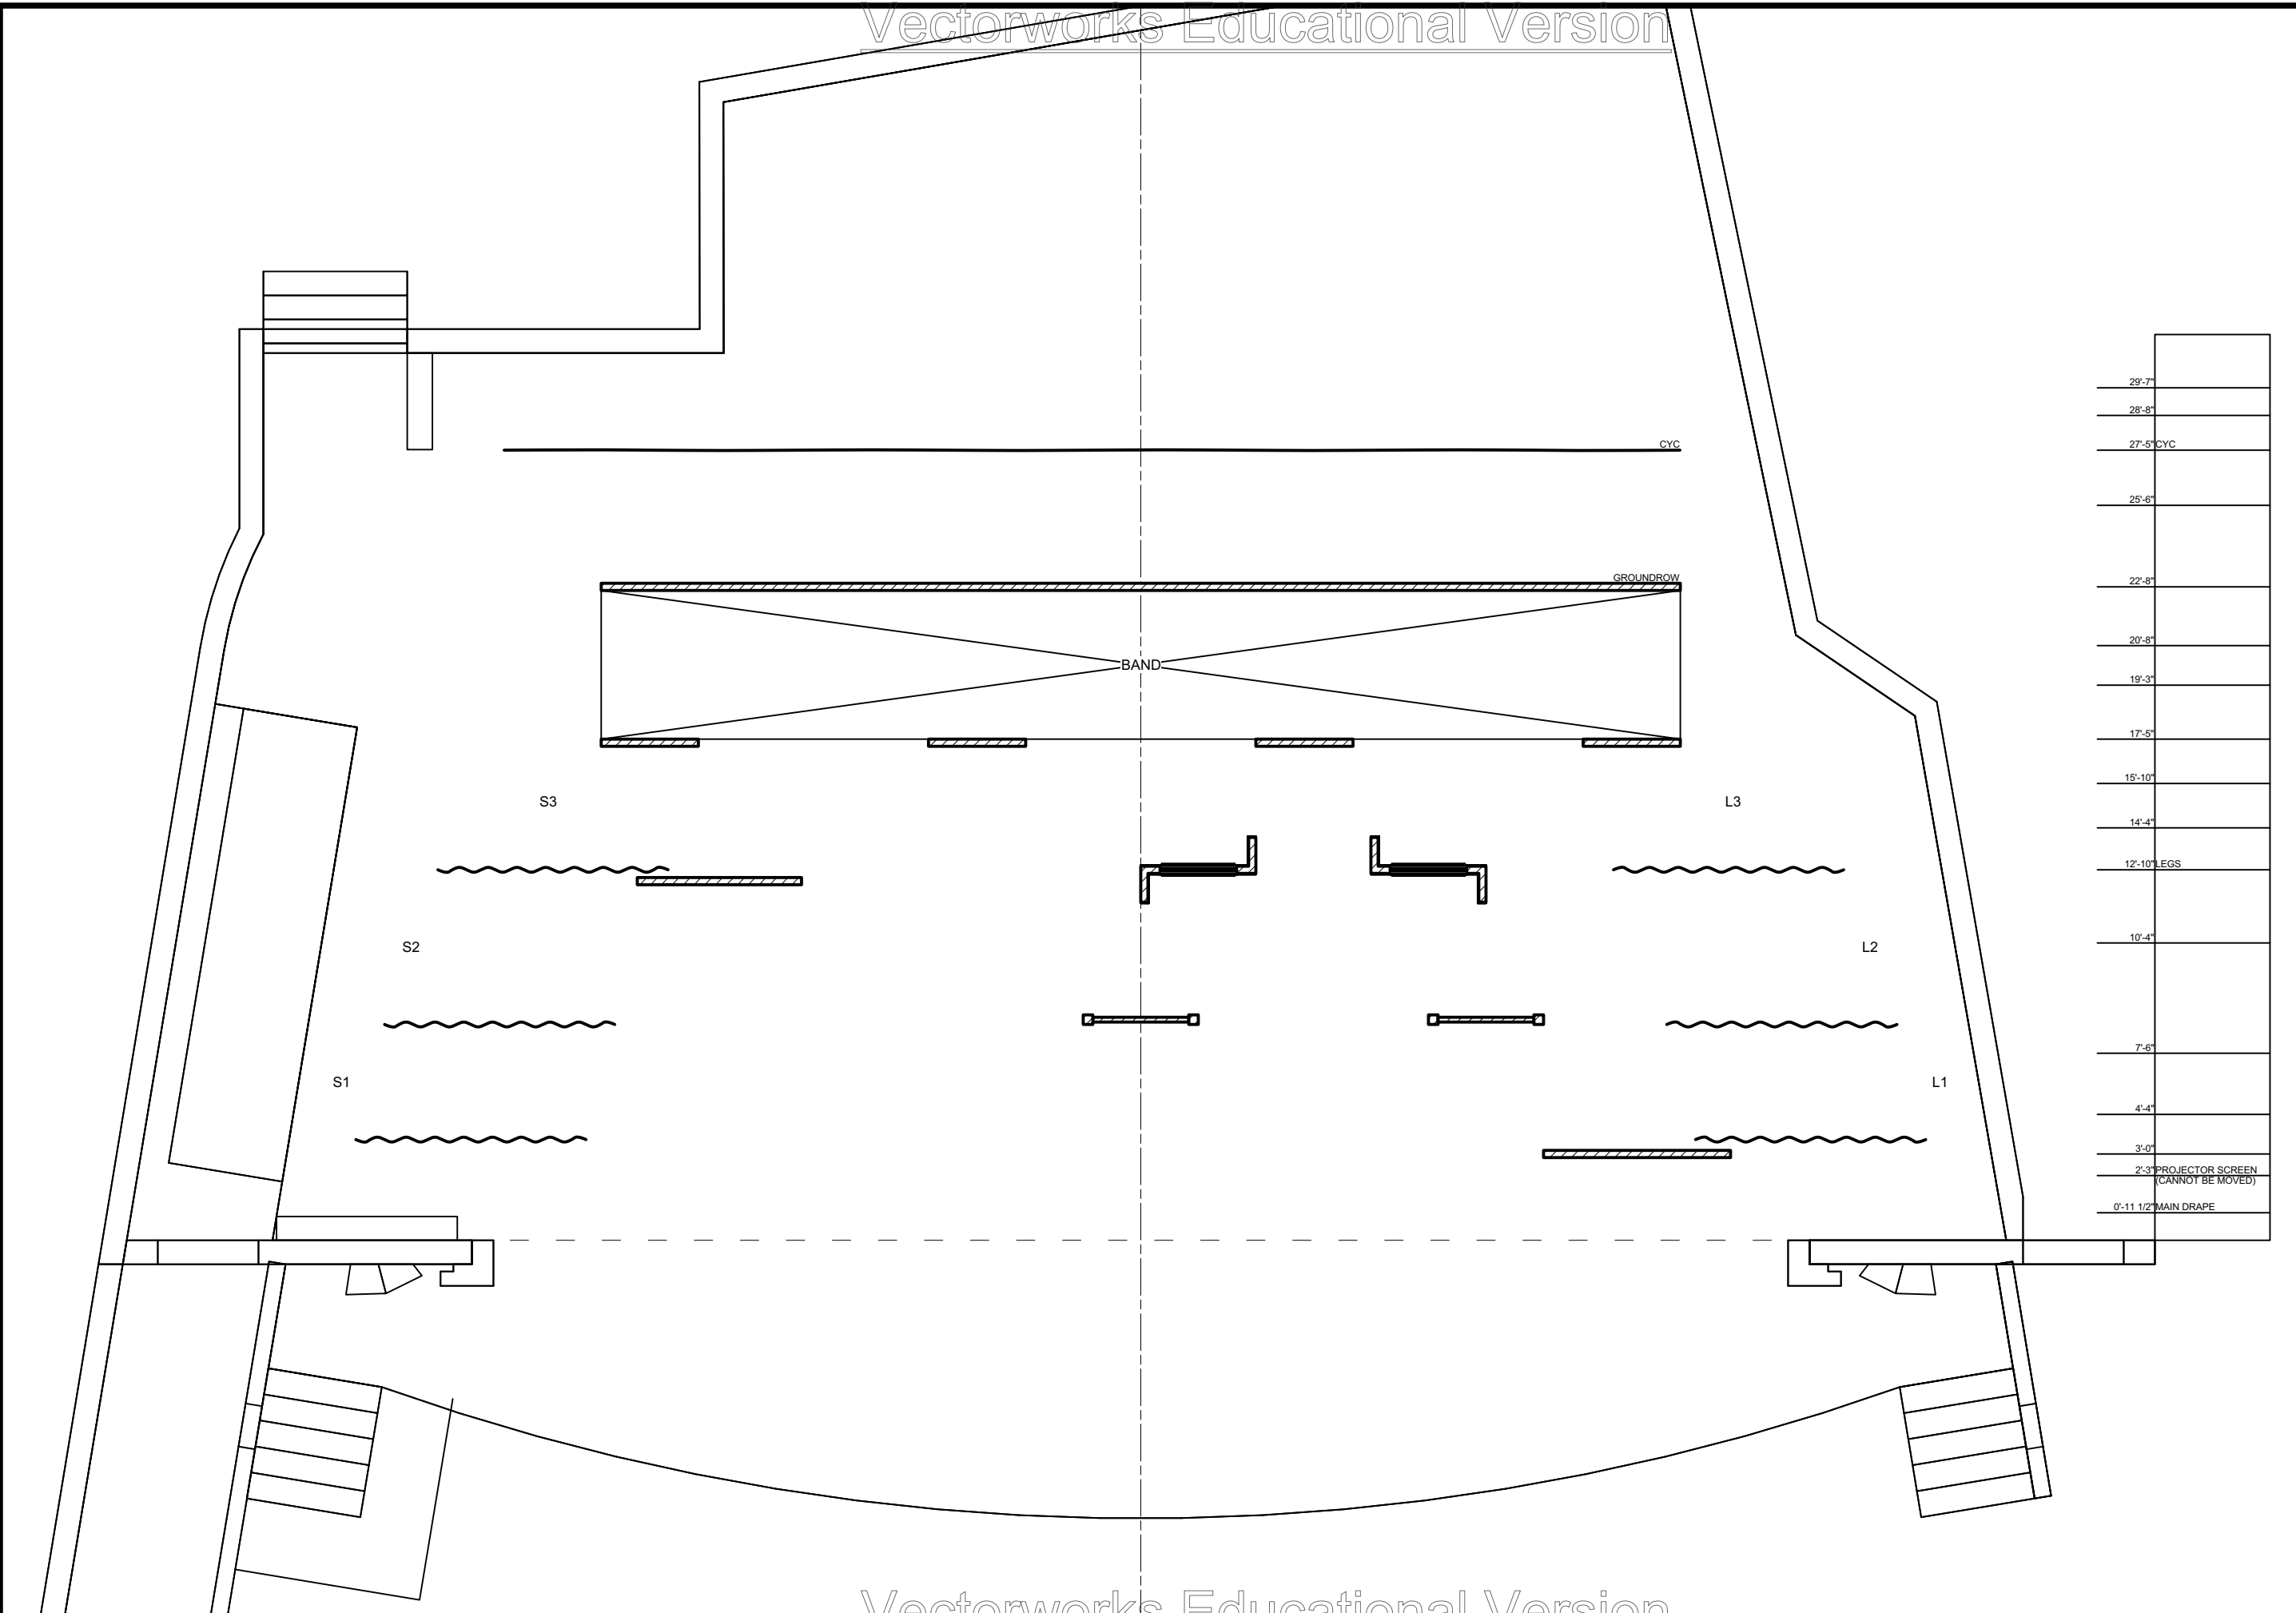

**Disclaimer:**  
 Drawings are only meant only to illustrate ideas and are not to be used for construction. All structural elements shown in the design must be evaluated and stamped by a certified technical director before construction. The designer does not assume any liability for structural integrity in the designs. The company selected to build the designs will assume all liability to its structural integrity and related consumer, crew and performer safety.

*Brandon M. Newton*  
 Scenic Designer Signature

Venue: **Actor's Playhouse**

Stage: **Mainstage Theatre**

Director: **David Arisco**

Technical Director: **Gene Seyffer**

Show Title: **BRIGHT STAR**

Sheet Title: **A2S5 - Raleigh Street (1946)**


Date: **02 Mar 2023**

Scale: **1/4" = 1'-0"**

Designer: **Brandon M. Newton**

Drawn By: **Brandon M. Newton**

Sheet Number: **GP-22** of **0**

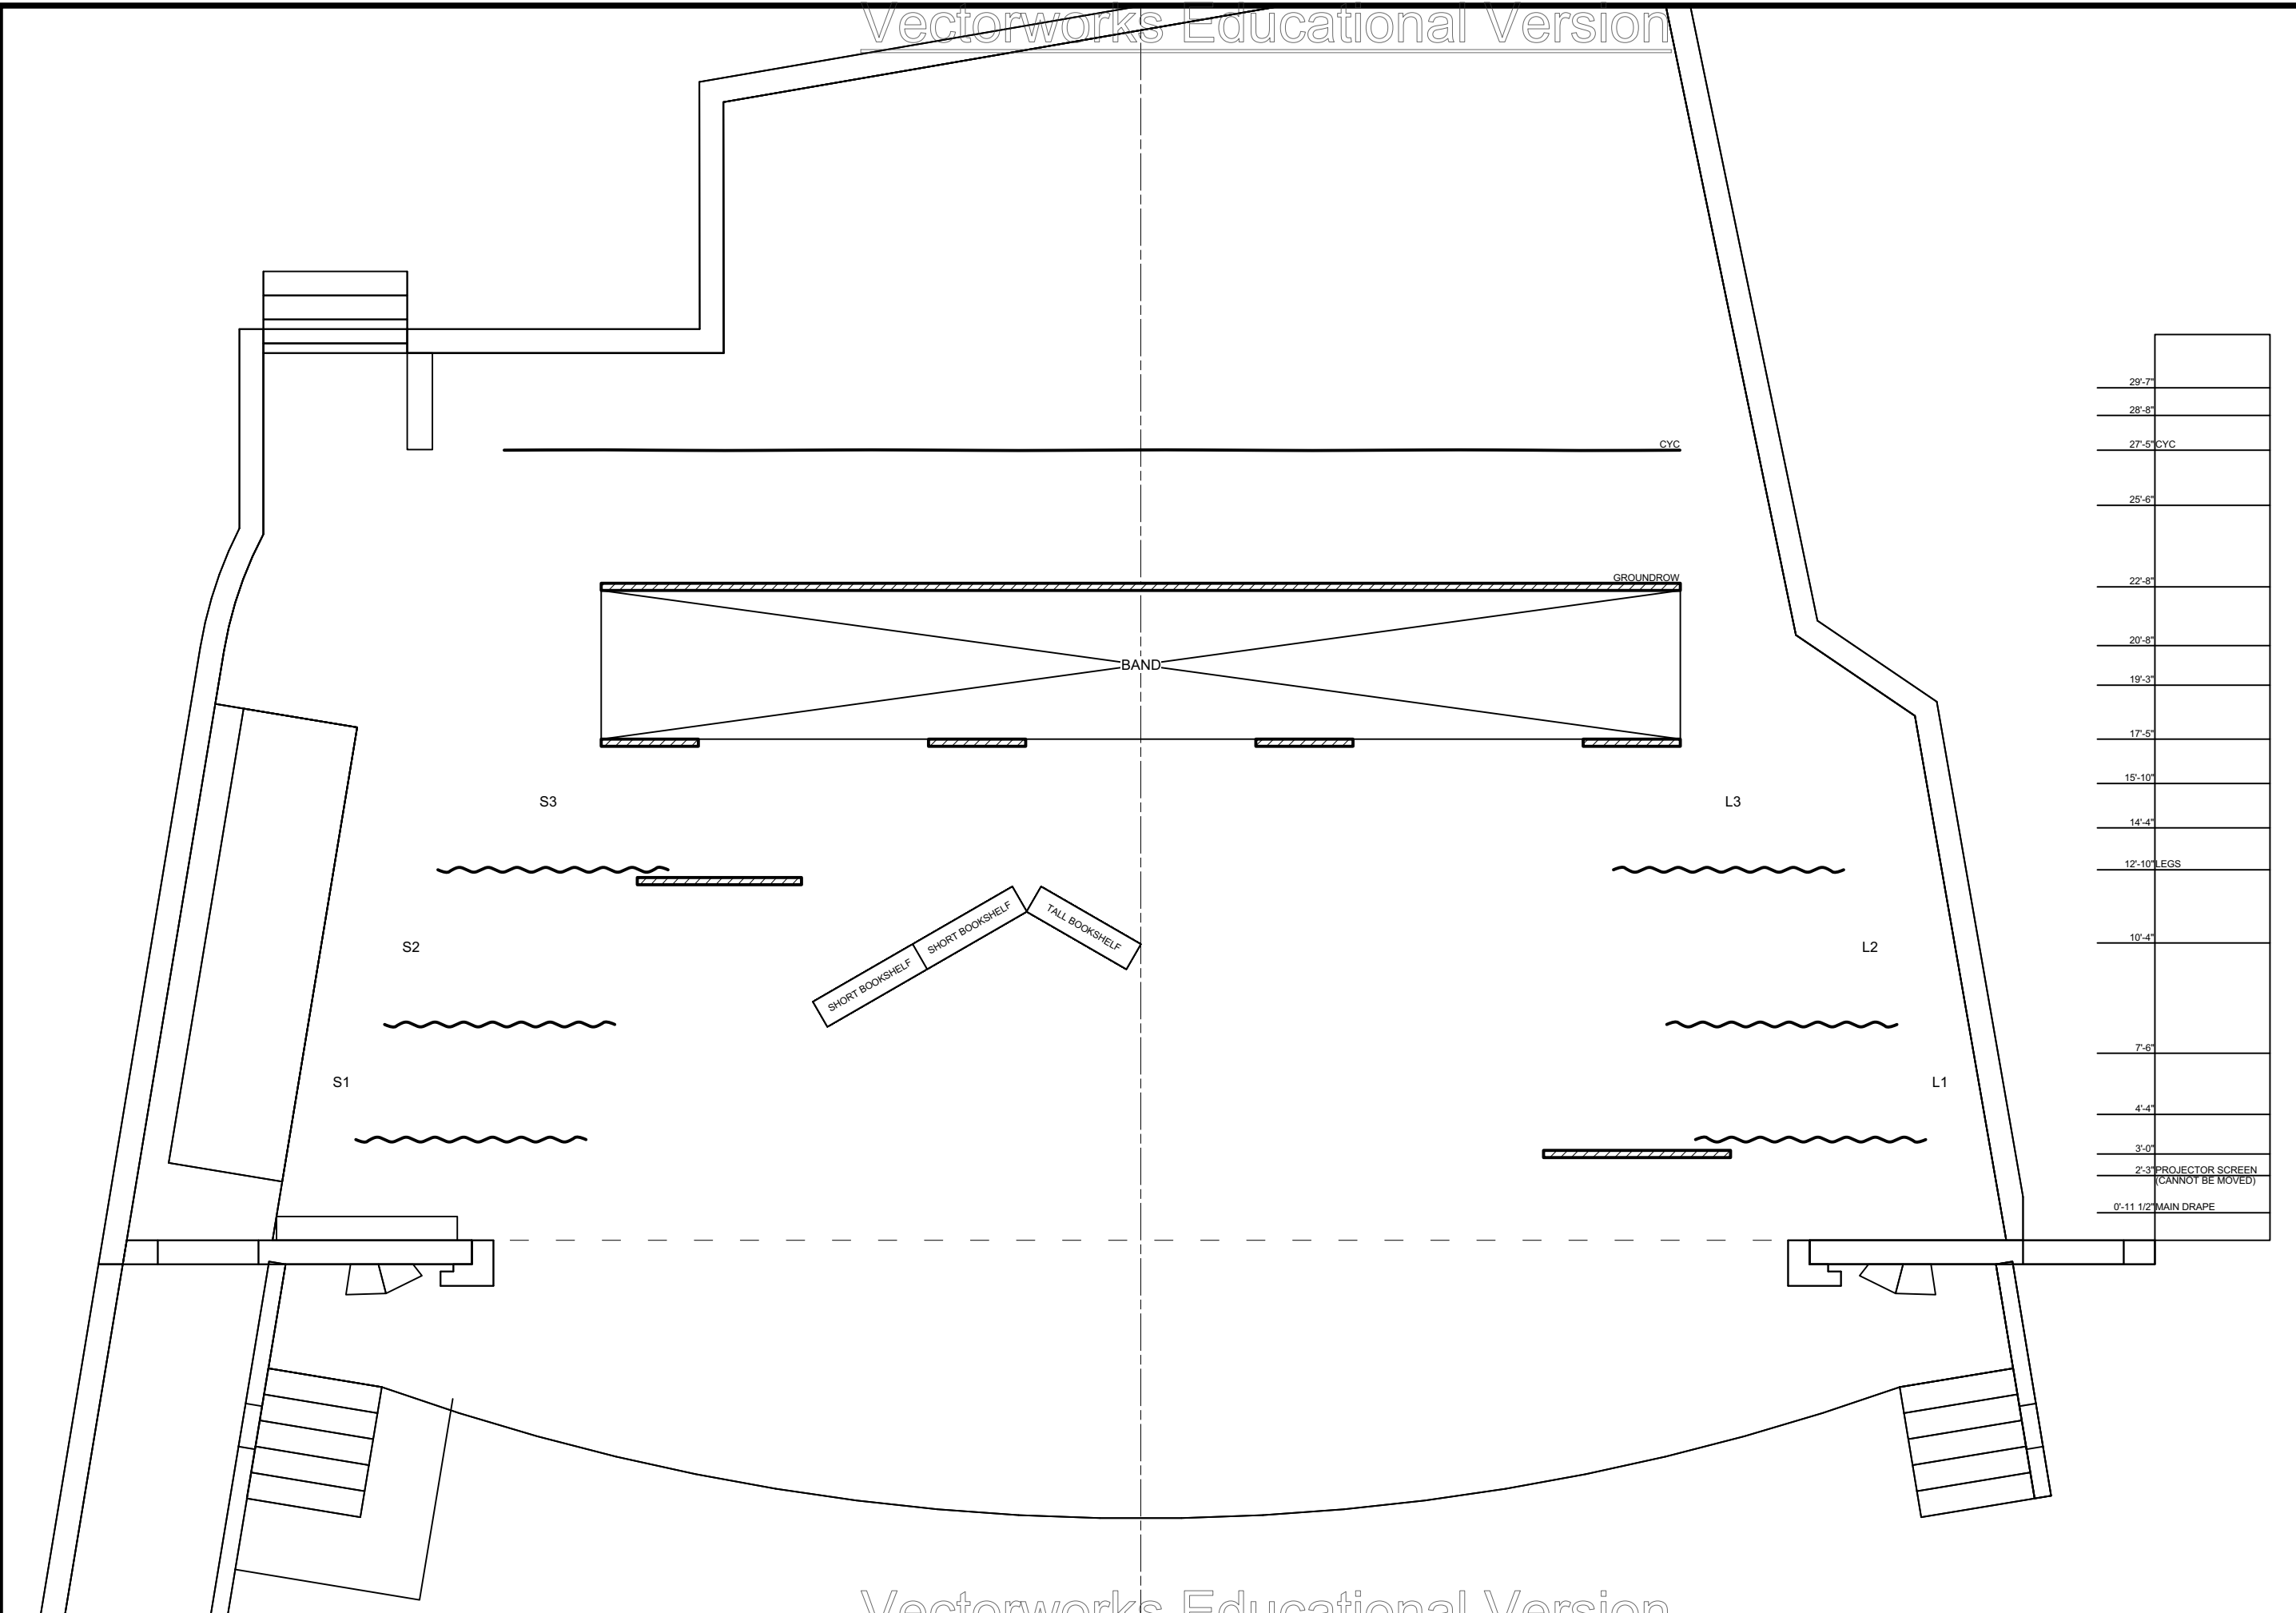


29'-7"	
28'-8"	
27'-5" CYC	
25'-6"	
22'-8"	
20'-8"	
19'-3"	
17'-5"	
15'-10"	
14'-4"	
12'-10" LEGS	
10'-4"	
7'-6"	
4'-4"	
3'-0"	
2'-3" PROJECTOR SCREEN (CANNOT BE MOVED)	
0'-11 1/2" MAIN DRAPE	

**Disclaimer:**  
 Drawings are only meant only to illustrate ideas and are not to be used as a basis for construction. All structural elements shown in the design must be evaluated and stamped by a certified technical director before construction. The designer does not assume any liability for structural integrity in the designs. The company selected to build the designs will assume all liability to its structural integrity and related consumer, crew and performer safety.

*Brandon M. Newton*  
 Scenic Designer Signature

Sheet Title: <b>A2S6 - Margo's Bookshop (1946)</b>	Scale: <b>1/4" = 1'-0"</b>	Drawn By: <b>Brandon M. Newton</b>
Date: <b>02 Mar 2023</b>		Designer: <b>Brandon M. Newton</b>
Venue: <b>Actor's Playhouse</b>		Technical Director: <b>Gene Seyffer</b>
Show Title: <b>BRIGHT STAR</b>		Director: <b>David Arisco</b>
Stage: <b>Mainstage Theatre</b>		

Sheet Number:  
**GP-23** of 0

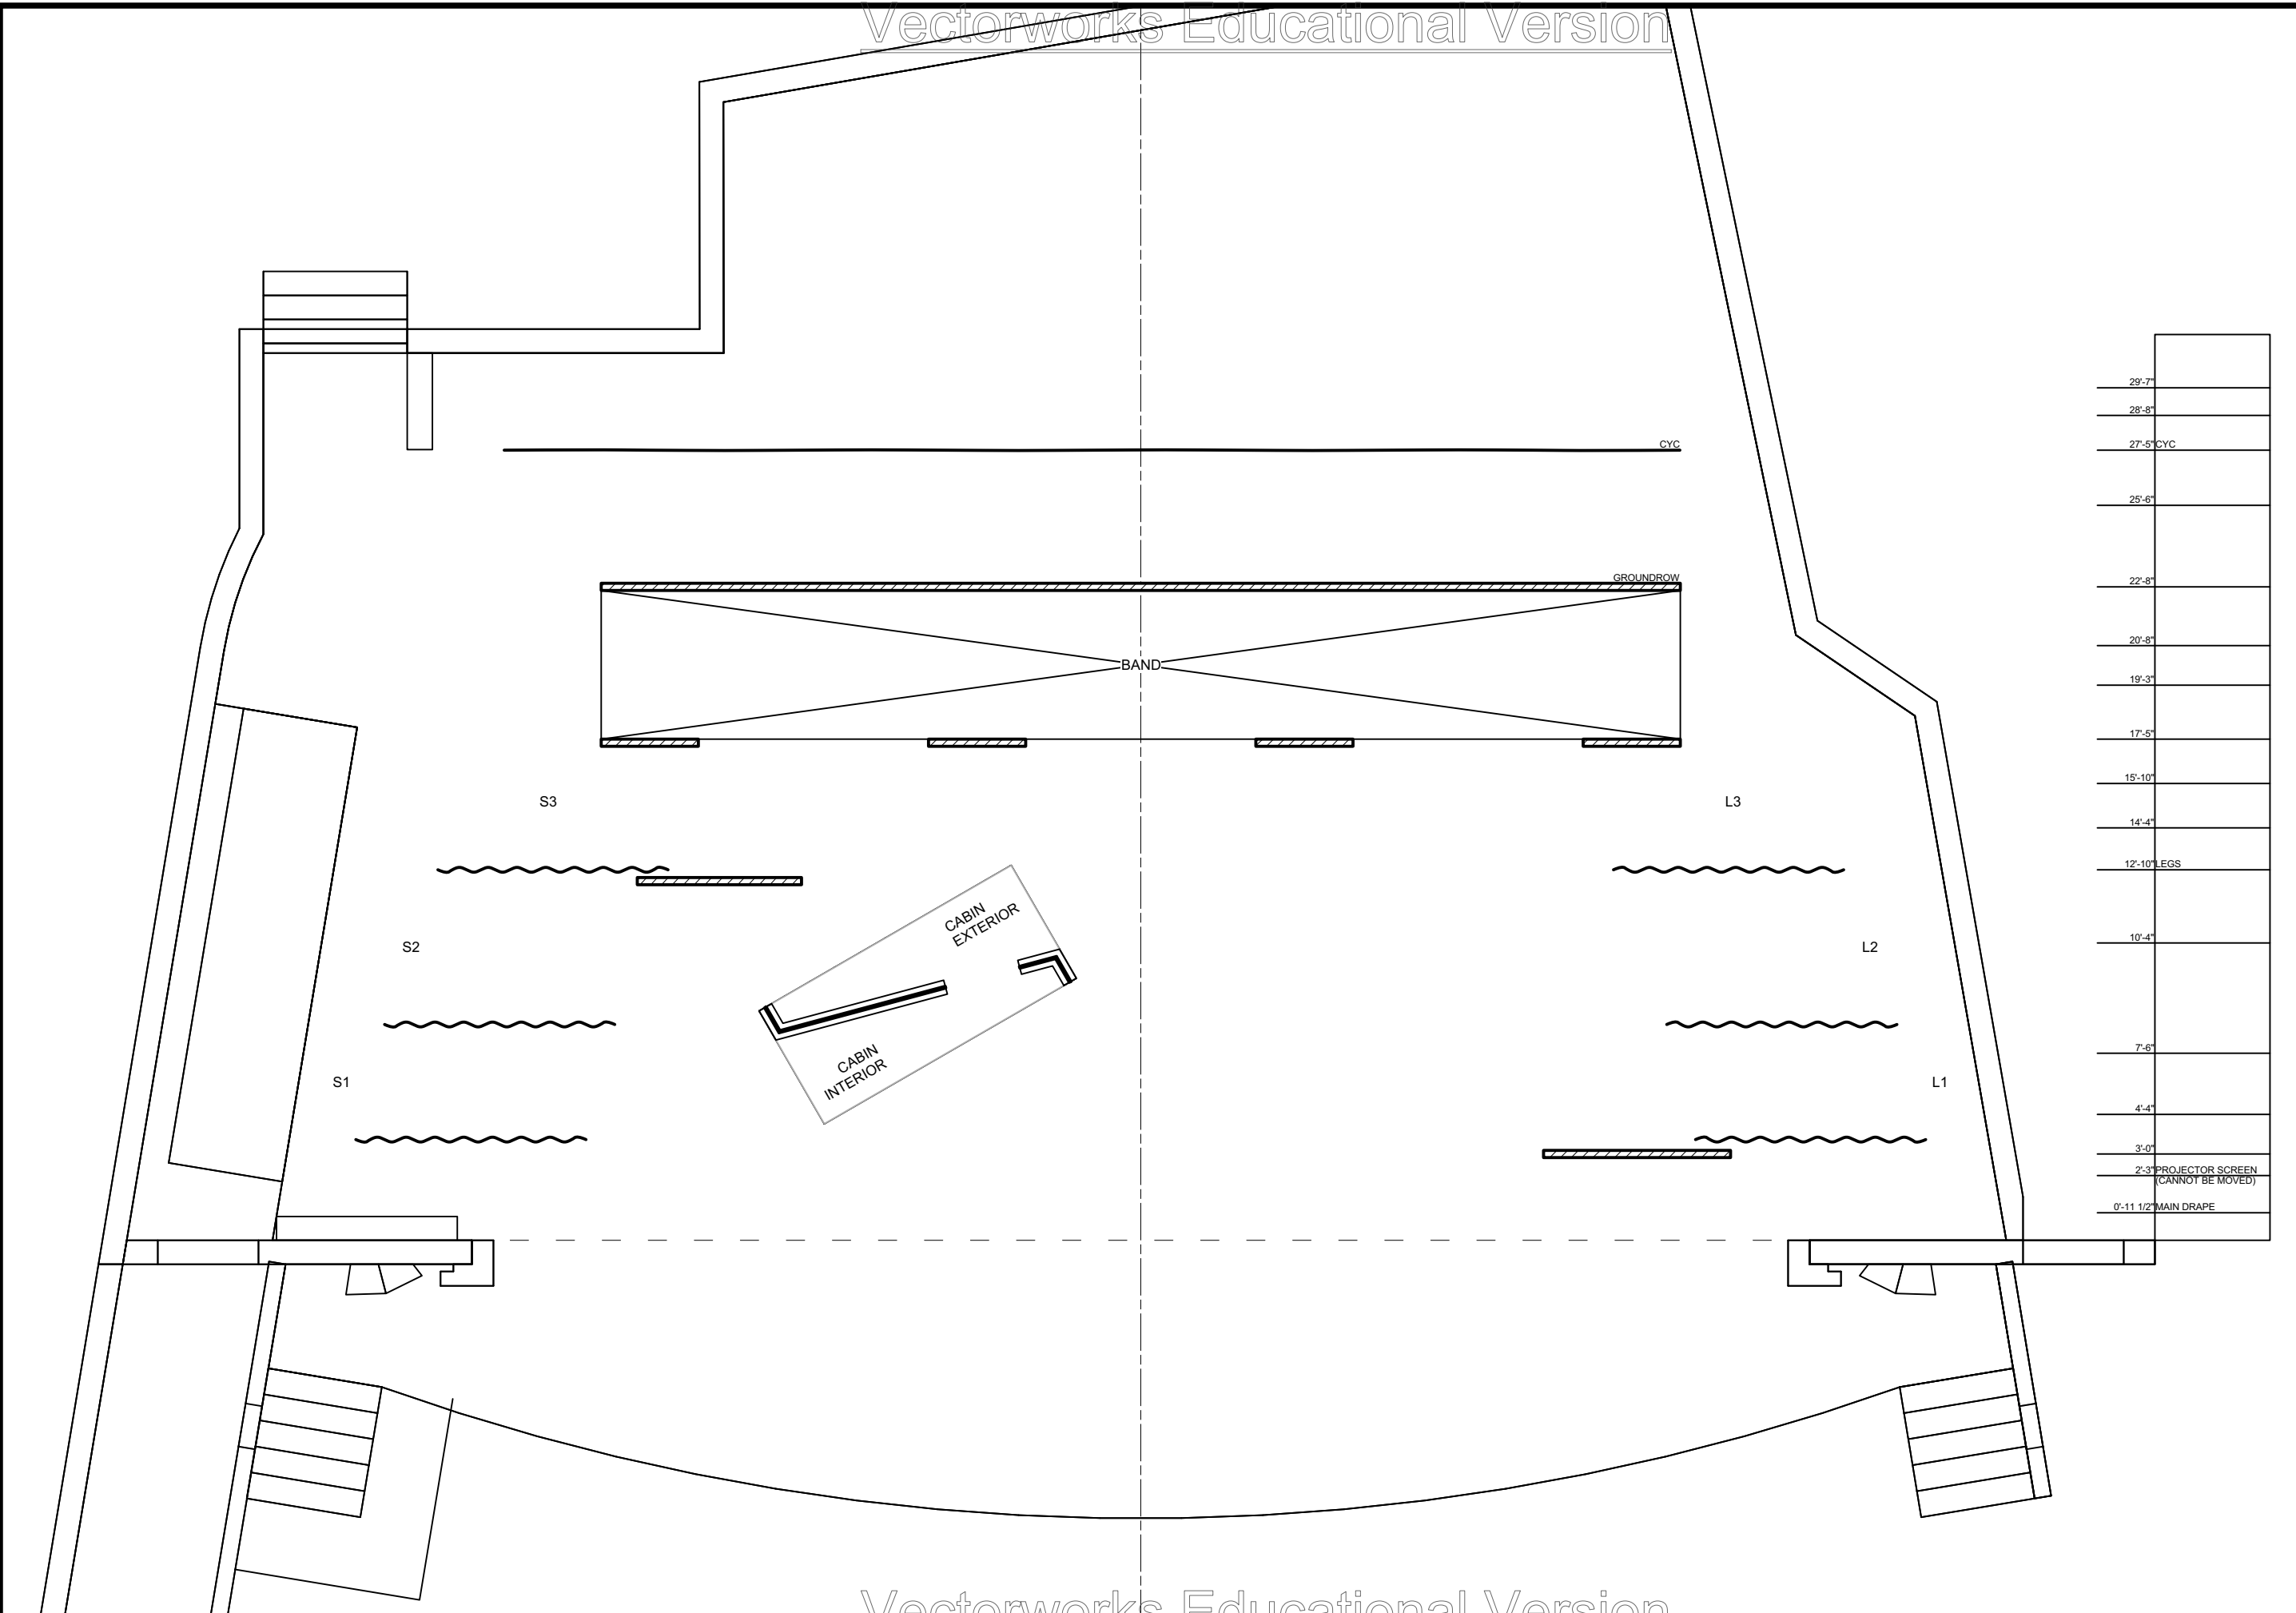

**Disclaimer:**  
 Drawings are only meant only to illustrate ideas and are not to be used as a basis for construction. All structural elements shown in the design must be evaluated and stamped by a certified technical director before construction. The designer does not assume any liability for structural integrity in the designs. The company selected to build the designs will assume all liability to its structural integrity and related consumer, crew and performer safety.

*Brandon M. Newton*  
 Scenic Designer Signature

Venue: **Actor's Playhouse**

Stage: **Mainstage Theatre**

Director: **David Arisco**

Technical Director: **Gene Seyffer**

Show Title: **BRIGHT STAR**

Sheet Title: **A2S7 - Murphy Home (1946)**

Date: **02 Mar 2023**


Designer: **Brandon M. Newton**

Scale: **1/4" = 1'-0"**

Drawn By: **Brandon M. Newton**

Sheet Number: **GP-24** of **0**



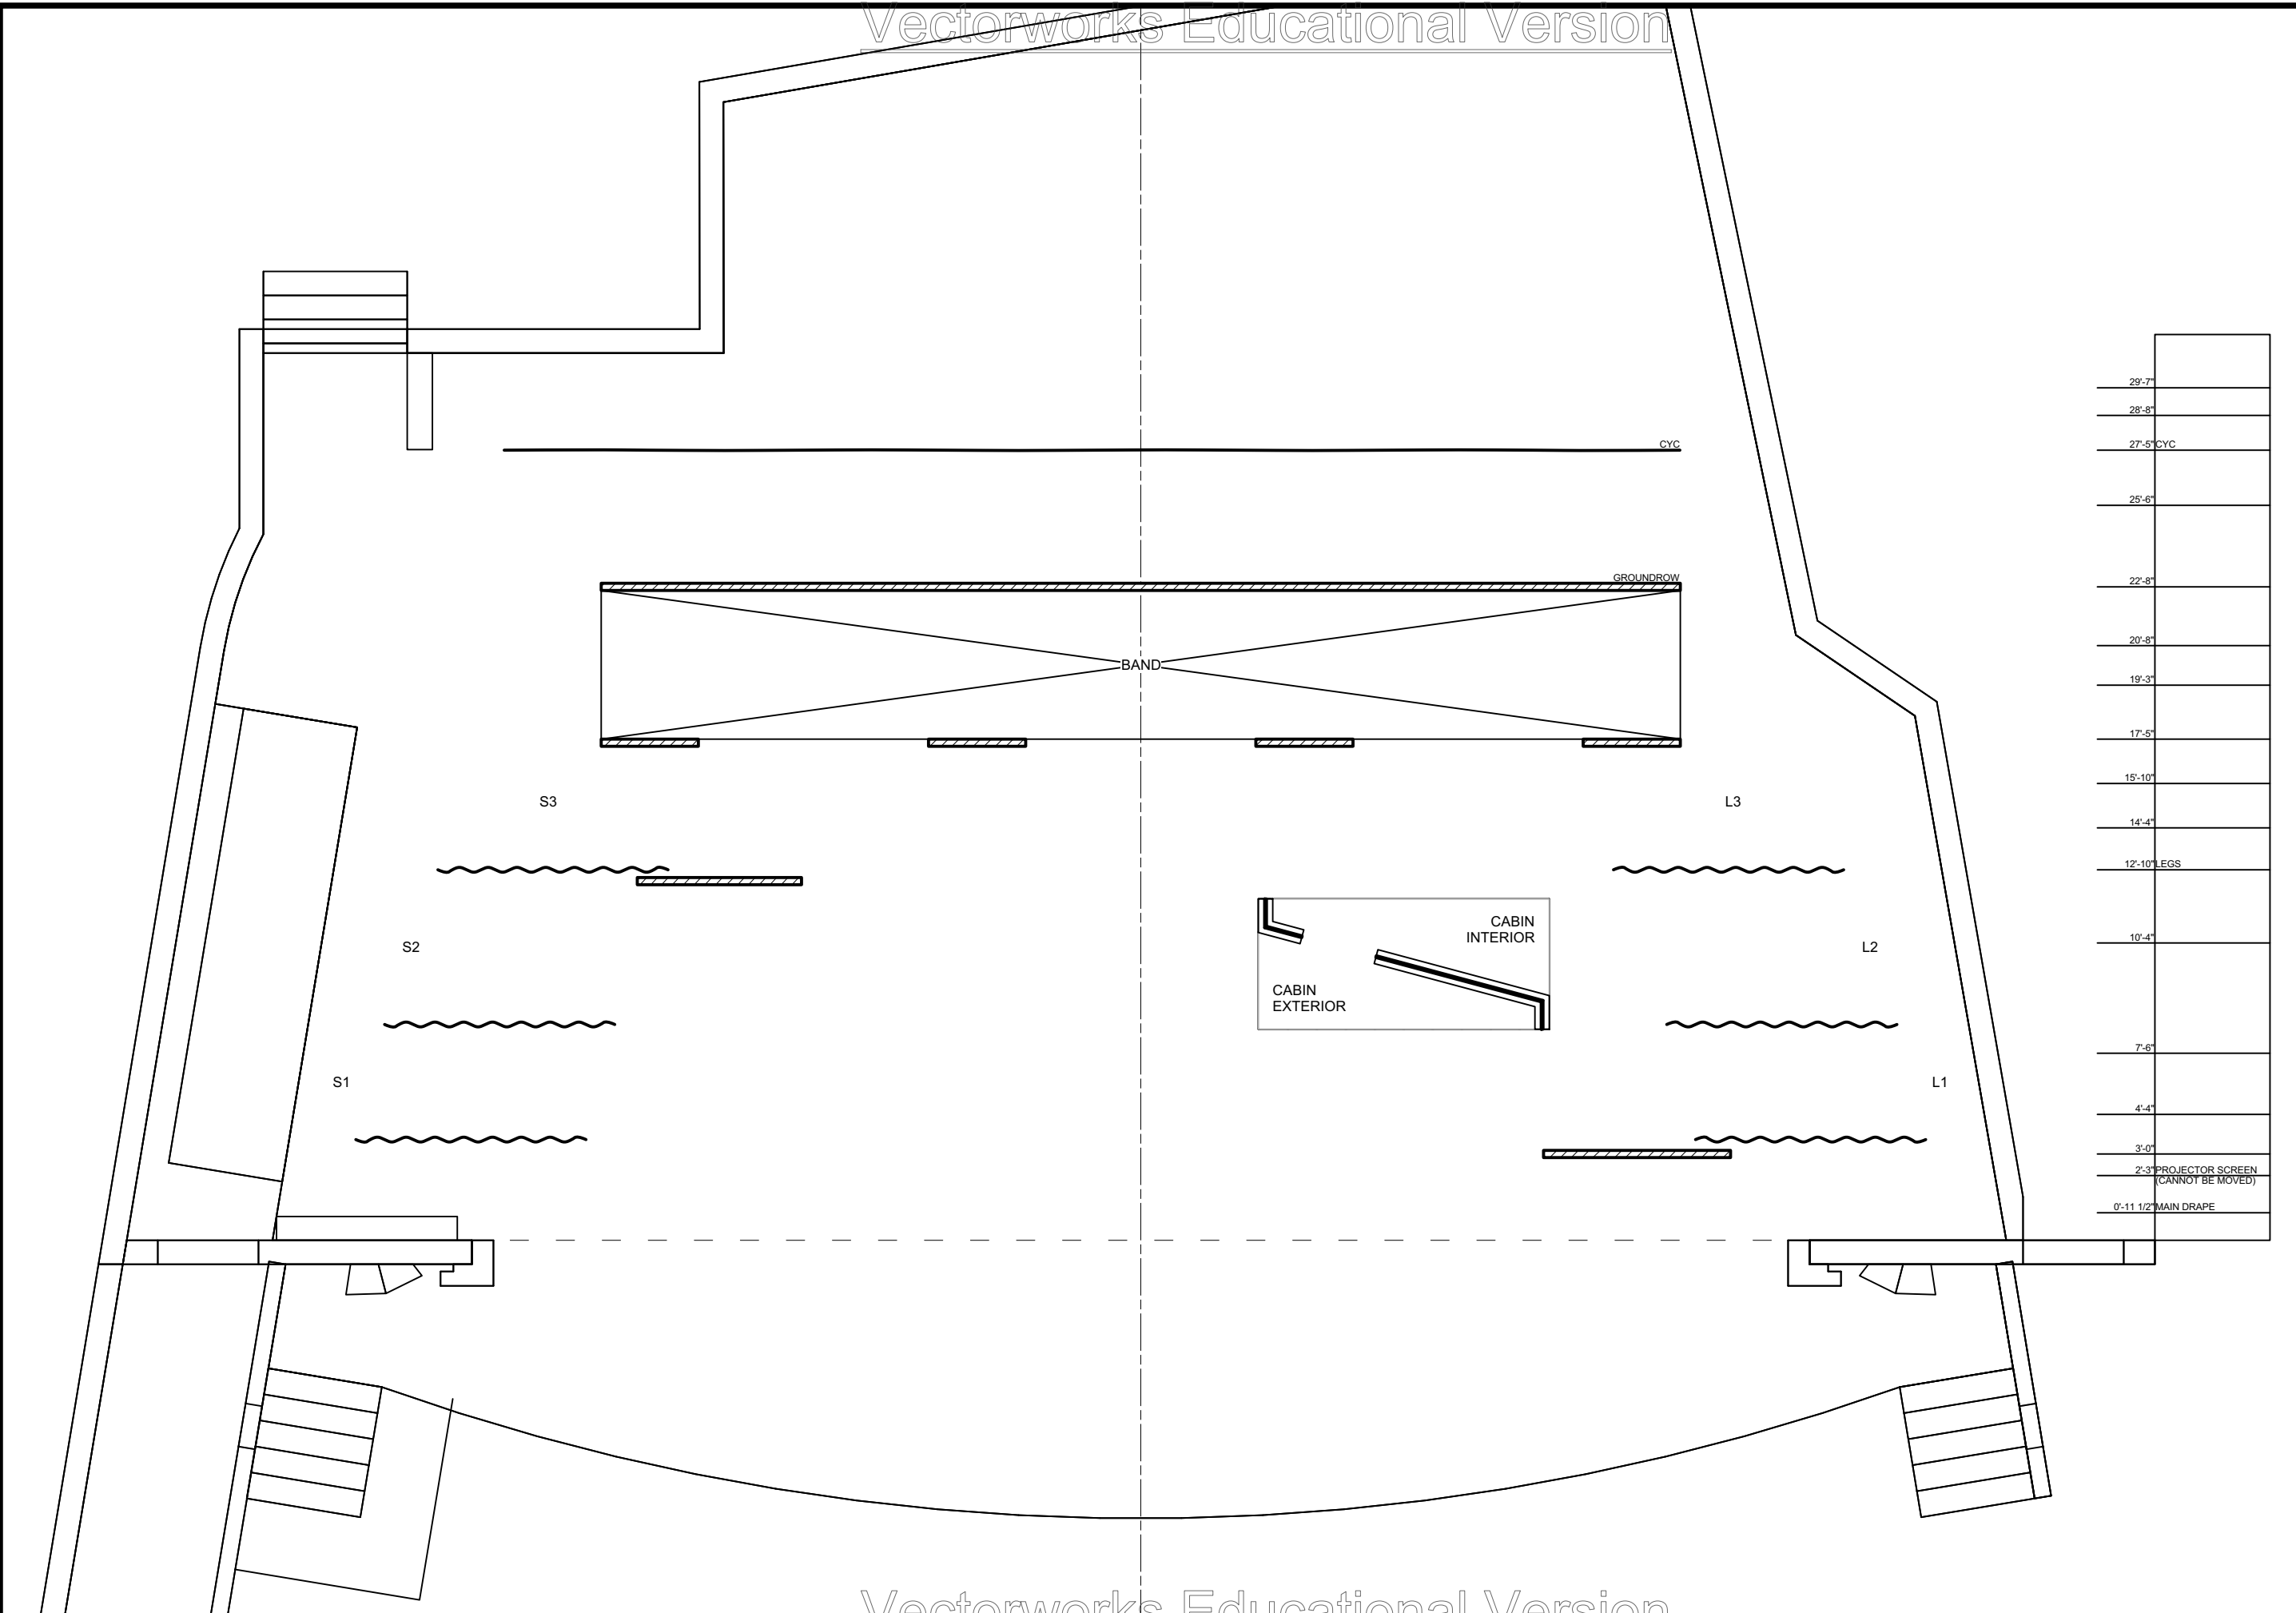


29'-7"
28'-8"
27'-5" CYC
25'-6"
22'-8"
20'-8"
19'-3"
17'-5"
15'-10"
14'-4"
12'-10" LEGS
10'-4"
7'-6"
4'-4"
3'-0"
2'-3" PROJECTOR SCREEN (CANNOT BE MOVED)
0'-11 1/2" MAIN DRAPE

**Disclaimer:**  
 Drawings are only meant only to illustrate ideas and are not to be used for construction. All structural elements shown in the design must be evaluated and stamped by a certified technical director before construction. The designer does not assume any liability for structural integrity in the designs. The company selected to build the designs will assume all liability to its structural integrity and related consumer, crew and performer safety.

*Brandon M. Newton*  
 Scenic Designer Signature

Sheet Title: <b>A2S8 - Billy's Home (1946)</b>	Venue: <b>Actor's Playhouse</b>
Date: <b>02 Mar 2023</b>	Stage: <b>Mainstage Theatre</b>
Scale: <b>1/4" = 1'-0"</b>	Director: <b>David Arisco</b>
Designer: <b>Brandon M. Newton</b>	Technical Director: <b>Gene Seyffer</b>
Drawn By: <b>Brandon M. Newton</b>	

Sheet Number:  
**GP-25** of 0

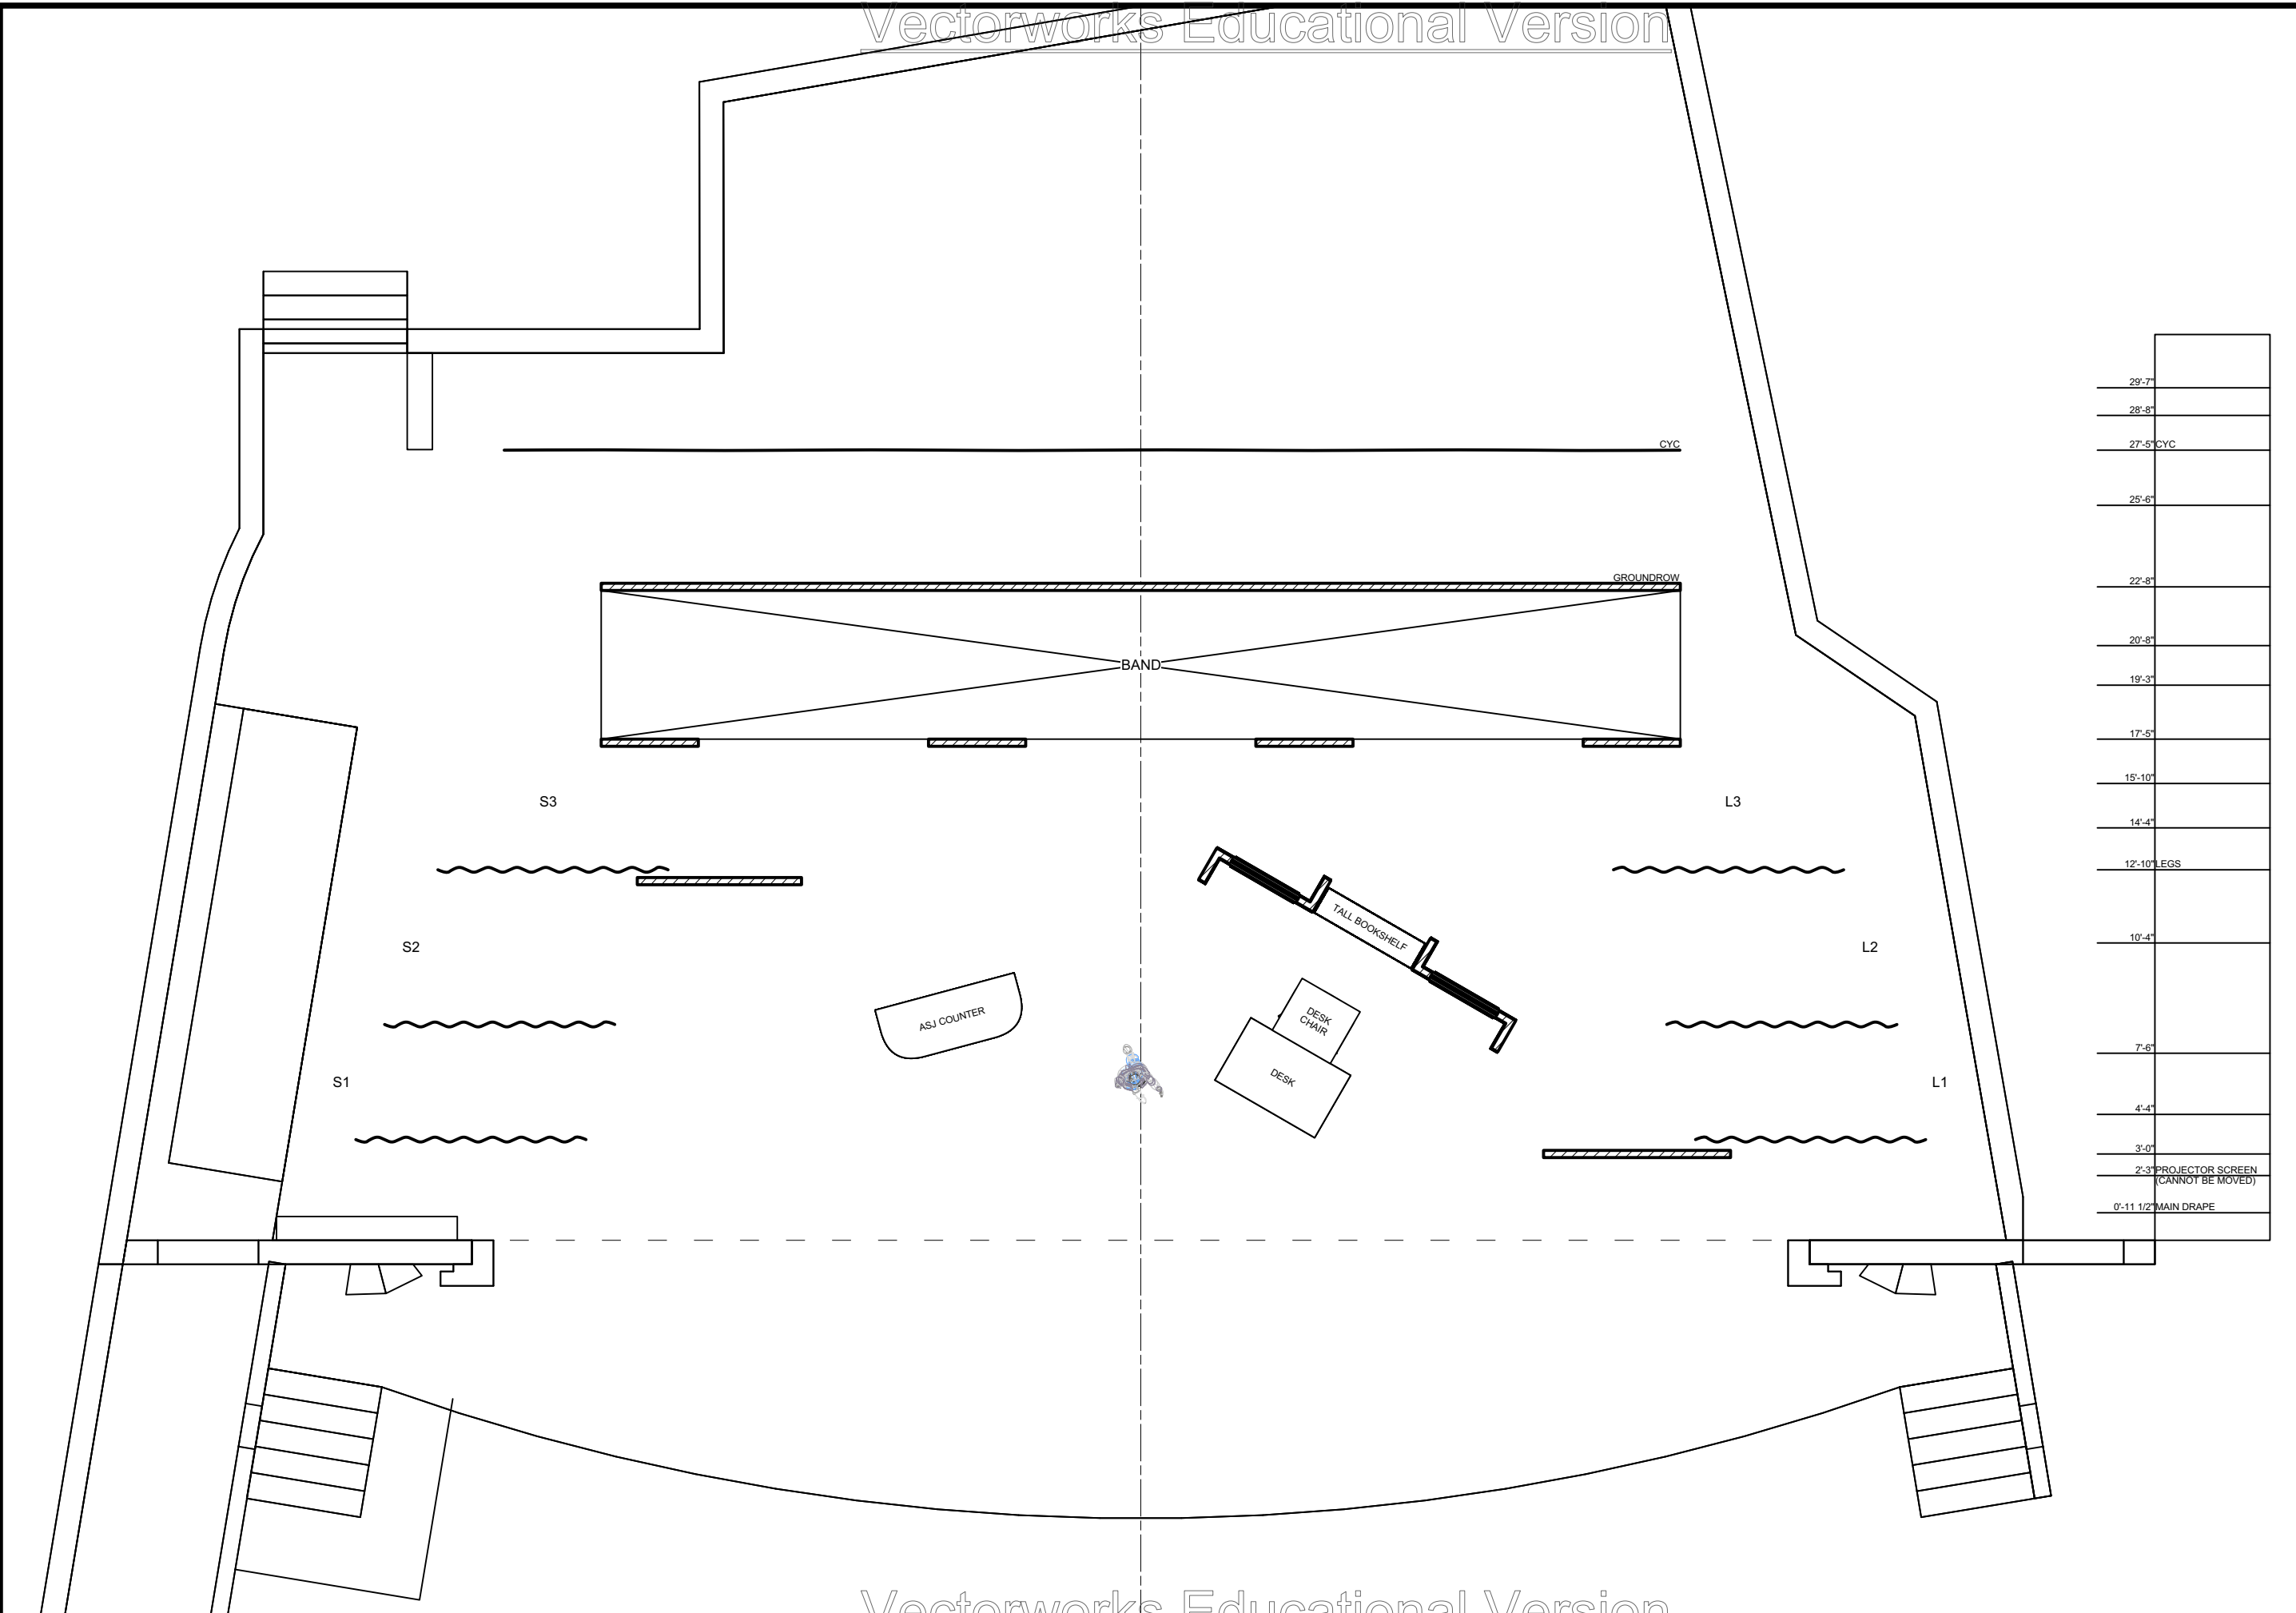

**Disclaimer:**  
 Drawings are only meant only to illustrate ideas and are not to be used for construction. All structural elements shown in the design must be evaluated and stamped by a certified technical director before construction. The designer does not assume any liability for structural integrity in the designs. The company selected to build the designs will assume all liability to its structural integrity and related consumer, crew and performer safety.

*Brandon M. Newton*  
 Scenic Designer Signature

Venue: **Actor's Playhouse**

Stage: **Mainstage Theatre**

Director: **David Arisco**

Technical Director: **Gene Seyffer**

Show Title: **BRIGHT STAR**

Sheet Title: **A2S9 - Asheville Southern Journal (1946)**


Date: **02 Mar 2023**

Scale: **1/4" = 1'-0"**

Designer: **Brandon M. Newton**

Drawn By: **Brandon M. Newton**

Sheet Number: **GP-26** of **0**

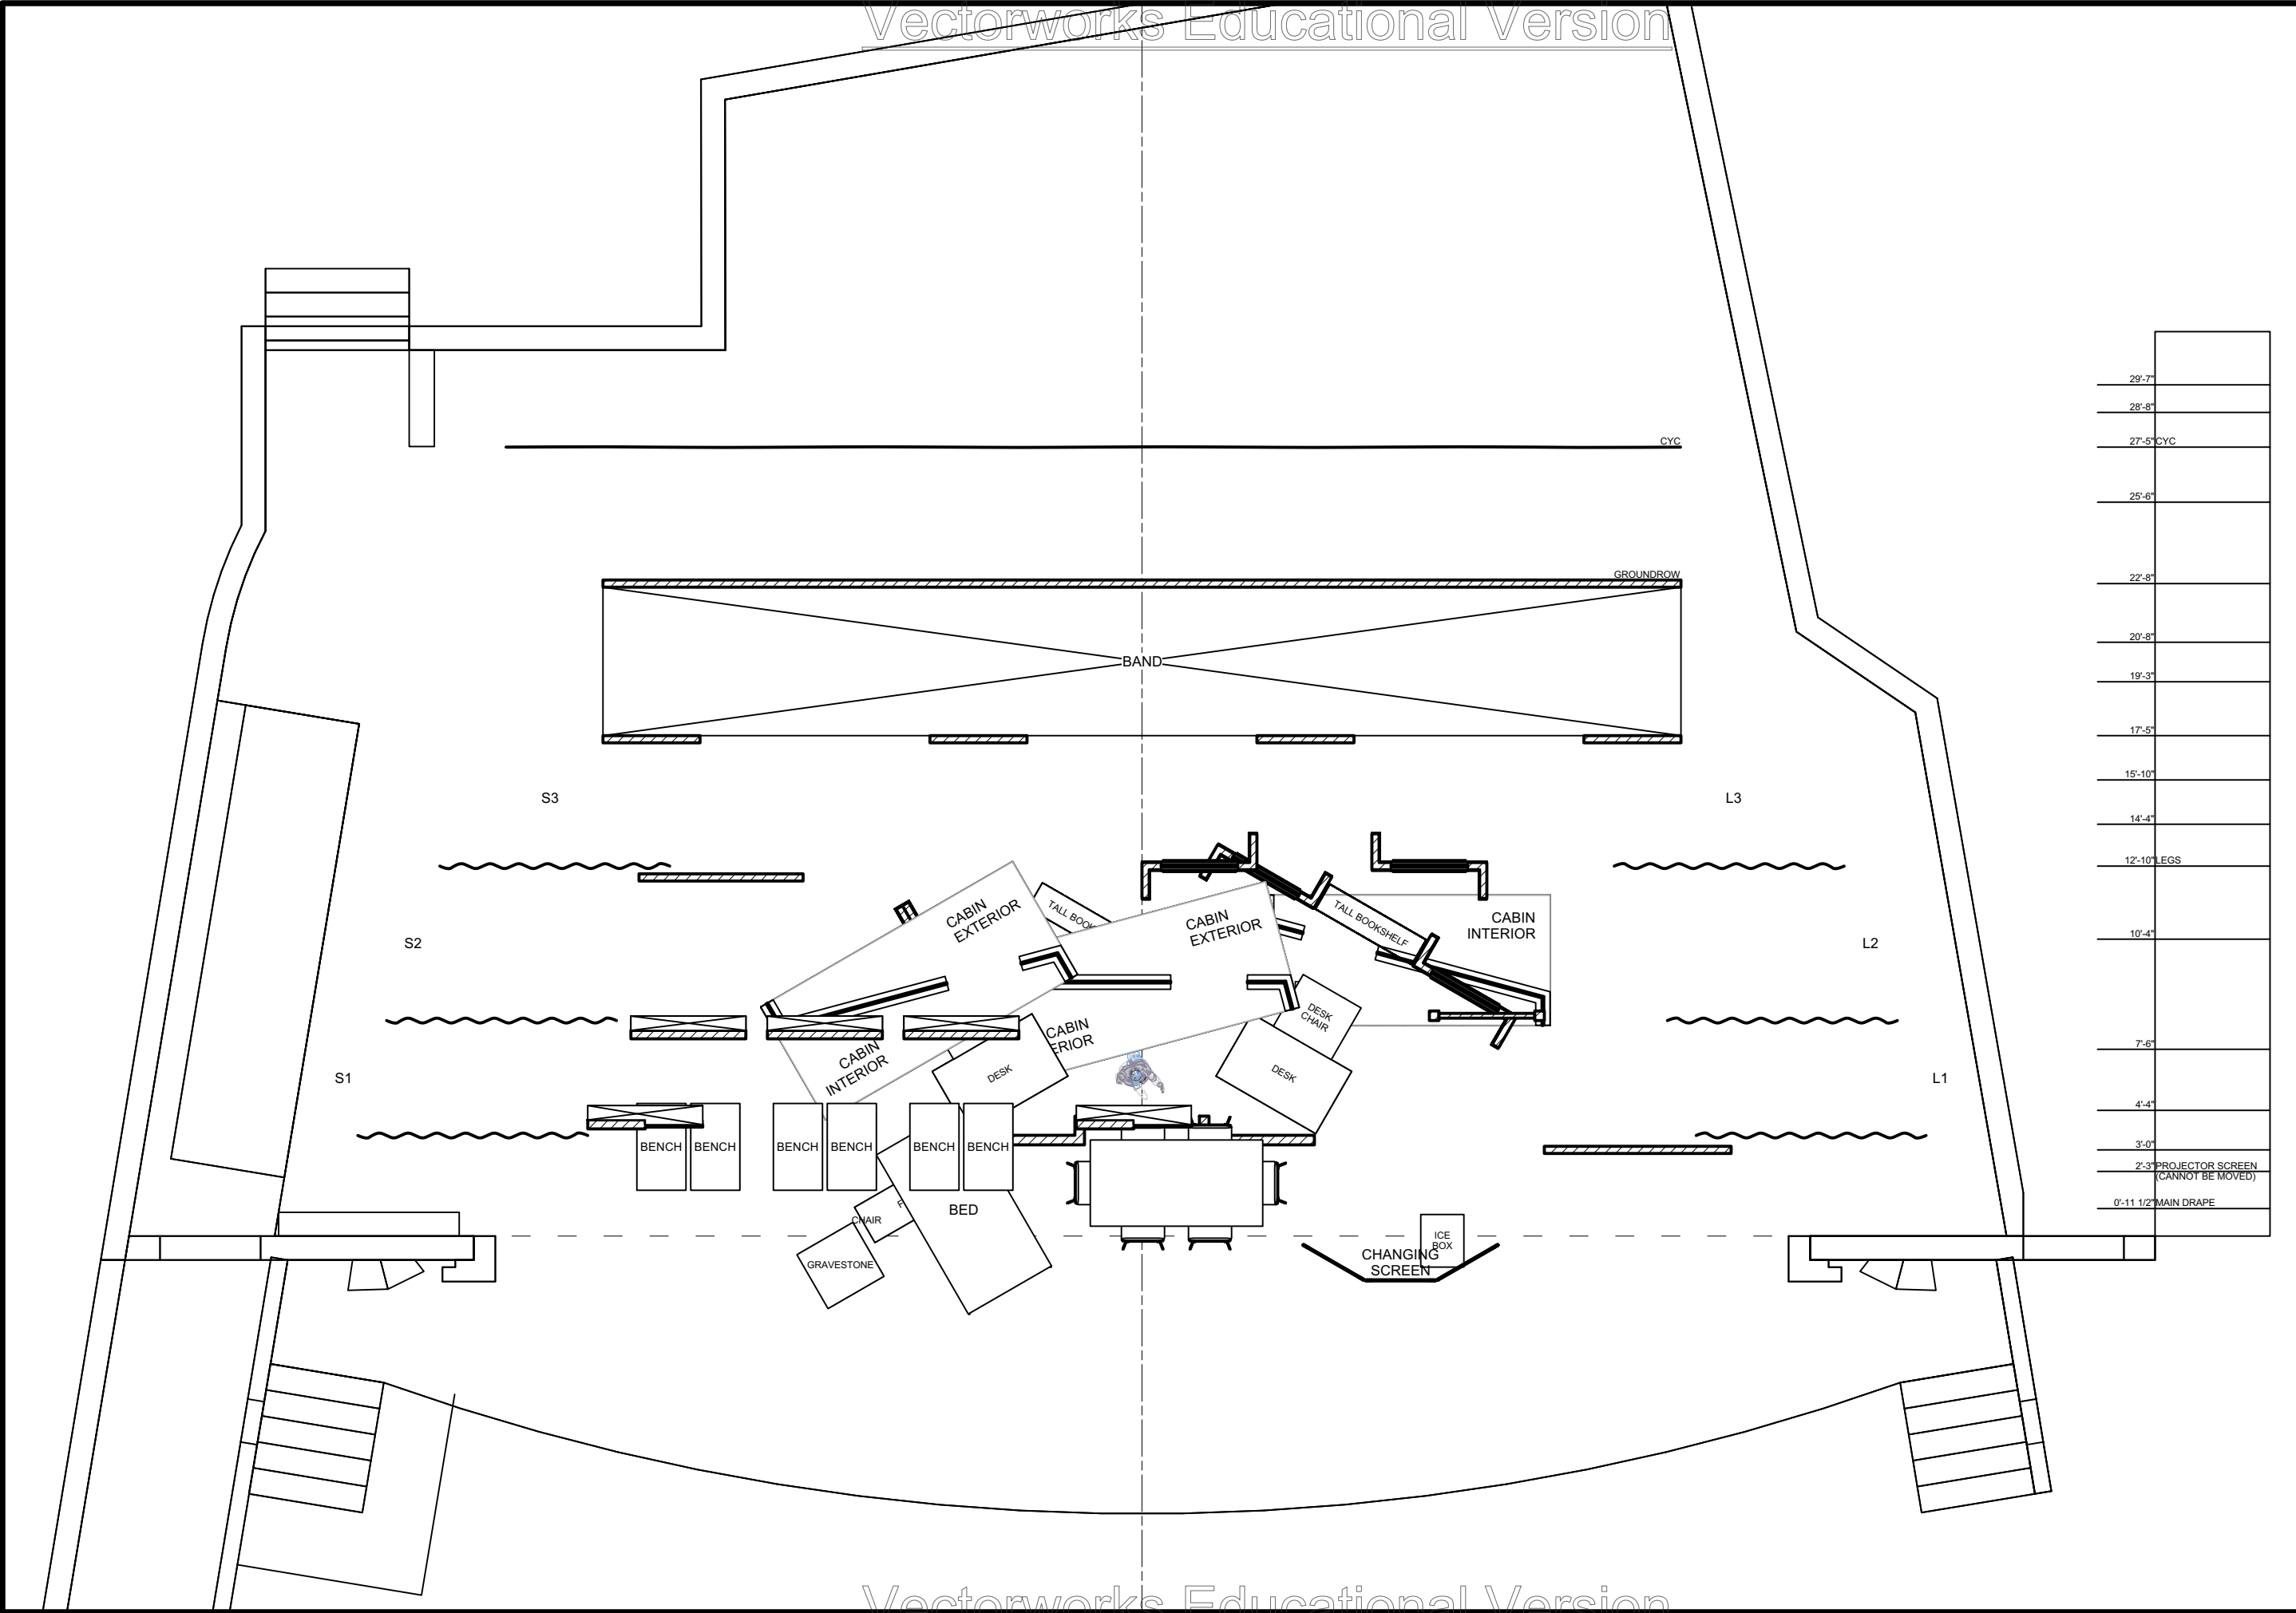

29'-7"
28'-8"
27'-5" CYC
25'-6"
22'-8"
20'-8"
19'-3"
17'-5"
15'-10"
14'-4"
12'-10" LEGS
10'-4"
7'-6"
4'-4"
3'-0"
2'-3" PROJECTOR SCREEN (CANNOT BE MOVED)
0'-11 1/2" MAIN DRAPE

**Disclaimer:**  
 Drawings are only meant only to illustrate ideas and are not to be used for construction. All structural elements shown in the design must be evaluated and stamped by a certified technical director before construction. The designer does not assume any liability for structural integrity in the designs. The company selected to build the designs will assume all liability to its structural integrity and related consumer, crew and performer safety.

*Brandon M. Newton*  
 Scenic Designer Signature

Venue: **Actor's Playhouse**

Stage: **Mainstage Theatre**

Director: **David Arisco**

Technical Director: **Gene Seyffer**

Show Title: **BRIGHT STAR**

Sheet Title: **Composite Groundplan**

Date: **02 Mar 2023**

Scale: **1/4" = 1'-0"**


Designer: **Brandon M. Newton**

Drawn By: **Brandon M. Newton**

Sheet Number: **GP-0**

of: **0**

SCENIC UNITS AND FURNITURE IN THIS AREA ARE ACT-SPECIFIC AND DO NOT NEED TO BE IN THE WINGS DURING THE ACT THEY ARE NOT IN.

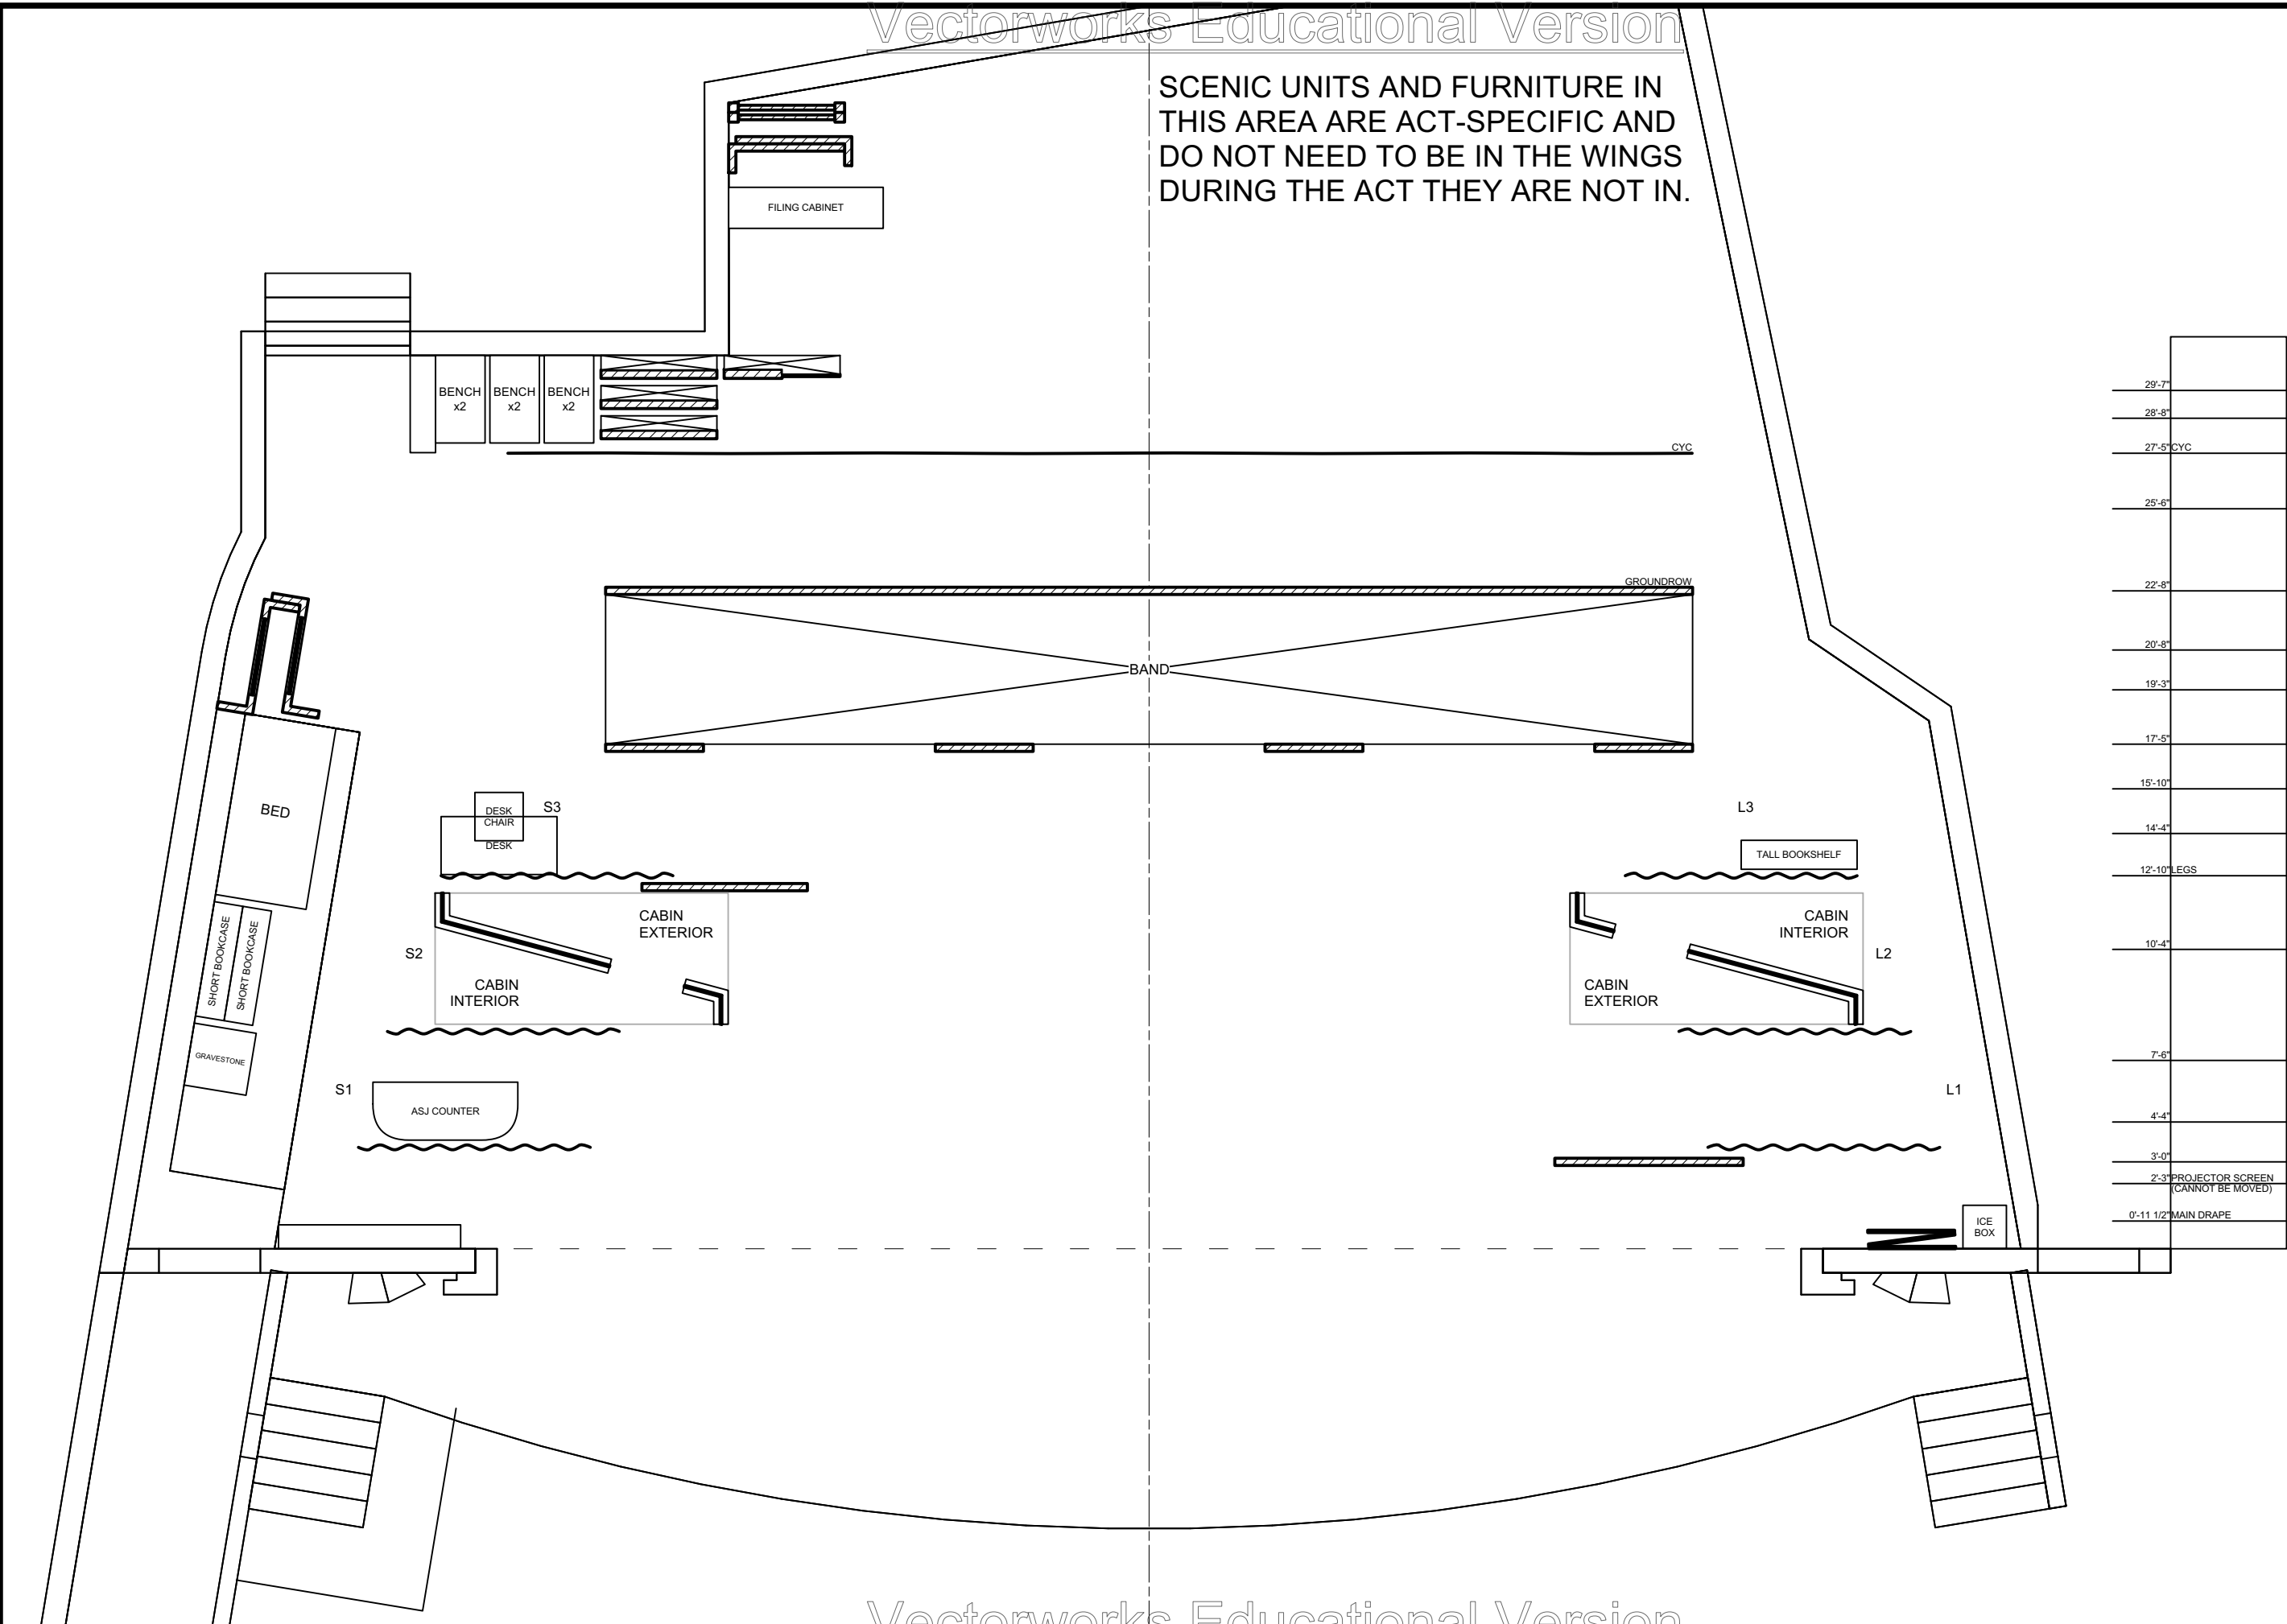

29'-7"
28'-8"
27'-5" CYC
25'-6"
22'-8"
20'-8"
19'-3"
17'-5"
15'-10"
14'-4"
12'-10" LEGS
10'-4"
7'-6"
4'-4"
3'-0"
2'-3" PROJECTOR SCREEN (CANNOT BE MOVED)
0'-11 1/2" MAIN DRAPE

**Disclaimer:**  
 Drawings are only meant only to illustrate ideas and are not intended to be used as a structural or electrical plan. The designer must be evaluated and stamped by a certified technical director before construction. The designer does not assume any liability for structural integrity in the designs. The company selected to build the designs will assume all liability to its structural integrity and related consumer, crew and performer safety.


*Brandon M. Newton*  
 Scenic Designer Signature

Venue: Actor's Playhouse  
 Stage: Mainstage Theatre  
 Director: David Arisco  
 Technical Director: Gene Seyffer

Show Title: BRIGHT STAR

Sheet Title: A1 Offstage Positions  
 Date: 02 Mar 2023  
 Designer: Brandon M. Newton  
 Scale: 1/4" = 1'-0"  
 Drawn By: Brandon M. Newton

SCENIC UNITS AND FURNITURE IN THIS AREA ARE ACT-SPECIFIC AND DO NOT NEED TO BE IN THE WINGS DURING THE ACT THEY ARE NOT IN.

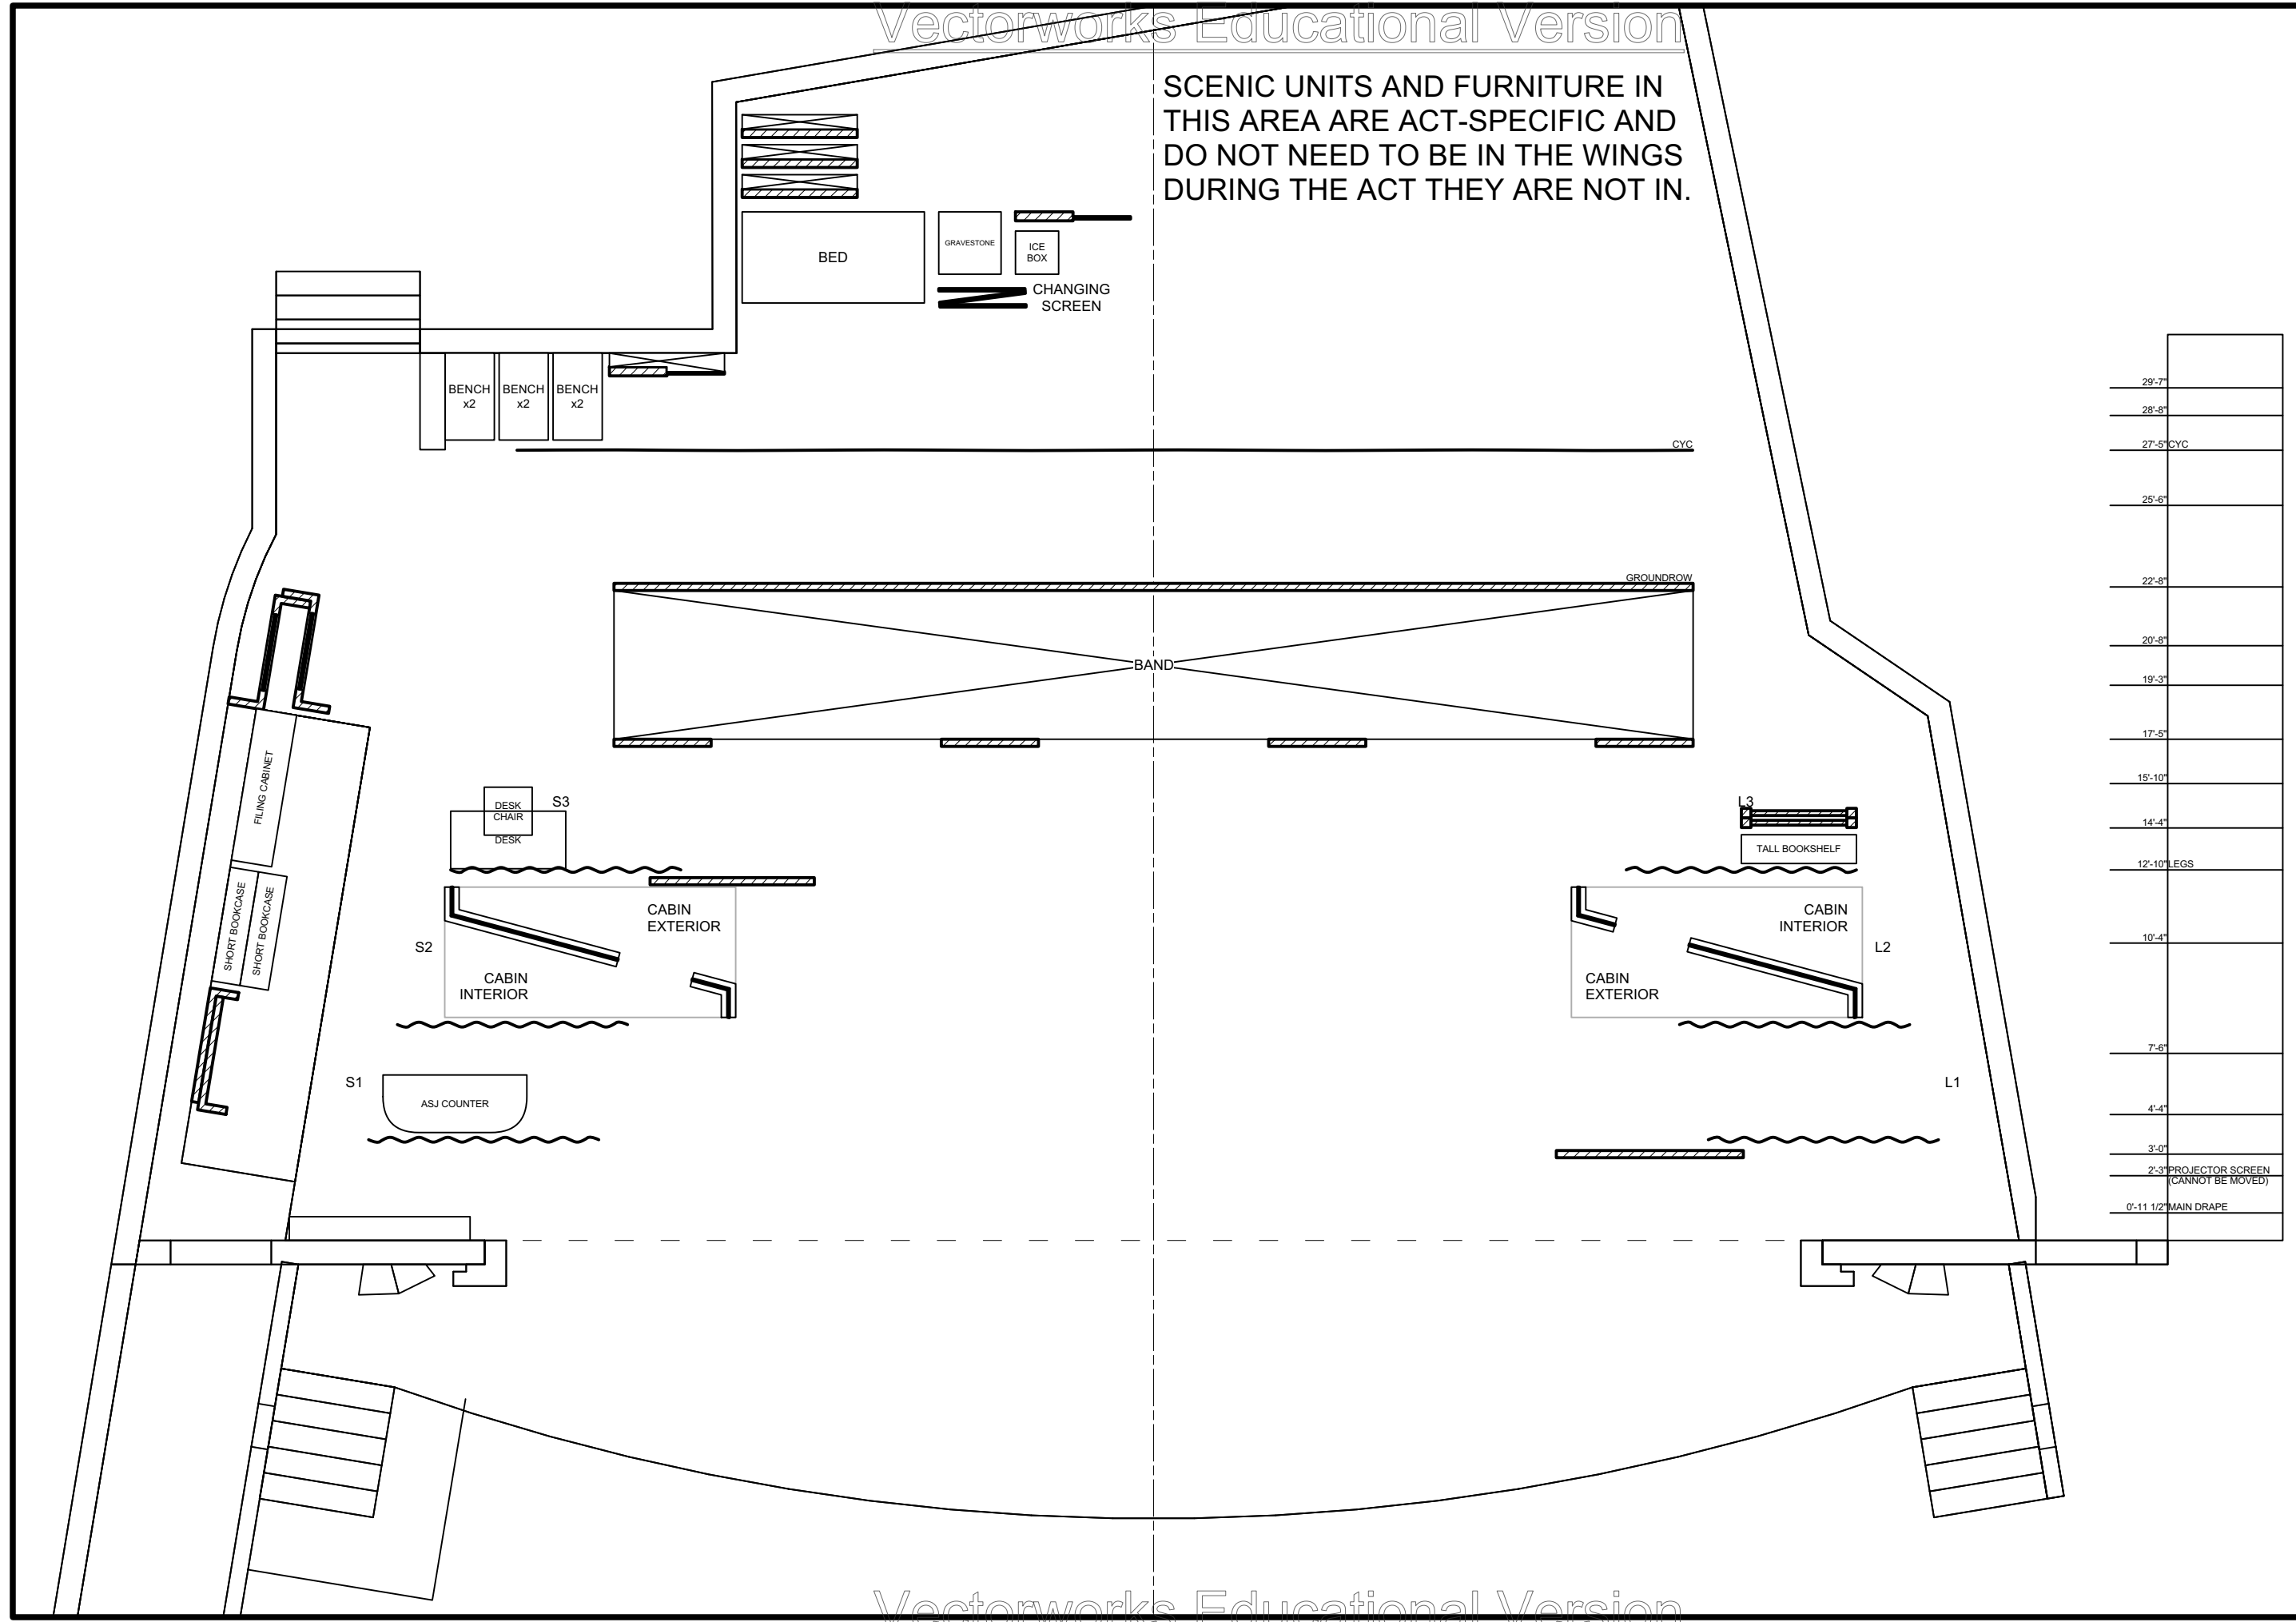

29'-7"
28'-8"
27'-5" CYC
25'-6"
22'-8"
20'-8"
19'-3"
17'-5"
15'-10"
14'-4"
12'-10" LEGS
10'-4"
7'-6"
4'-4"
3'-0"
2'-3" PROJECTOR SCREEN (CANNOT BE MOVED)
0'-11 1/2" MAIN DRAPE

**Disclaimer:**  
 Drawings are only meant only to illustrate ideas and are not intended to be used as a structural or mechanical drawing. The designer must be evaluated and stamped by a certified technical director before construction. The designer does not assume any liability for structural integrity in the designs. The company selected to build the designs will assume all liability to its structural integrity and related consumer, crew and performer safety.

*Brandon M. Newton*  
 Scenic Designer Signature

Venue: Actor's Playhouse  
 Stage: Mainstage Theatre  
 Director: David Arisco  
 Technical Director: Gene Seyffer

Show Title: BRIGHT STAR

Sheet Title: A2 Offstage Positions  
 Date: 02 Mar 2023  
 Designer: Brandon M. Newton  
 Scale: 1/4" = 1'-0"  
 Drawn By: Brandon M. Newton

Sheet Number: GP-000 of 0